



DETAIL: TRENCH LAYOUT
SCALE: 1 : 10

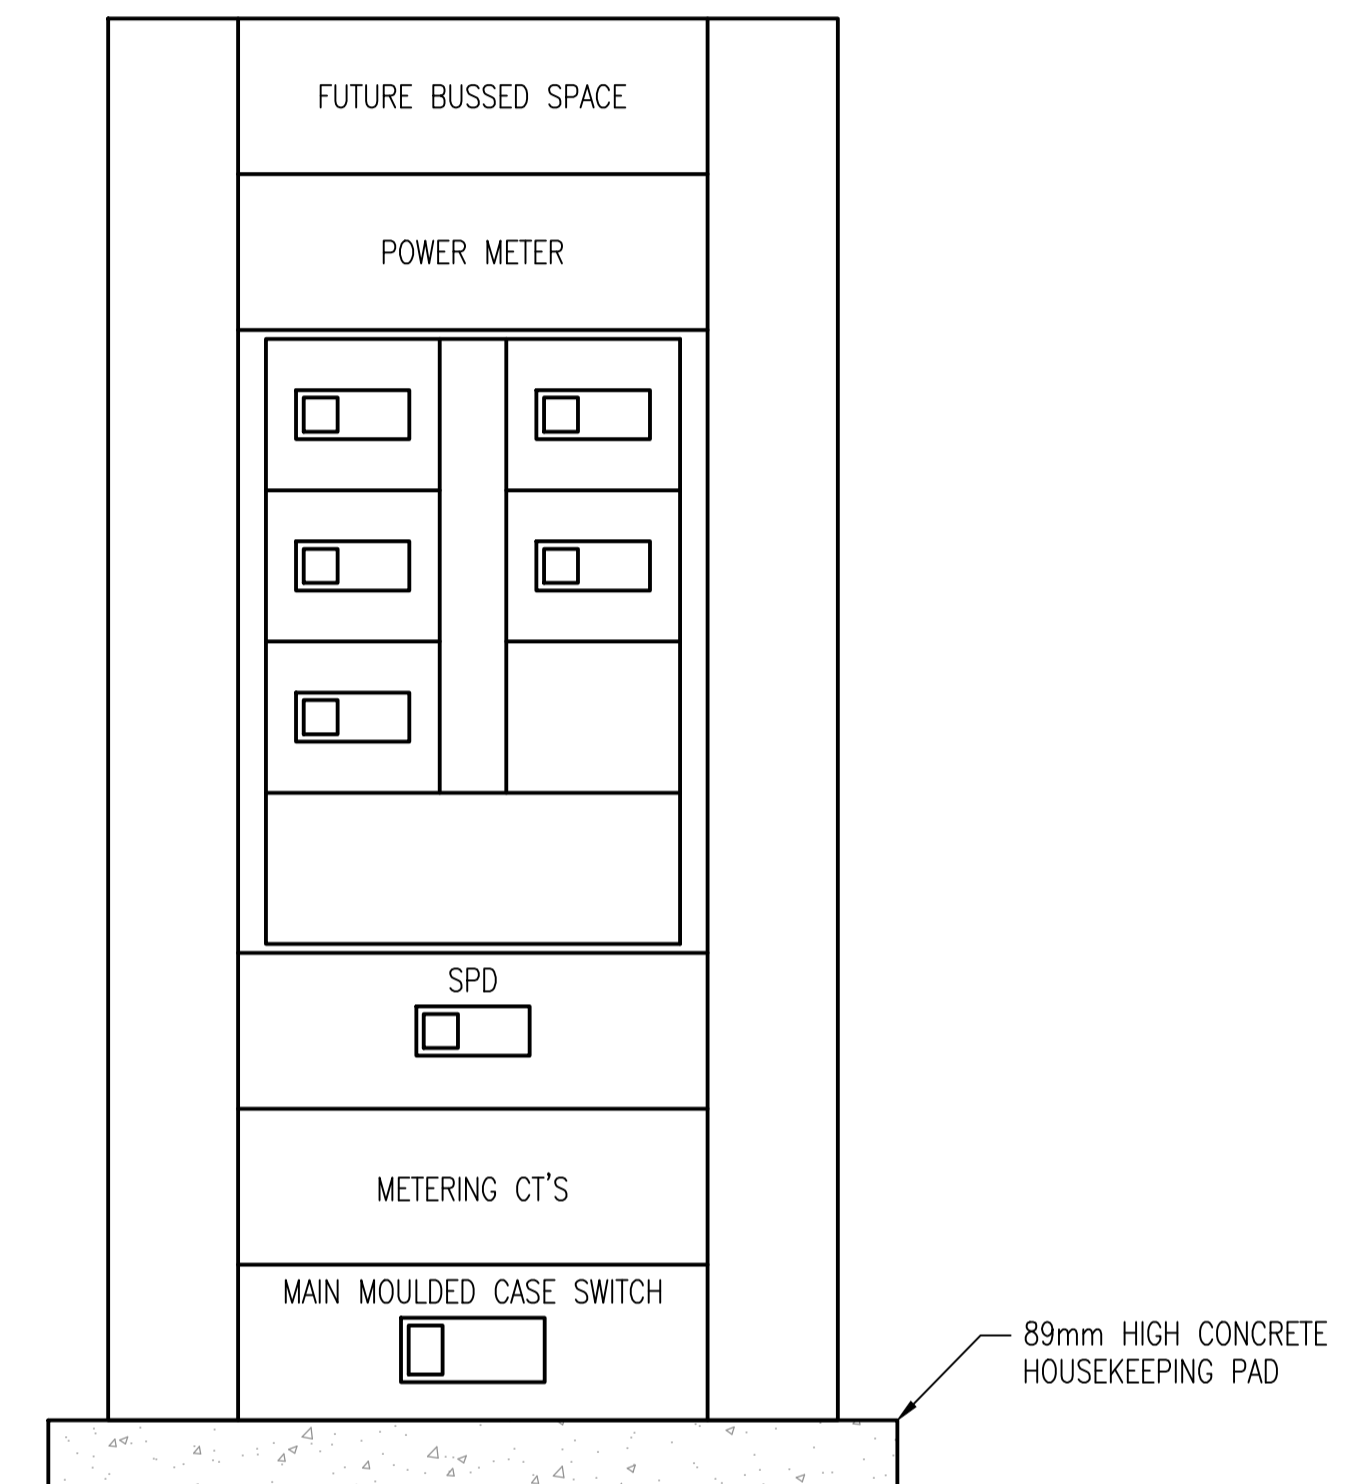

MAIN DISTRIBUTION PANEL ELEVATION
SCALE: NTS

- NOTES:**
- SUPPLY AND INSTALL GALVANIZED METAL COVER PLATES OVER THE CABLE ENTRY AT BOTH ENDS OF THE BURIED CABLE.
 - SUPPLY AND INSTALL CP-PNL-L1 LAMACOID ON THE CSTE, ADJACENT TO THE CB-PNL-L1 BREAKER.

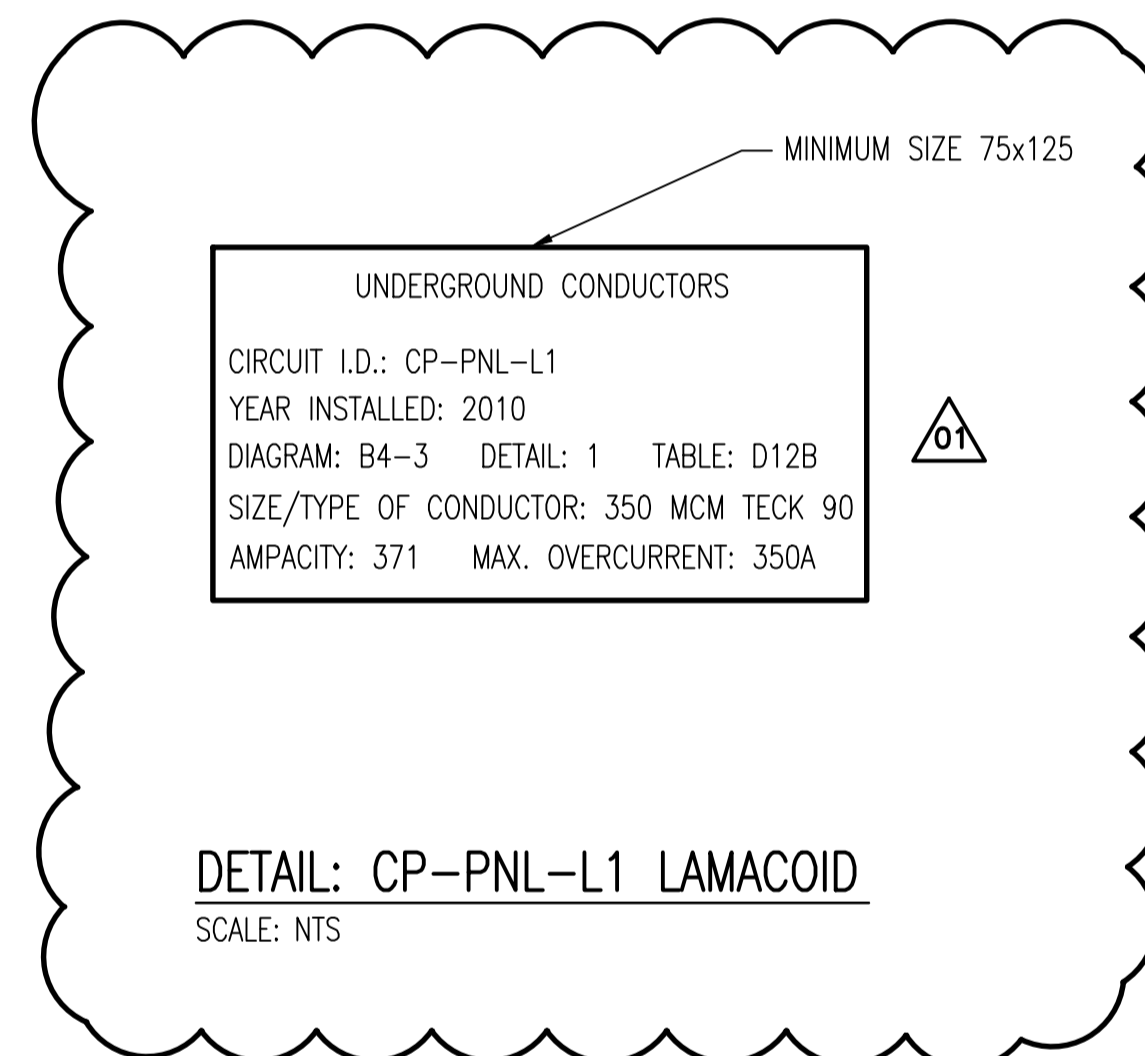

NO.	REVISIONS	DATE	DESIGN	CHECK
01	ADDENDUM 2	2010/10/08	BC	CJR
00	ISSUED FOR TENDER	2010/09/29	BC	CJR

<p>SNC-LAVALIN INC. 148 Nature Park Way Winnipeg, MB, Canada R3P 0X7 204-786-8080</p>	
DESIGNED BY: B. CLEVEN	CHECKED BY: C. REIMER
DRAWN BY: S. COATES	APPROVED BY: C. REIMER
SCALE: AS SHOWN	RELEASED FOR CONSTRUCTION BY: K. ZUREK
DATE: 2010/07/29	DATE: 2010/10/04
CONSULTANT NO.: 113368-0000-47DD-0016	

ENGINEER'S SEAL

ORIGINAL DRAWING
SEALED BY:
C. REIMER
SNC-LAVALIN INC.
2010/10/08
REV. 01

BID OPP.: 760-2010

THE CITY OF WINNIPEG
WATER AND WASTE DEPARTMENT

MARION WASTEWATER PUMPING STATION
INSTALLATION OF PUMPING UNITS & BUILDING UPGRADES
ELECTRICAL DETAILS

CITY DRAWING NUMBER: 1-0159L-E0016

SHEET	REV.	SIZE
001	01	A1

1-0159L-C0001	SITE PLAN
DRAWING NUMBER	REFERENCE DRAWINGS