
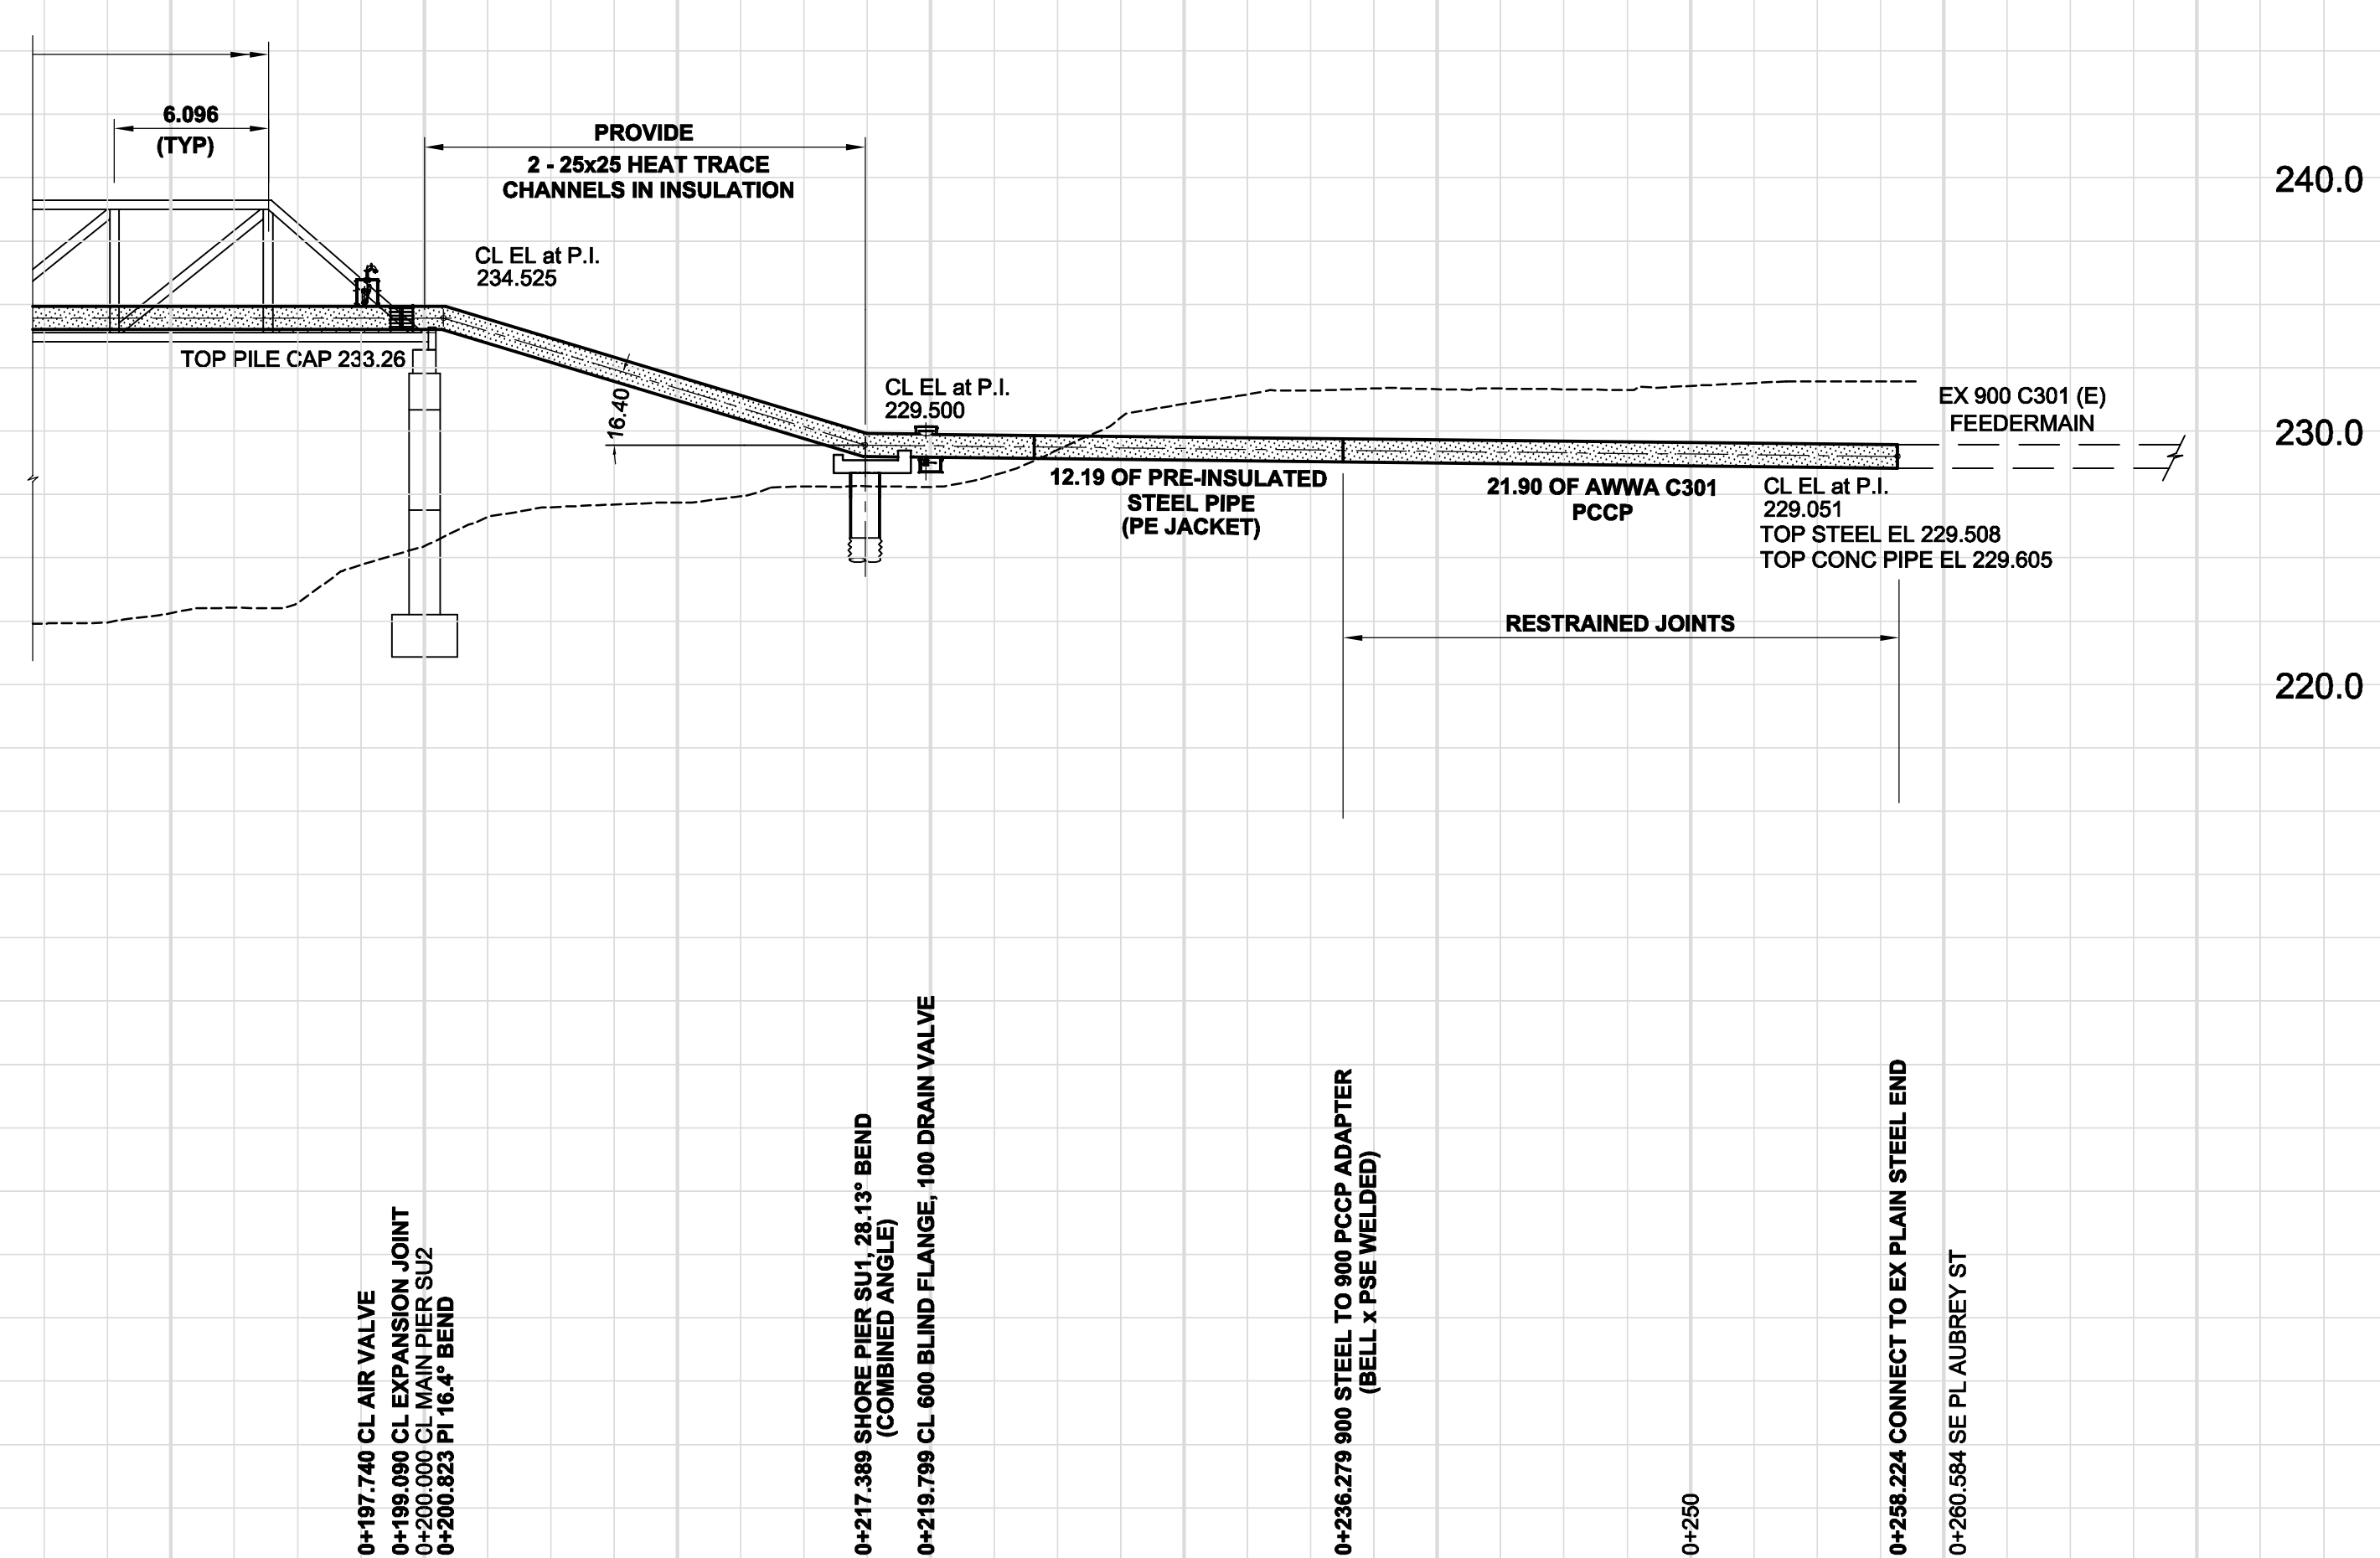


D SIZE 22" x 34" (559mm x 864mm)



PLOT: 11/05/21 9:15:08 AM

AECOM REVIEW DRFT CHK MGM  
AECOM FILE NAME: D285-230-02\_01-C-1003\_RX.dwg Saved By: [Name]

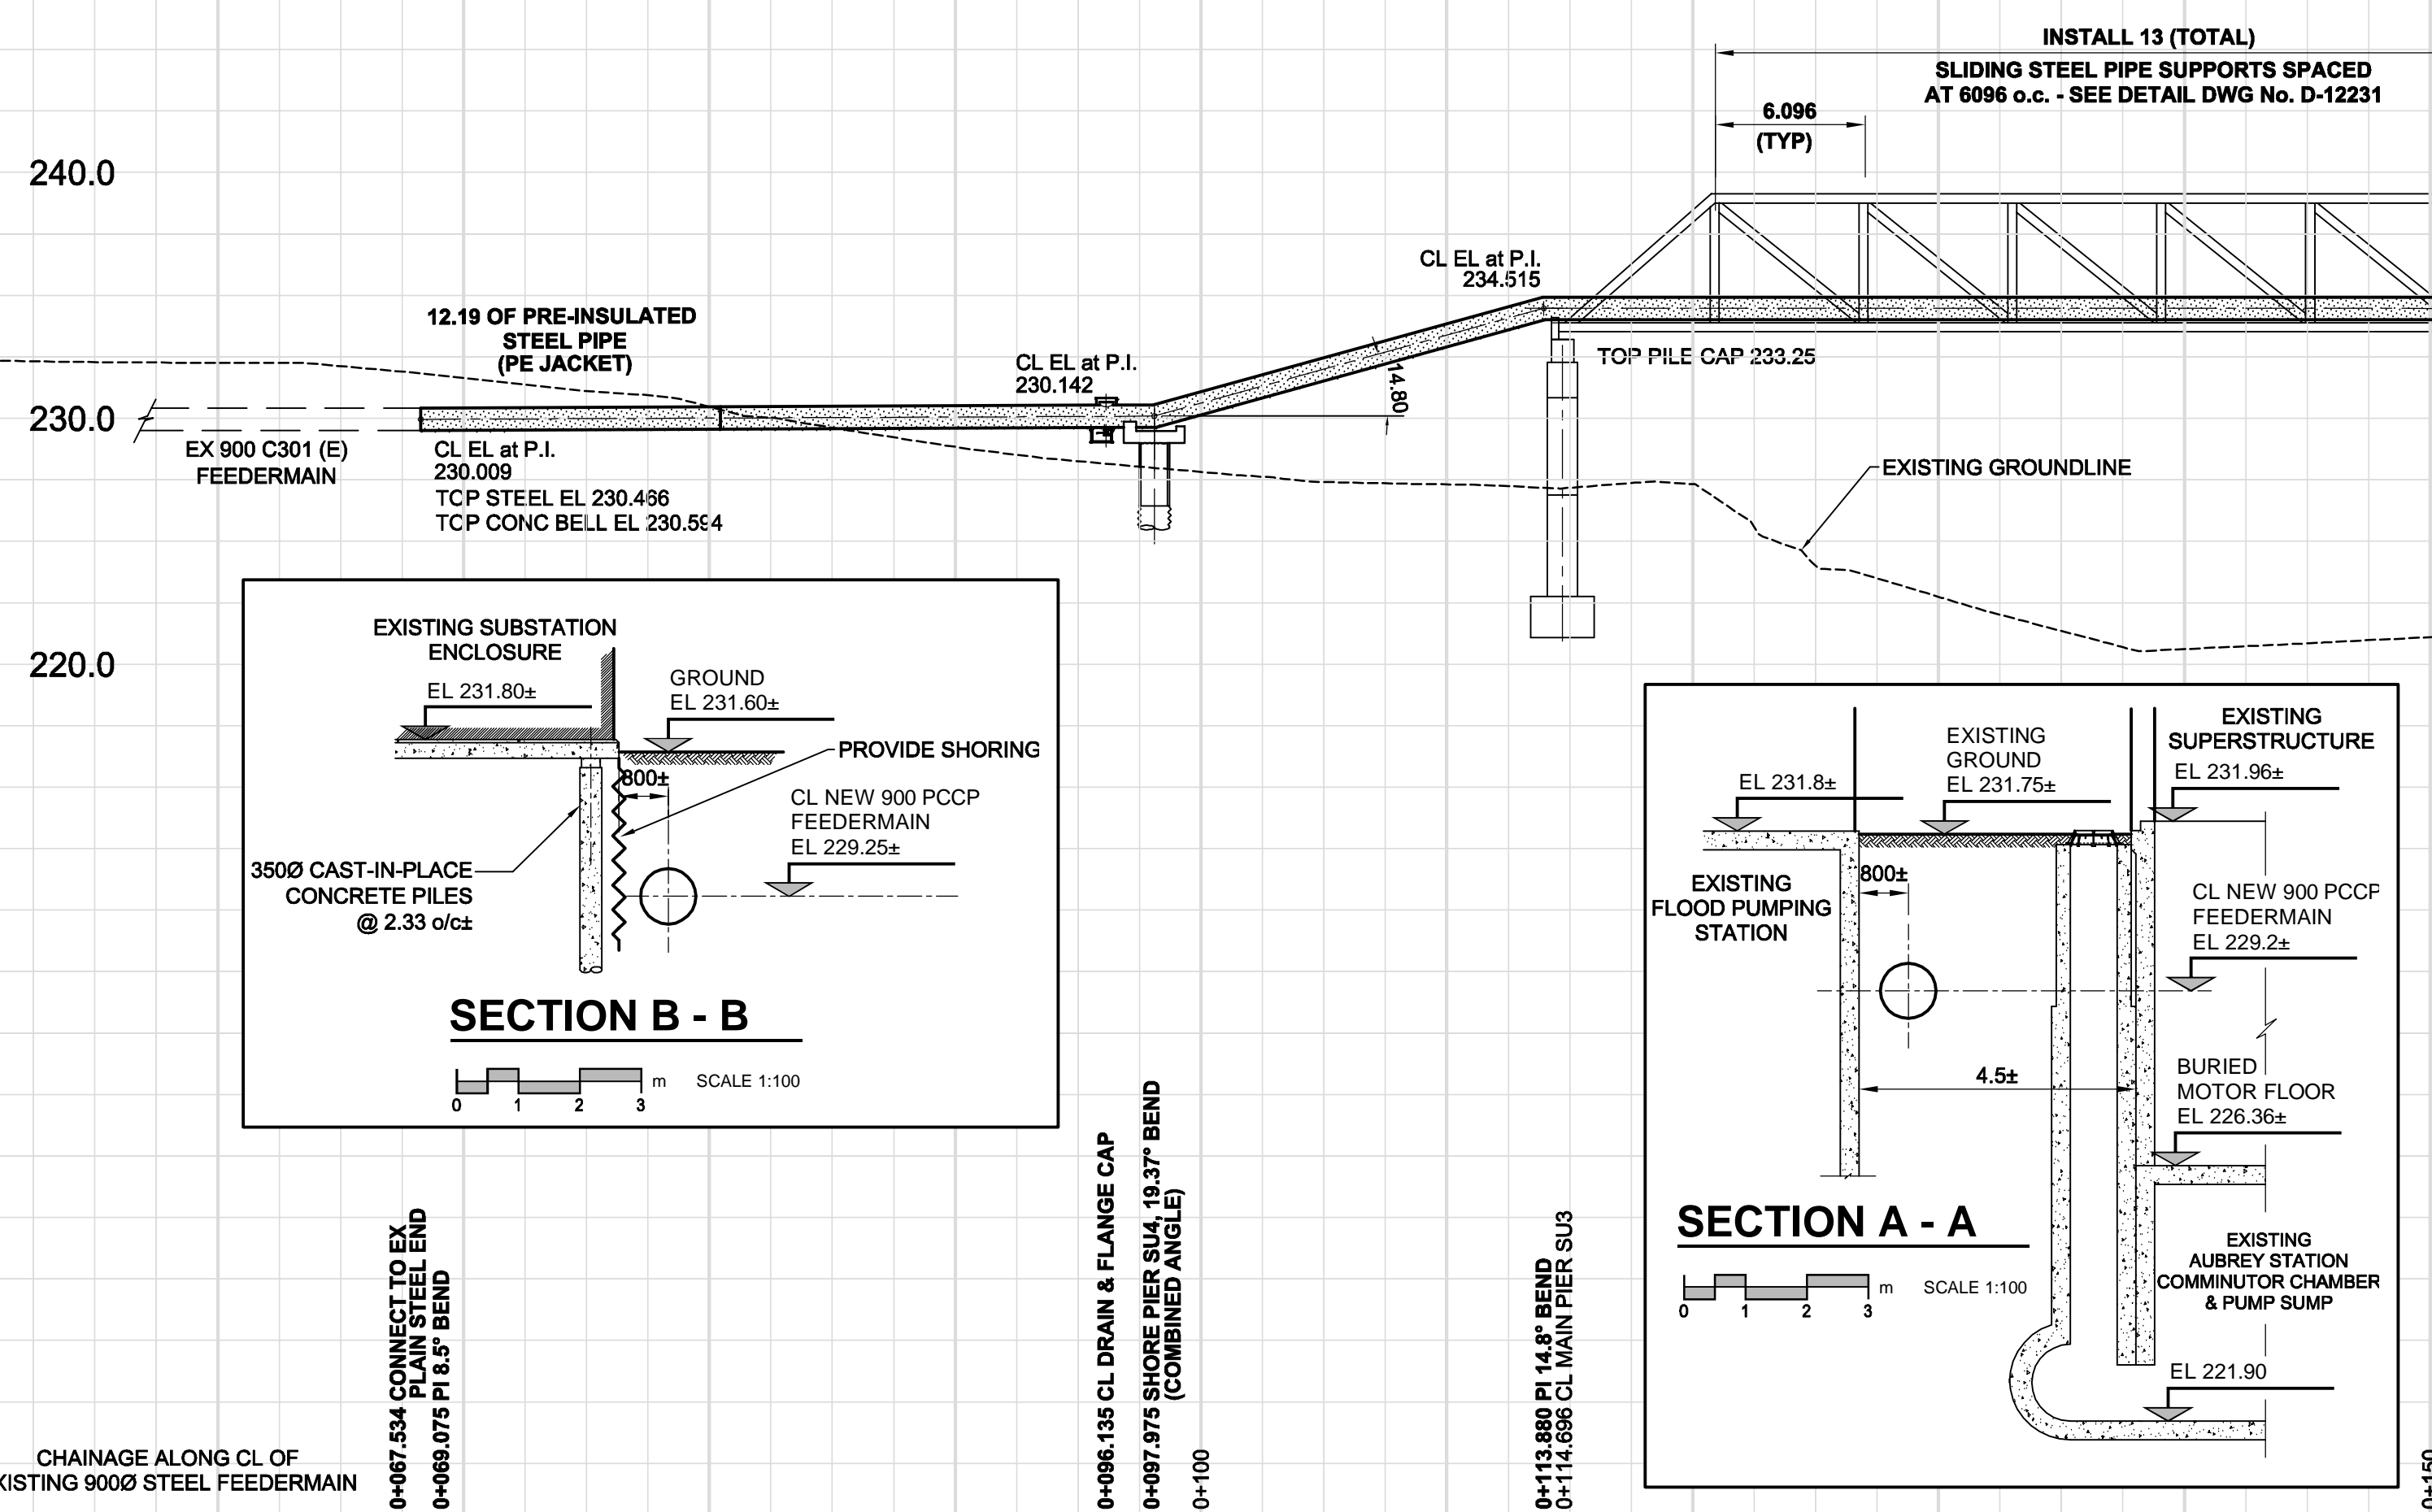

PIPE & PIER COORDINATE TABLE

POINT	NORTHING	EASTING
CONNECT TO EX PLAIN STEEL END	5526407.963	631043.371
8.5" BEND	5526409.405	631043.920
CL SHORE PIER SU4, 900Ø BEND	5526437.650	631049.985
CL MAIN PIER SU3	5526452.854	631056.932
CL MAIN PIER SU2	5526530.443	631092.384
SHORE PIER SU1, 900Ø BEND	5526546.225	631099.679
CONNECT TO EX PLAIN STEEL END	5526587.038	631101.022

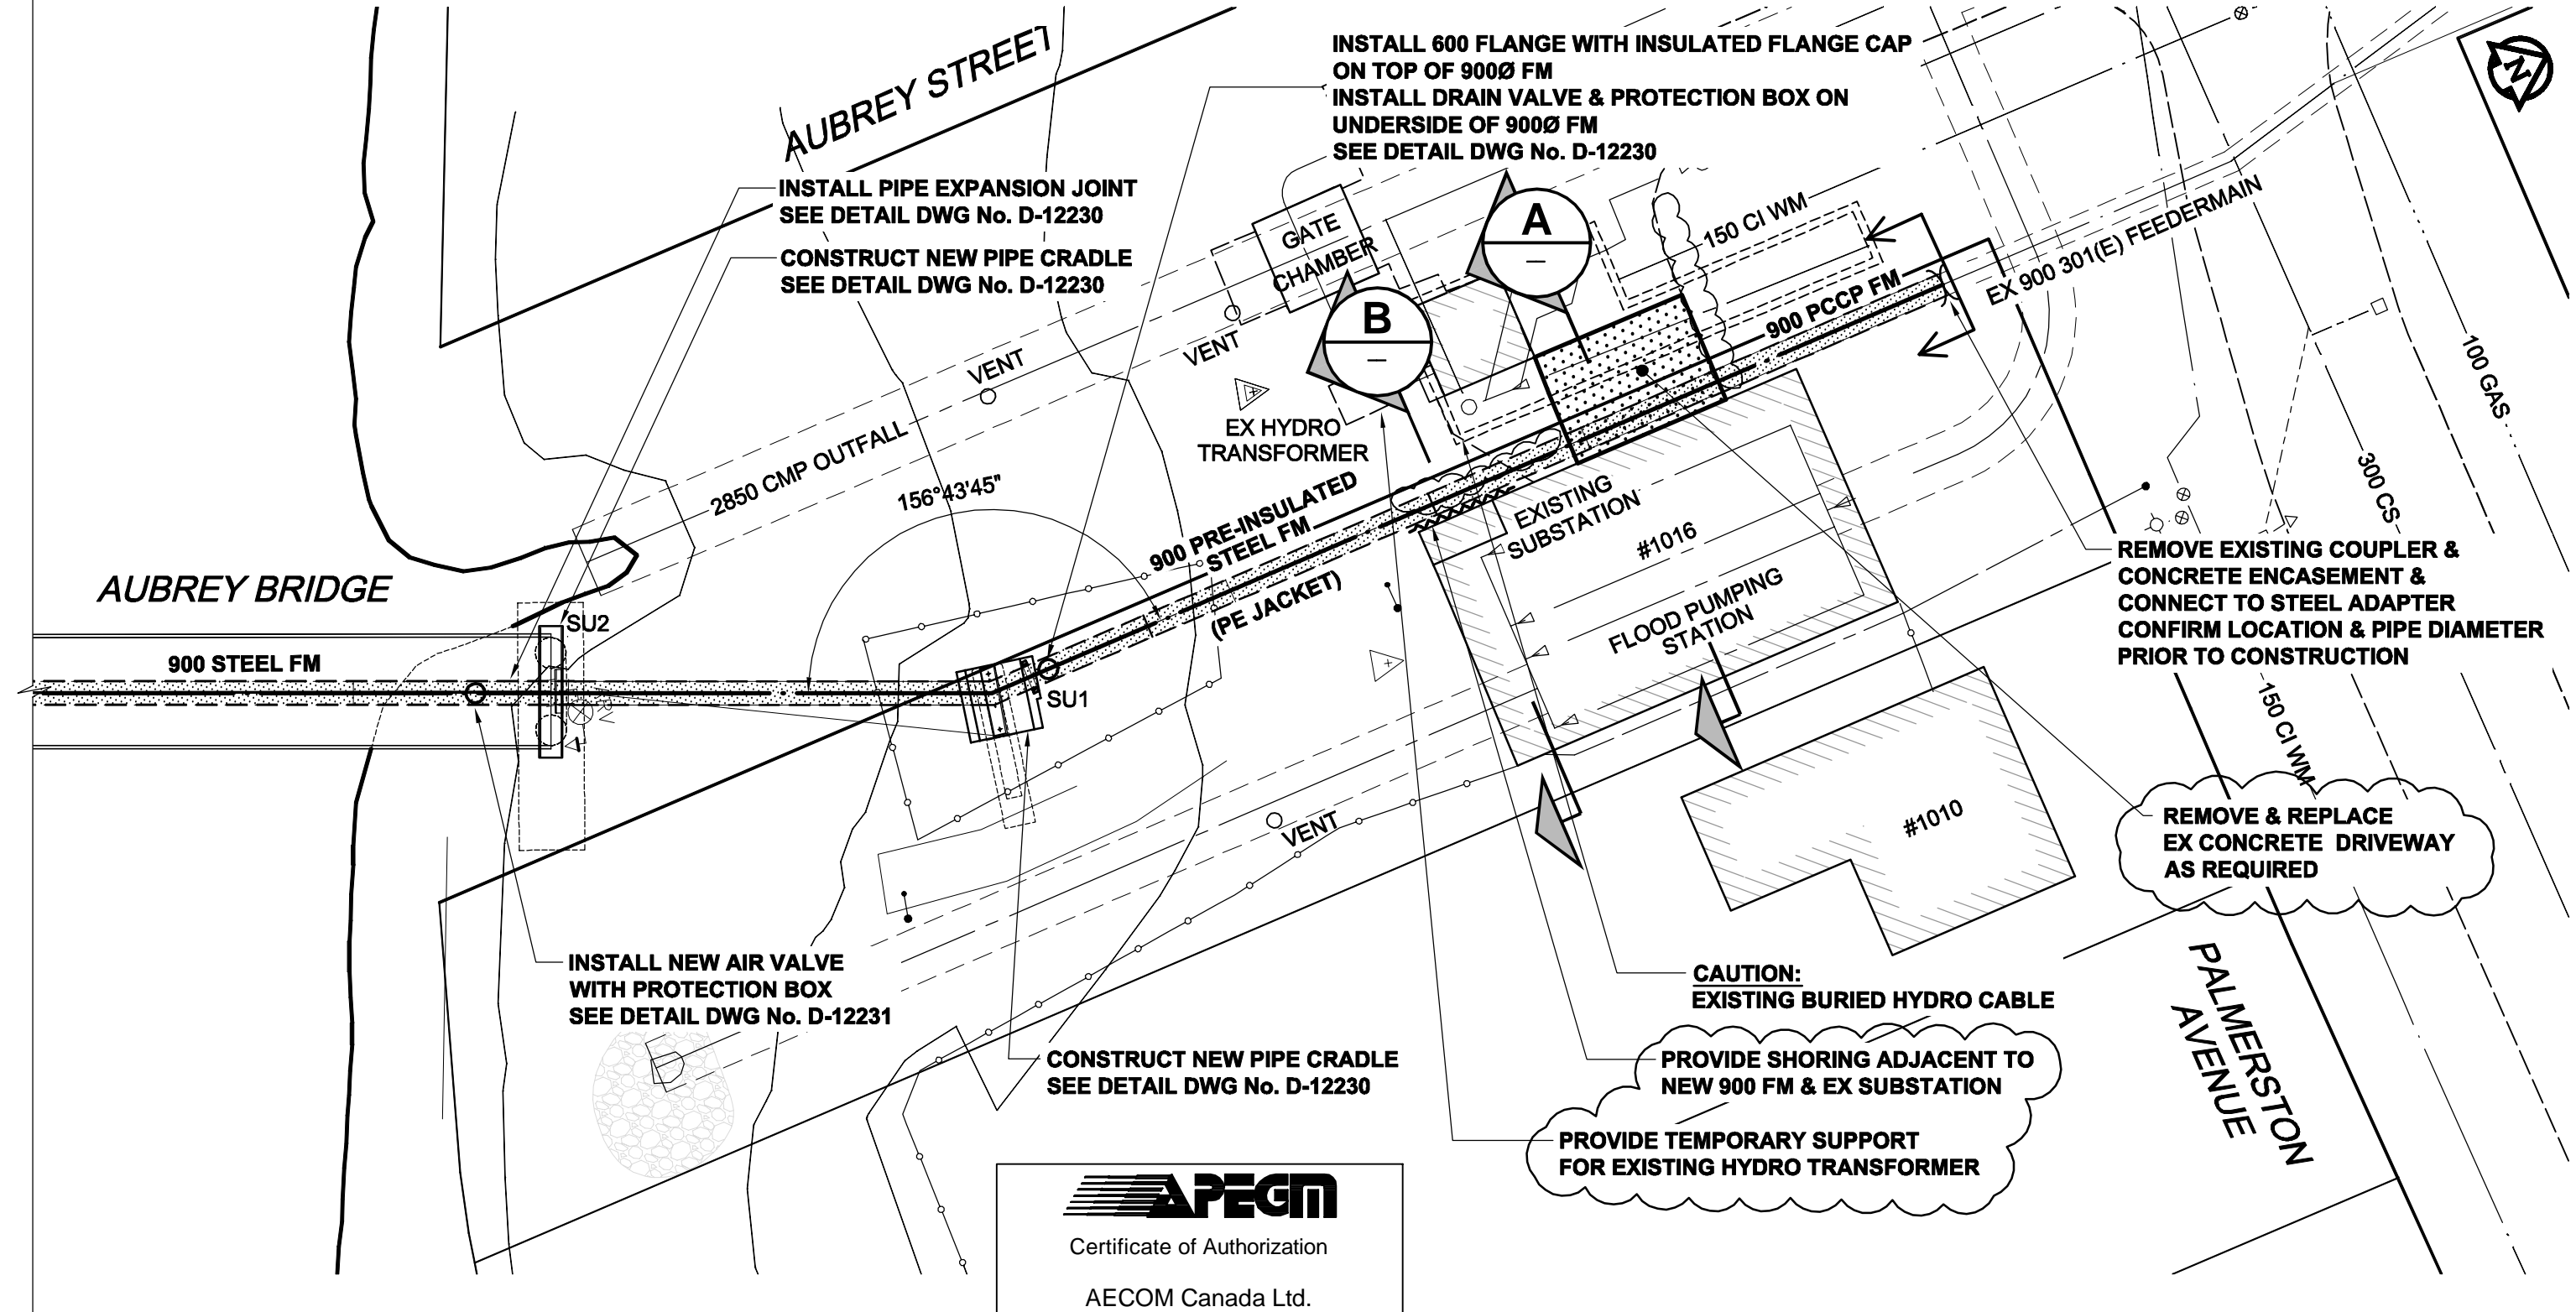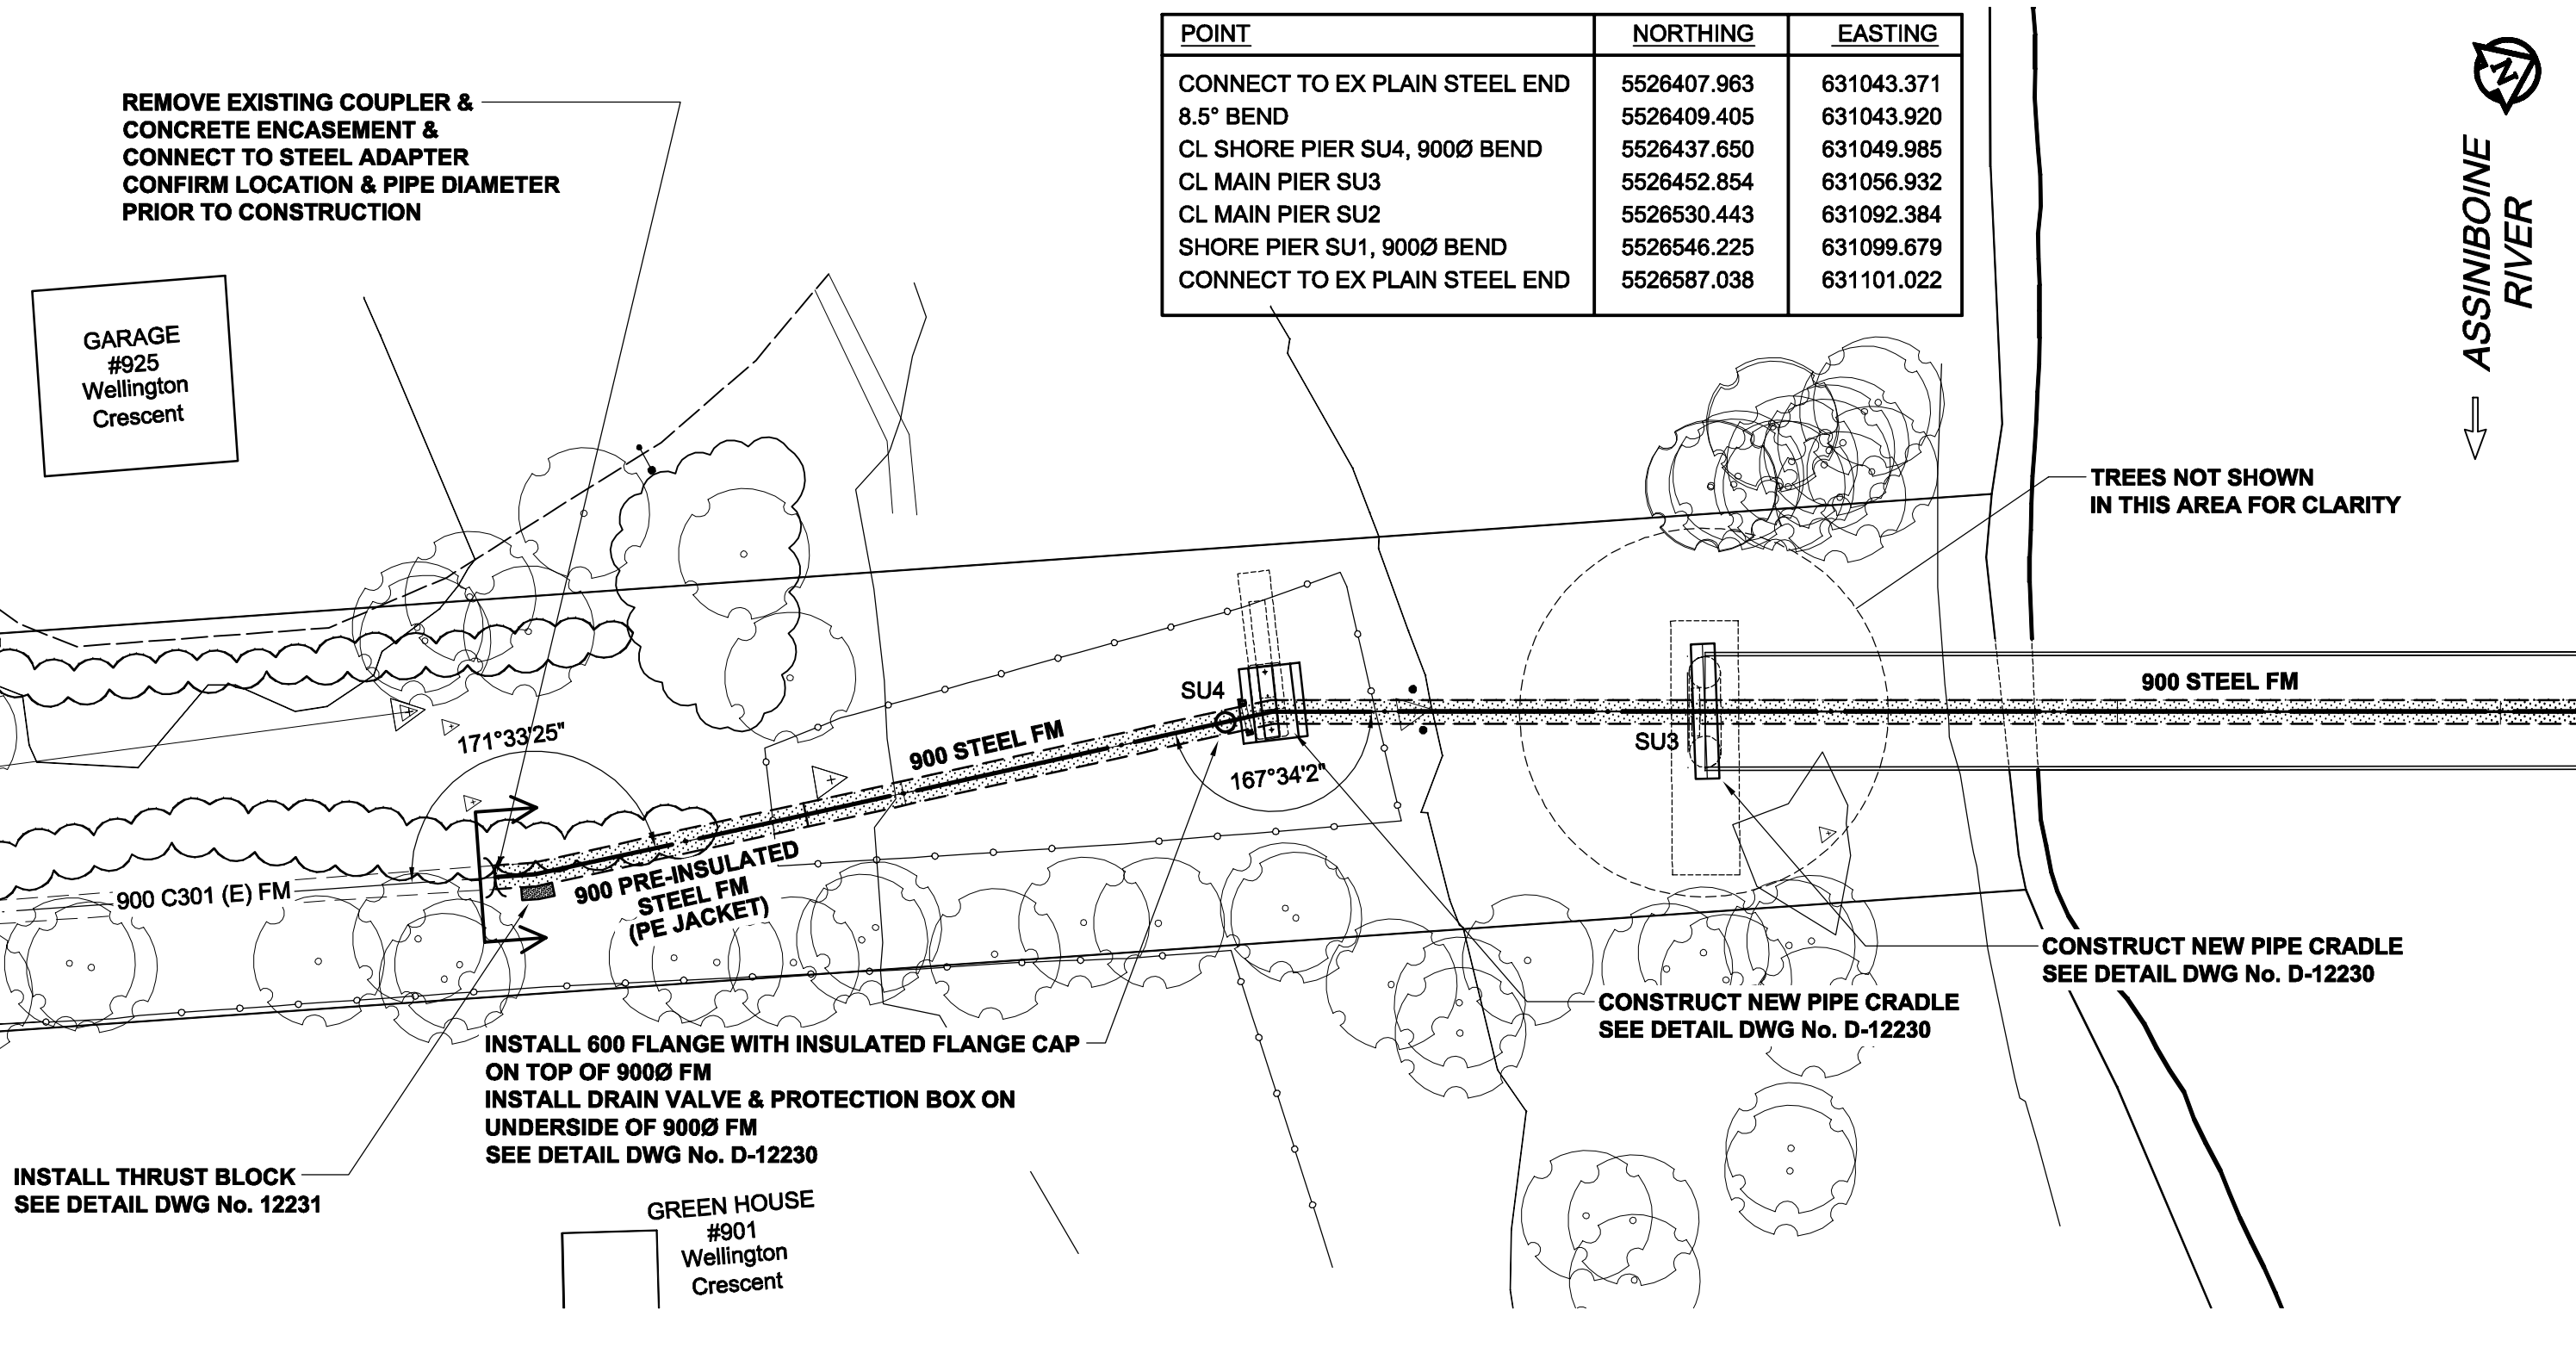

EXISTING	LEGEND - PLAN	NEW	EXISTING	LEGEND - PLAN	NEW	EXISTING	LEGEND - PROFILE	NEW
150 WM	WATERMAIN	150 WM	150 WM	WATERMAIN	150 WM	300 LDS	LAND DRAINAGE SEWER	300 LDS
300 LDS	LAND DRAINAGE SEWER	300 LDS	250 WWS	WASTE WATER SEWER	250 WWS	MANHOLE	MANHOLE	MANHOLE
250 WWS	WASTE WATER SEWER	250 WWS	CATCH BASIN	CATCH BASIN	CATCH BASIN	CURB INLET	CURB INLET	CURB INLET
PIPE ABANDONMENTS	PIPE ABANDONMENTS	PIPE ABANDONMENTS	SURVEY BAR	SURVEY BAR	SURVEY BAR			

**LOCATION APPROVED UNDERGROUND STRUCTURES**

SUPR. U/G STRUCTURES DATE COMMITTEE

**NOTE:** LOCATION OF UNDERGROUND STRUCTURES AS SHOWN ARE BASED ON THE BEST INFORMATION AVAILABLE. BUT NO GUARANTEE IS GIVEN THAT ALL EXISTING UTILITIES ARE SHOWN OR THAT THE GIVEN LOCATIONS ARE EXACT. CONFIRMATION OF EXISTENCE AND EXACT LOCATION OF ALL SERVICES MUST BE OBTAINED FROM THE INDIVIDUAL UTILITIES BEFORE PROCEEDING WITH CONSTRUCTION.

NO.	REVISIONS	DATE	BY
1	REVISED AS PER ADDENDUM No. 1	11/05/20	WJd
0	ISSUED FOR CONSTRUCTION	11/05/09	WJd

DESIGNED BY	MG	CHECKED BY	FMI
DRAWN BY	WJd	APPROVED BY	Andy Nagy
HOR. SCALE	1:250	RELEASED FOR CONSTRUCTION	
VERT. SCALE	1:250	DATE	

**APECM**  
Certificate of Authorization  
AECOM Canada Ltd.  
No. 4671 Date: 30 May 2011

PROFESSIONAL'S SEAL

Revision 1  
Revised As Per Addendum No. 1  
Signed & Sealed By:  
C. C. MACEY  
30 May 2011

**THE CITY OF WINNIPEG**  
WATER AND WASTE DEPARTMENT

REHABILITATION / REPLACEMENT OF THE  
MID TOWN FEEDERMAIN AT THE  
ASSINIBOINE RIVER

CIVIL  
PIPE PLAN AND PROFILES  
South & North Connections

SHEET 3 OF 18  
CITY DRAWING NUMBER  
D-12229  
REV 1

BID OPPORTUNITY NO. 854-2010