




PLAN OF SERVICE MANHOLE/MAIN DRAIN PIT
SCALE: 1/2"=1'-0"

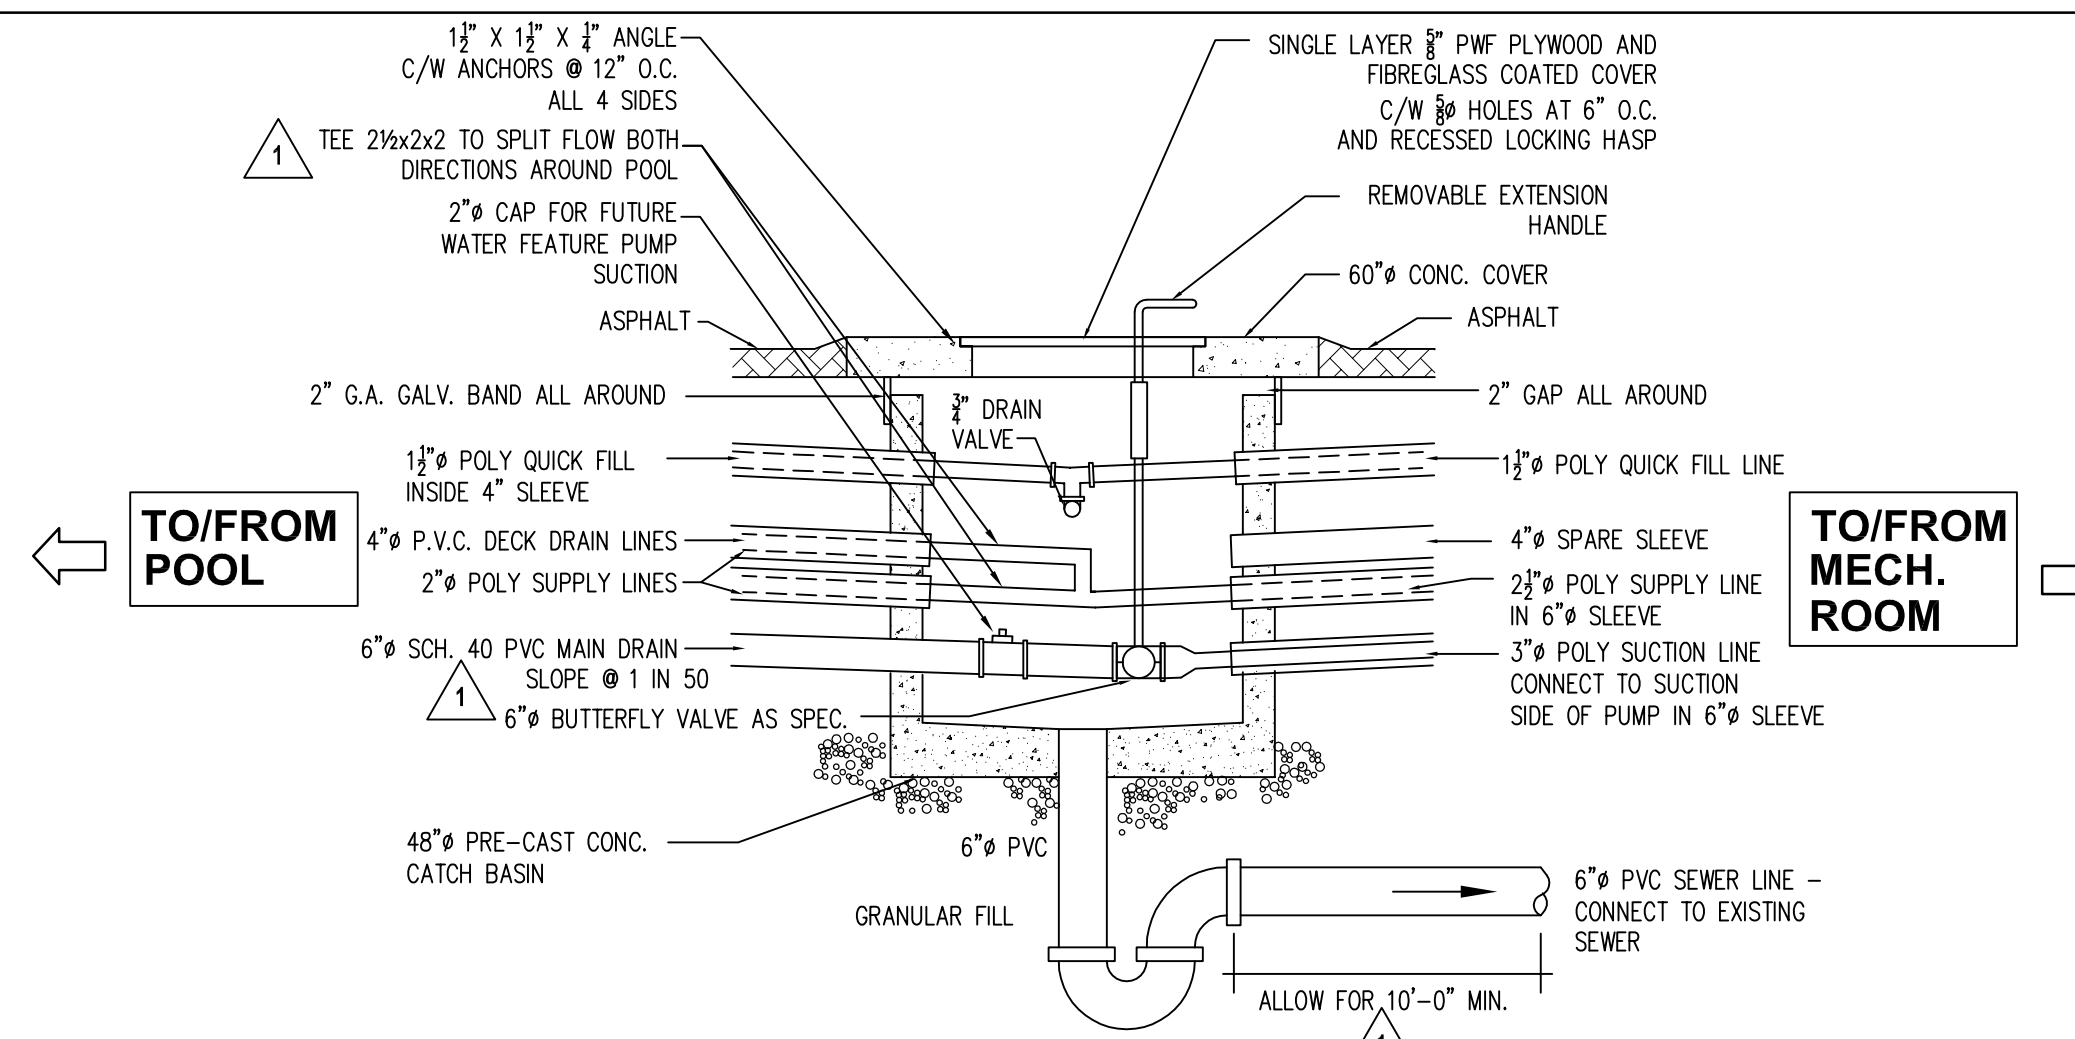


SERVICE MANHOLE SECTION
N.T.S.

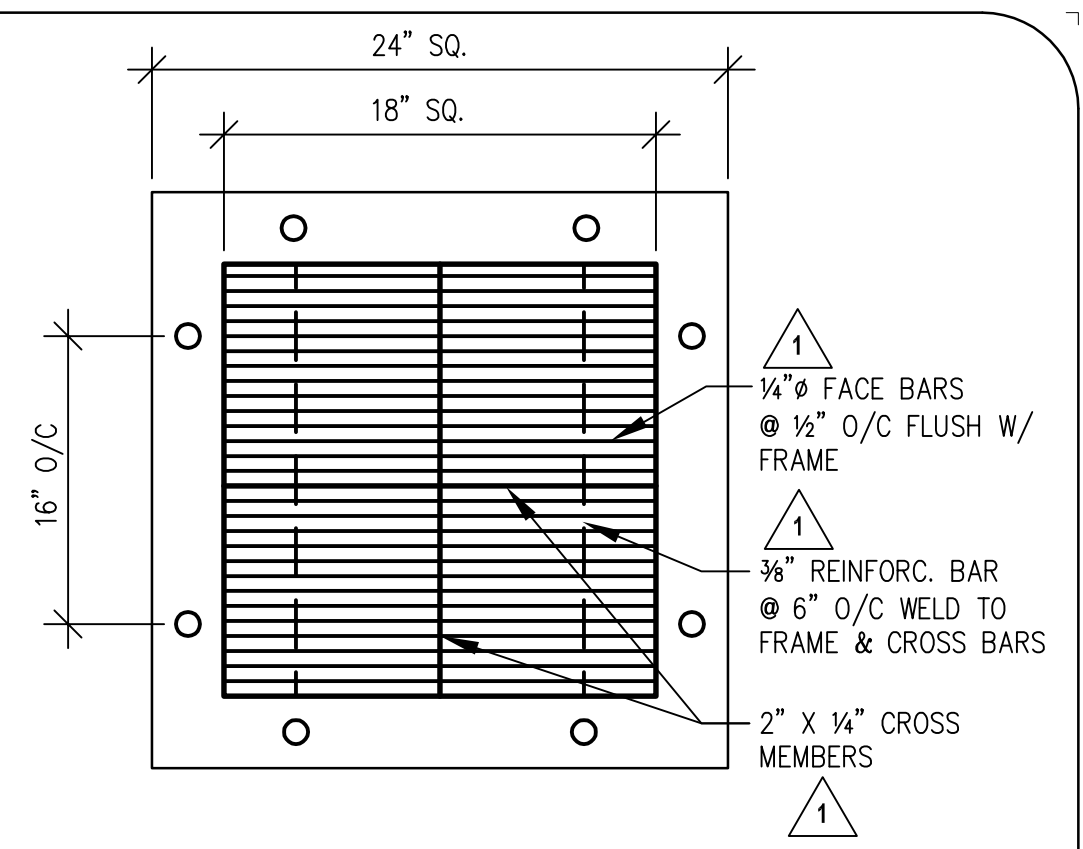


FLOOR DRAIN GRATE DETAIL (CUSTOM)
SCALE: 1 1/2" = 1'-0"
(TO BE CUSTOM MANUFACTURED OF TYPE 304 S.S.)

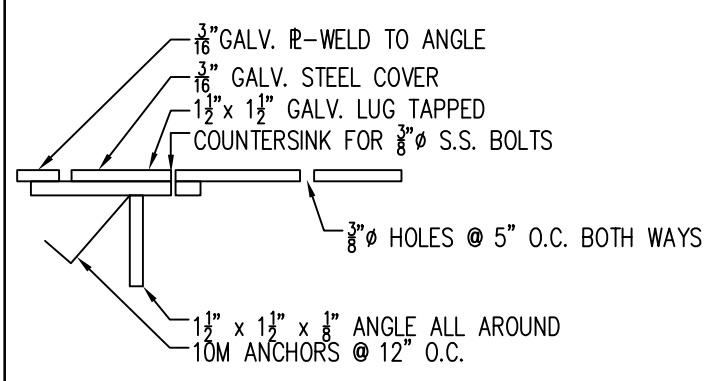


DRAIN COVER DETAIL
SCALE: 1/2"=1'-0"
REFER TO DRAWING A-2

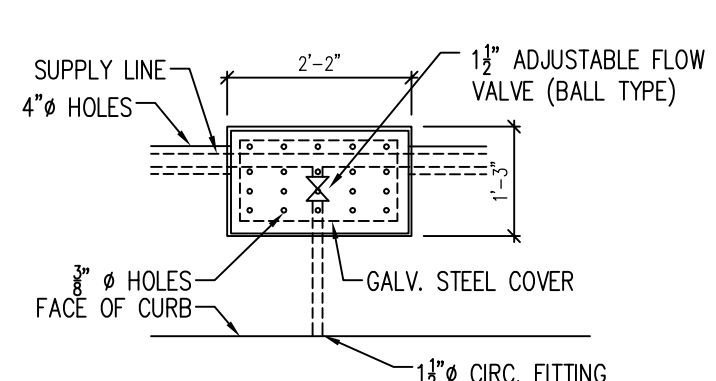


DRAIN COVER PLAN
SCALE: 1/2"=1'-0"
REFER TO DRAWING A-2

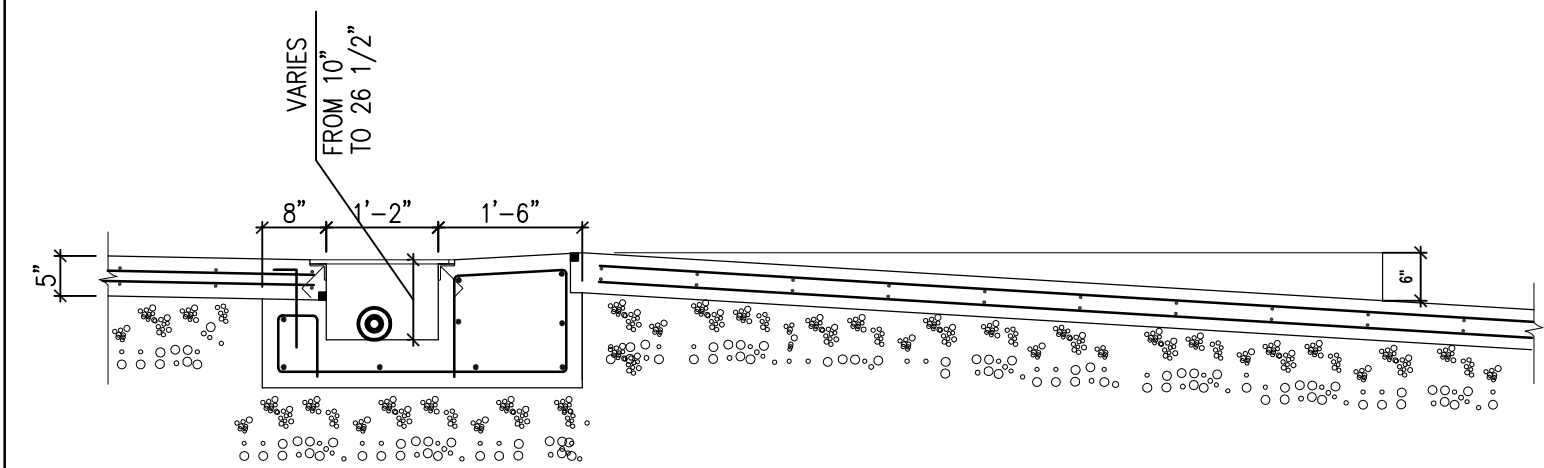

DRAINAGE BOX SECTION
SCALE: 1/2"=1'-0"
REFER TO DRAWING A-2

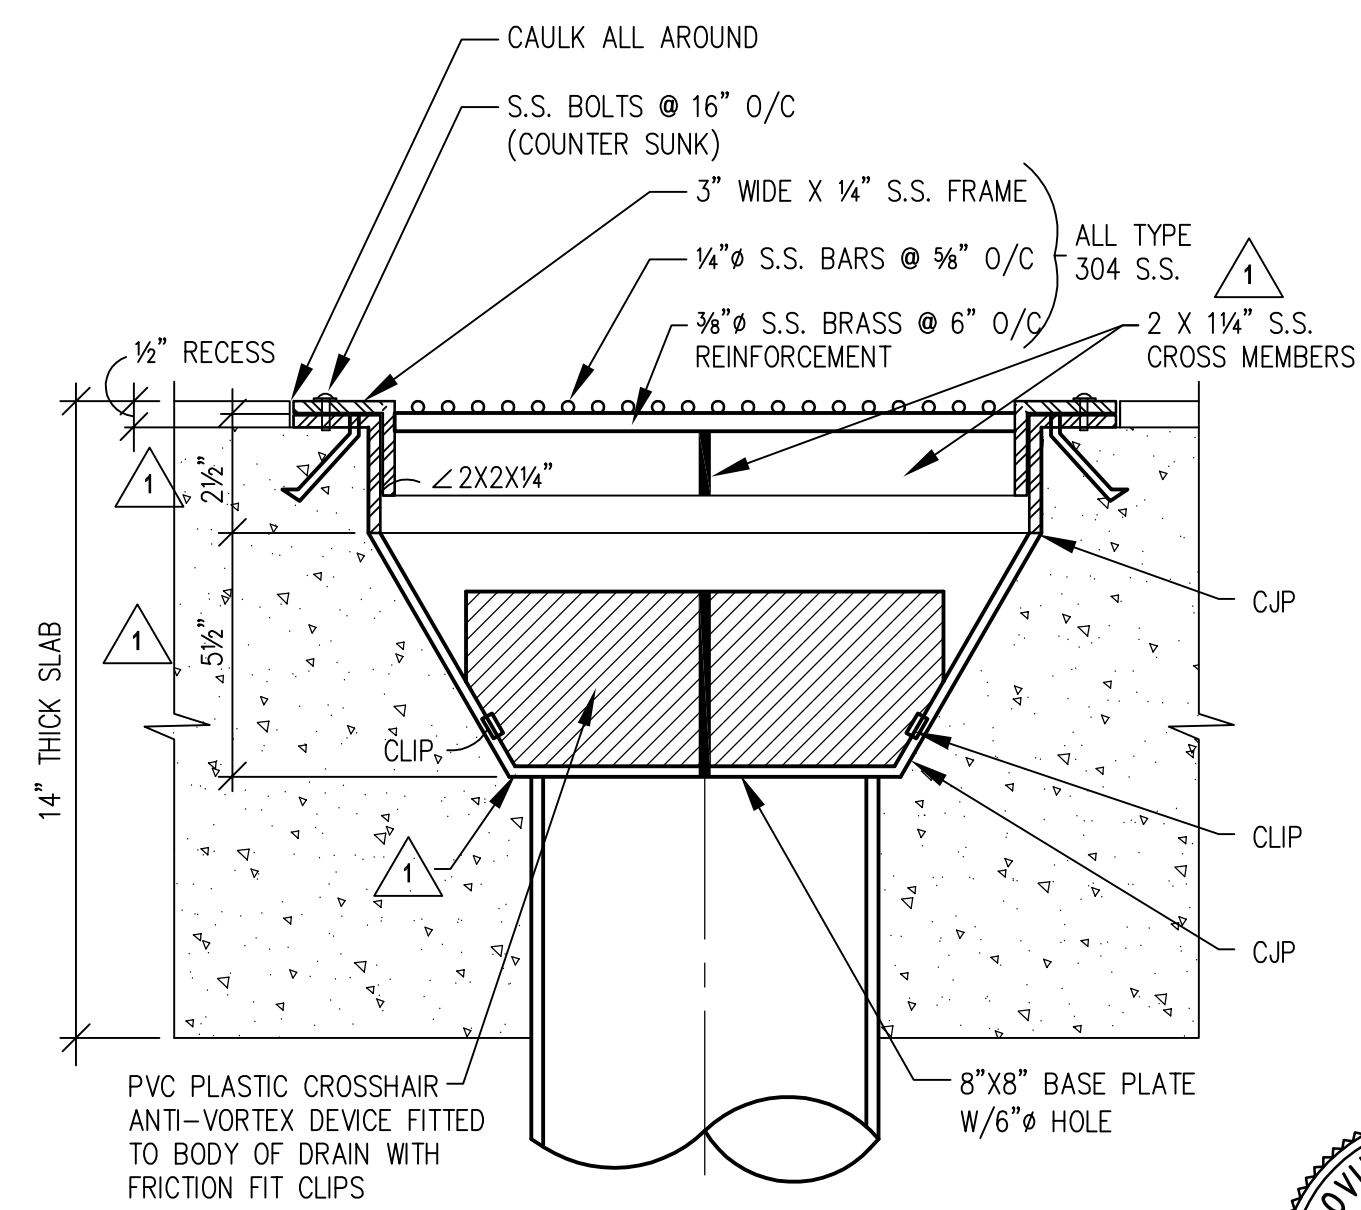

FLOOR DRAIN GRATE DETAIL
SCALE: 3" = 1'-0"
PRIOR TO CONSTRUCTION. SUBMIT SHOP DRAWING OF DRAIN FOR APPROVAL.

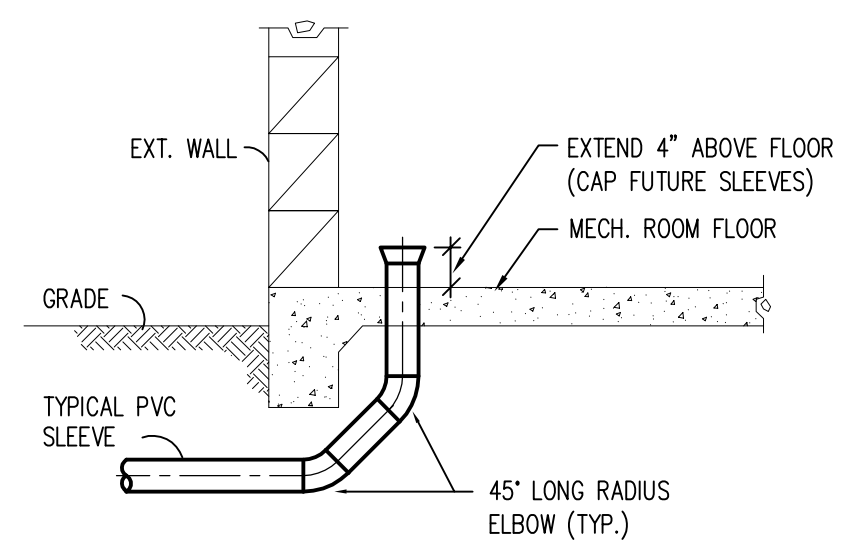

TYPICAL PIPING SLEEVE DETAIL IN BUILDING
N.T.S.
NOTE: ALL PIPE SLEEVES (INCLUDING PIPING AT POOL PERIMETER) TO HAVE LONG RADIUS ELBOWS (2 @ 45° FOR 90° BENDS)

No.	Description	Date (m/d/y)	Drawn	Checked
1	GENERAL REVISIONS	01/25/12	DMM	JHG
0	ISSUED FOR TENDER	01/05/12	AB	JHG

Revisions/Issuance (Read Up)
Designed By: DMM, Drawn By: AB, Checked By: JHG, Approved By: JHG


THE CONTRACTOR IS TO VERIFY DIMENSIONS AND DATA NOTED ON THE STRUCTURAL DRAWINGS WITH CONDITIONS ON THE SITE. CO-ORDINATE ALL DIMENSIONS WITH THE ARCHITECTURAL DRAWINGS. AND IS HELD RESPONSIBLE FOR REPORTING ANY DISCREPANCIES TO THE ENGINEER BEFORE PROCEEDING WITH THE WORK. VARIATIONS AND MODIFICATIONS TO WORK SHOWN ON THE STRUCTURAL DRAWINGS SHALL NOT BE CARRIED OUT WITHOUT WRITTEN PERMISSION FROM THE ENGINEER. THIS DRAWING IS NOT TO BE SCALED.

Lavergne Draward & Associates Inc.
402-138 Portage Avenue East
Winnipeg, Manitoba
R3C 0A1
Tel 204 947-2222
Fax 204 947-2522
E mail general@ldaeng.ca
Web www.ldaeng.ca


Client: CITY OF WINNIPEG
Project Title: KING EDWARD PARK WADING POOL REPLACEMENT
709, MANHATTAN AVE. WINNIPEG, MB.
Bid Opportunity Number: 1010-2011

MECHANICAL DETAILS


Scale: AS SHOWN, Date: JAN. 25, 2012
File Number: 31-219, Sheet Number: M3-R1

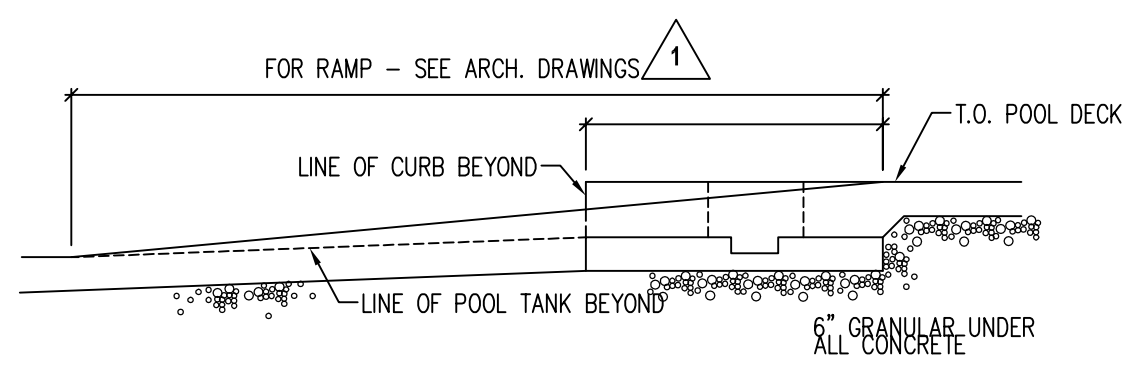

SECTION - ZERO ENTRY RAMP
SCALE: 1/2"=1'-0"
REFER TO DRAWING A-2

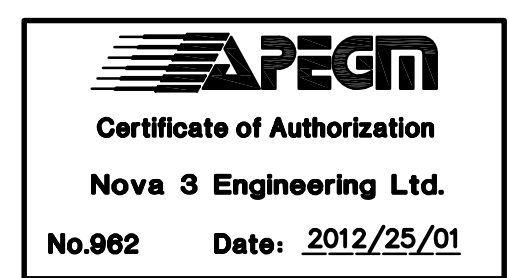

NOVA 3 ENGINEERING LTD.
CONSULTING ENGINEERS
201-120 FORT STREET, WINNIPEG, MANITOBA R3C 1C7
TEL: (204) 943-6142, FAX: (204) 942-1276, JUN: 31-219
THIS DRAWING IS THE EXCLUSIVE PROPERTY OF NOVA 3 ENGINEERING LTD. AND MAY ONLY BE REPRODUCED WITH THE WRITTEN PERMISSION OF NOVA 3 ENGINEERING LTD.
THE CONCEPT AND DESIGN INCORPORATED INTO THIS DRAWING ARE BASED ON INFORMATION PROVIDED BY THE CLIENT AND OTHER RELATED SOURCES. PROFESSIONAL ENGINEER ACCEPTS NO RESPONSIBILITY FOR DRAWING AND DESIGN UNLESS DRAWING IS ACCOMPANIED BY ORIGINAL SEALED AND SIGNED LETTER OF INTENT AND CERTIFICATE OF INSPECTION. REFER TO WWW.NOVA3.CA FOR CAUTIONARY NOTES.

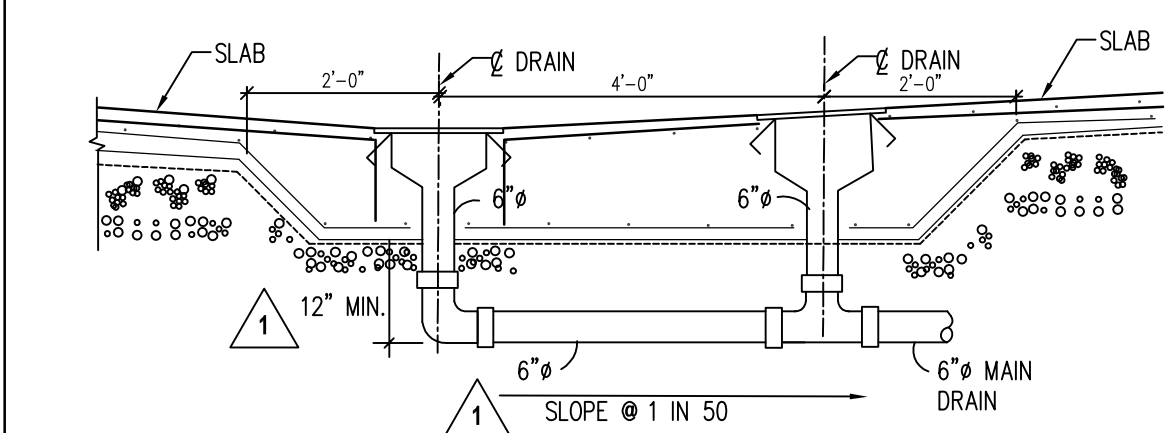

WADING POOL MAIN DRAIN SECTION
SCALE: 1/2"=1'-0"
REFER TO DRAWING A-2