



1 STORAGE ADDITION LIGHTING PLAN
 E-5 SCALE: 1/4" = 1' - 0"

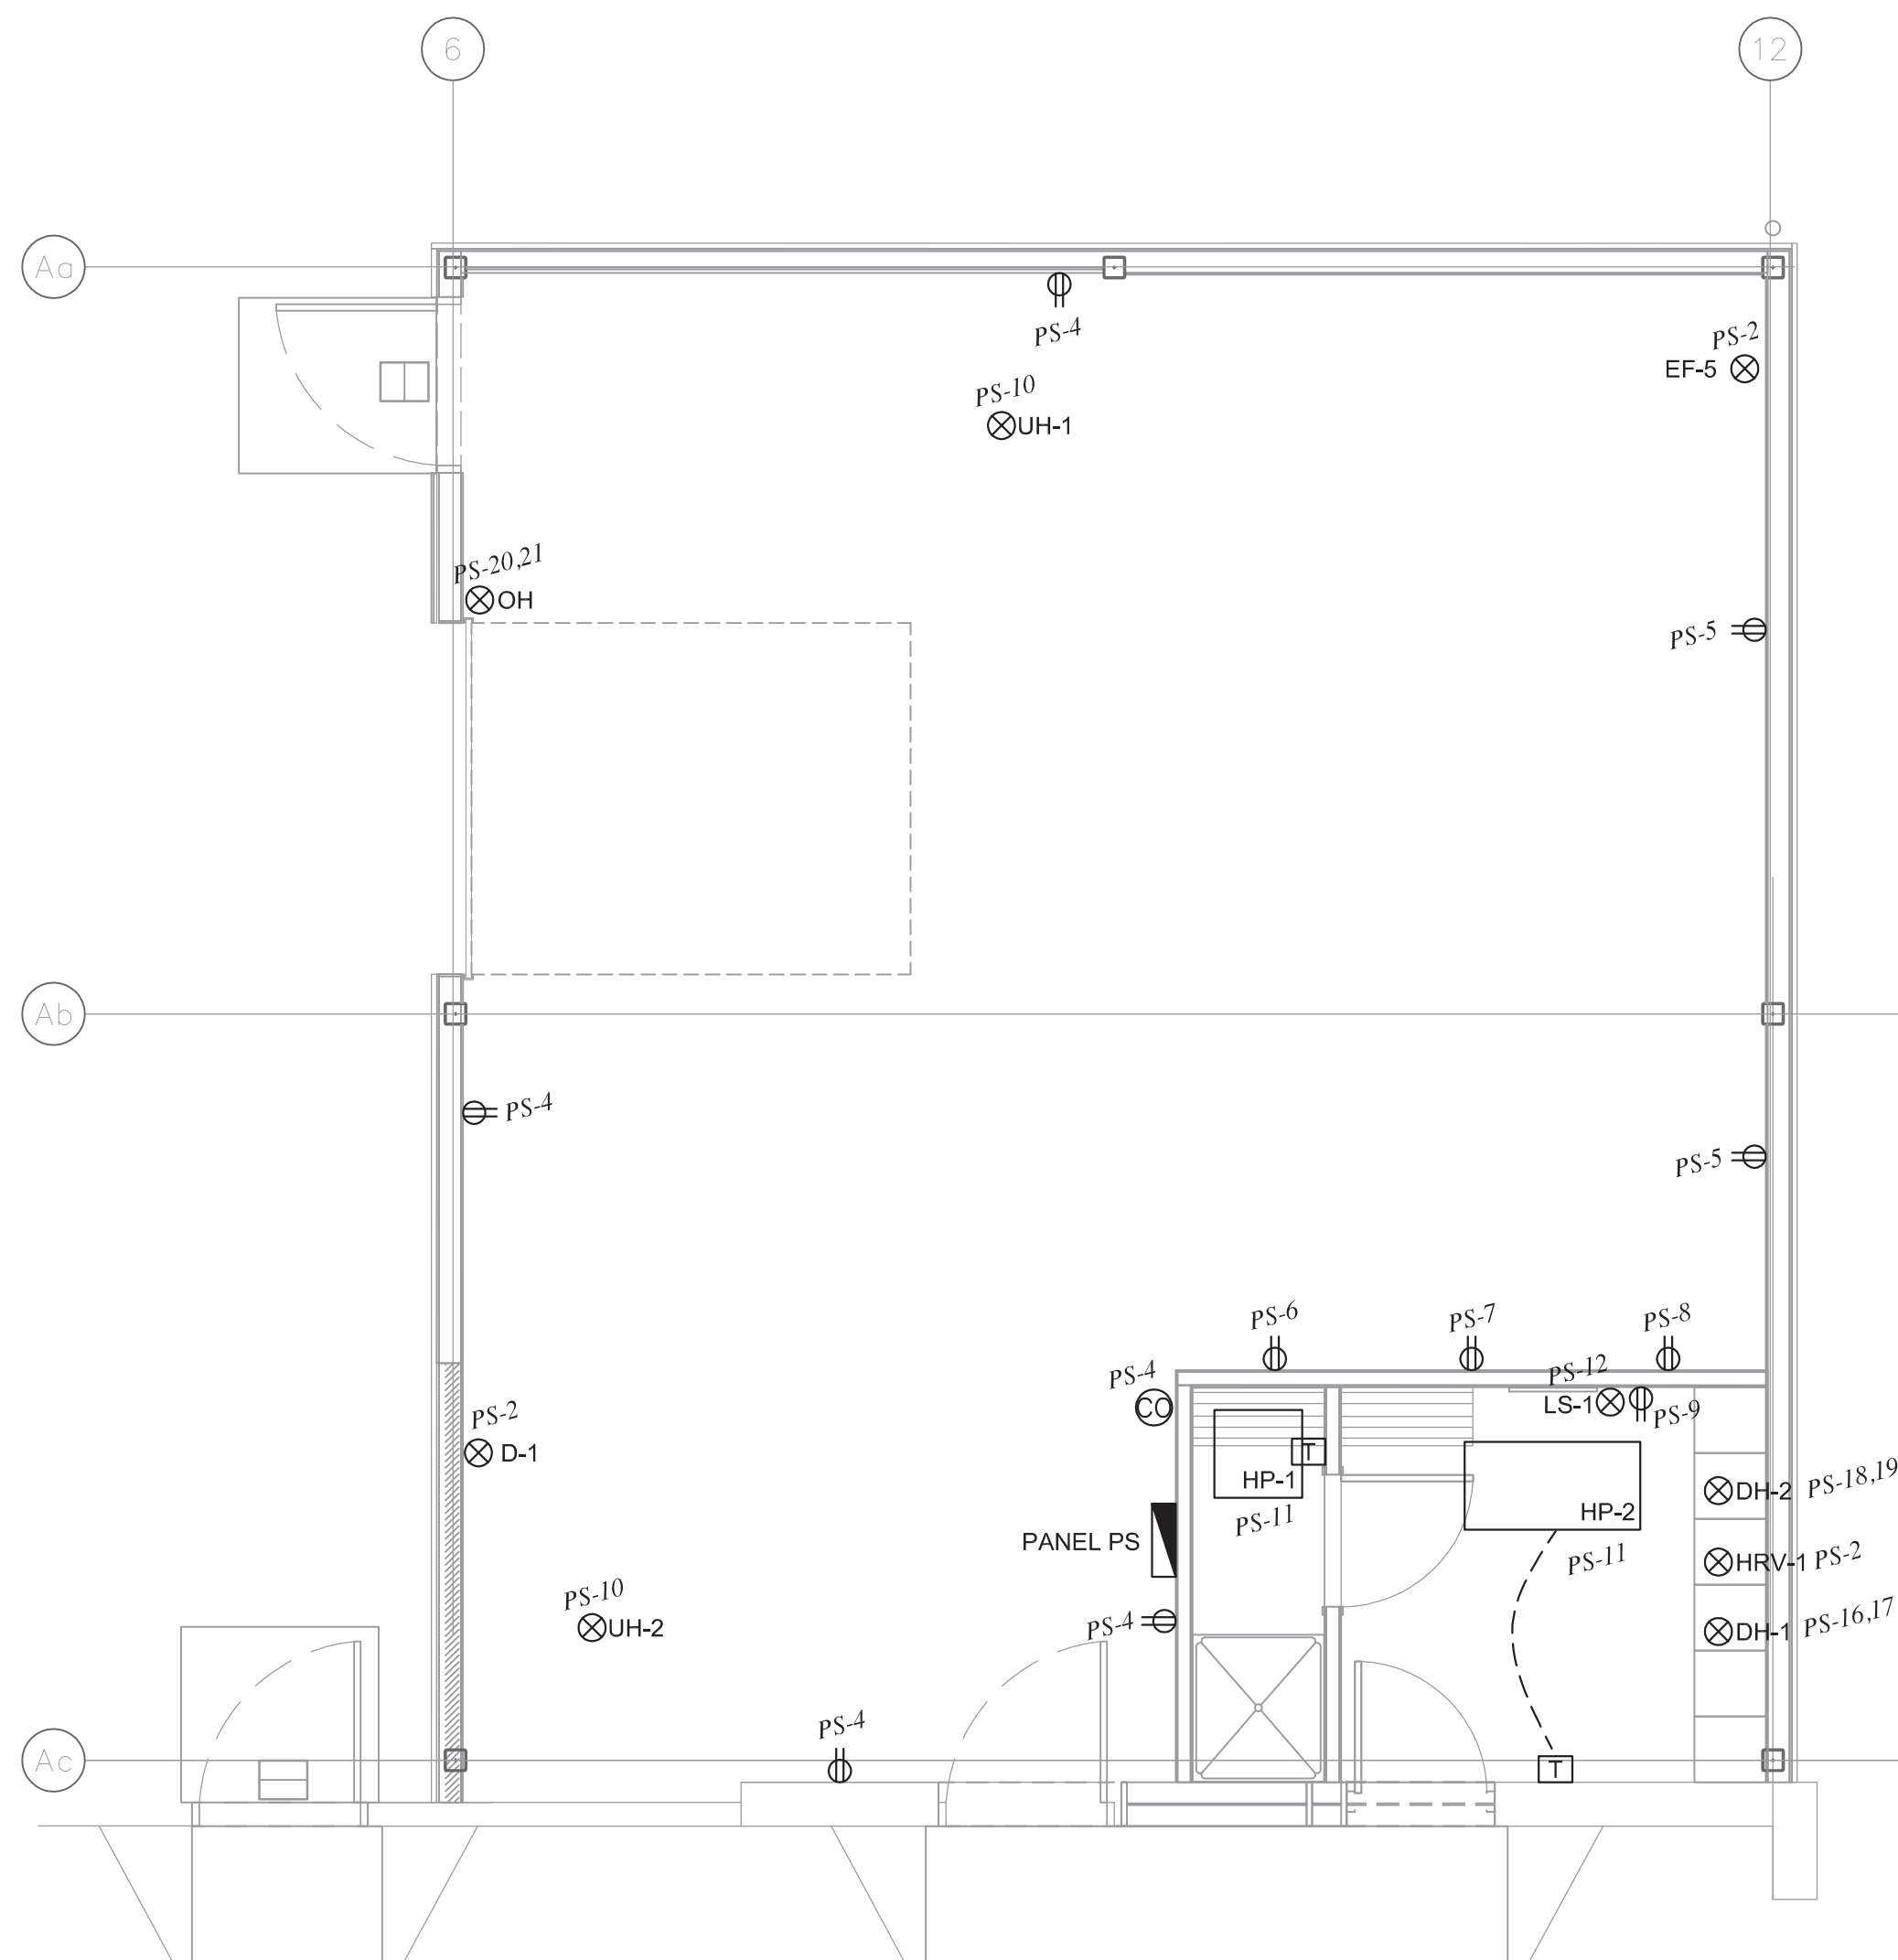

2 STORAGE ADDITION POWER PLAN
 E-5 SCALE: 1/4" = 1' - 0"

GENERAL NOTES:
 A. CONFIRM LOCATION OF ALL MECHANICAL EQUIPMENT.

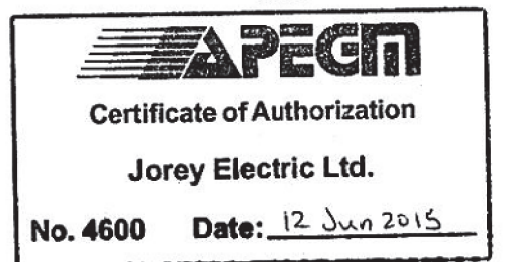

JOREYELECTRIC!

Engineering Consultants
 6-1375 Nisakwa Road E
 Winnipeg MB R2J 3T3
 p. 204-255-4842
 e. info@joreyelectric.com

NO	REVISION	DATE	BY
1	ISSUED FOR TENDER	12 JUN 2015	JJD
2	ISSUED FOR CONSTRUCTION	1 JUN 2015	JJD
NO	REVISION	DATE	BY
Project			
TRANSPORTATION MANAGEMENT CENTRE RENOVATIONS			
821 ELGIN AVE., WINNIPEG, MANITOBA			
Sheet Title			
STORAGE ADDITION LIGHTING & POWER			
Date	1 JUN 2015	Sheet No.	E-5/R-1
By	TD		
Project No.	14-131		