




NORTH ELEVATION
1:50

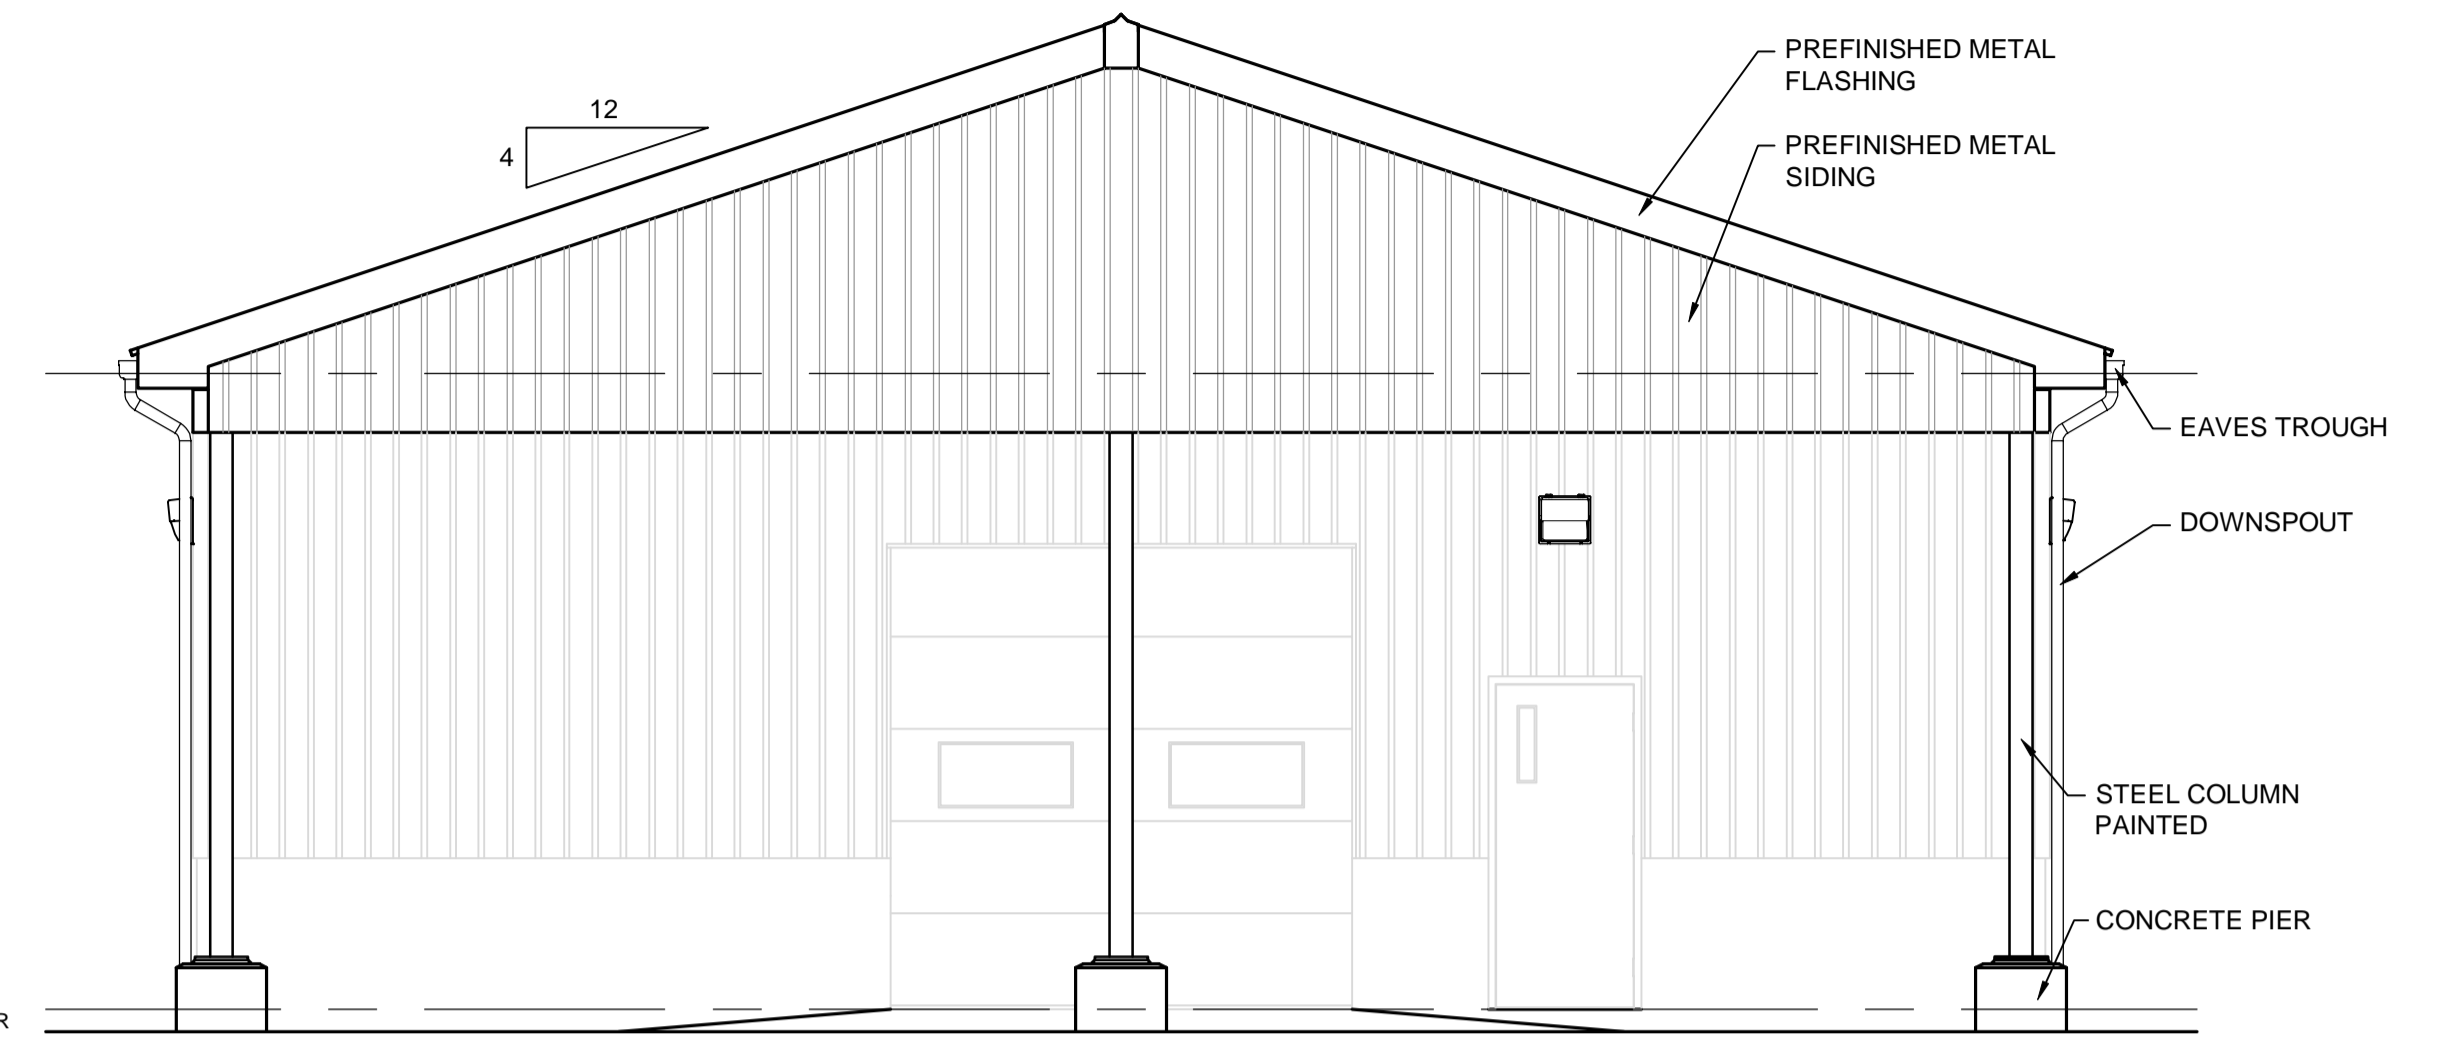

EAST ELEVATION
1:50

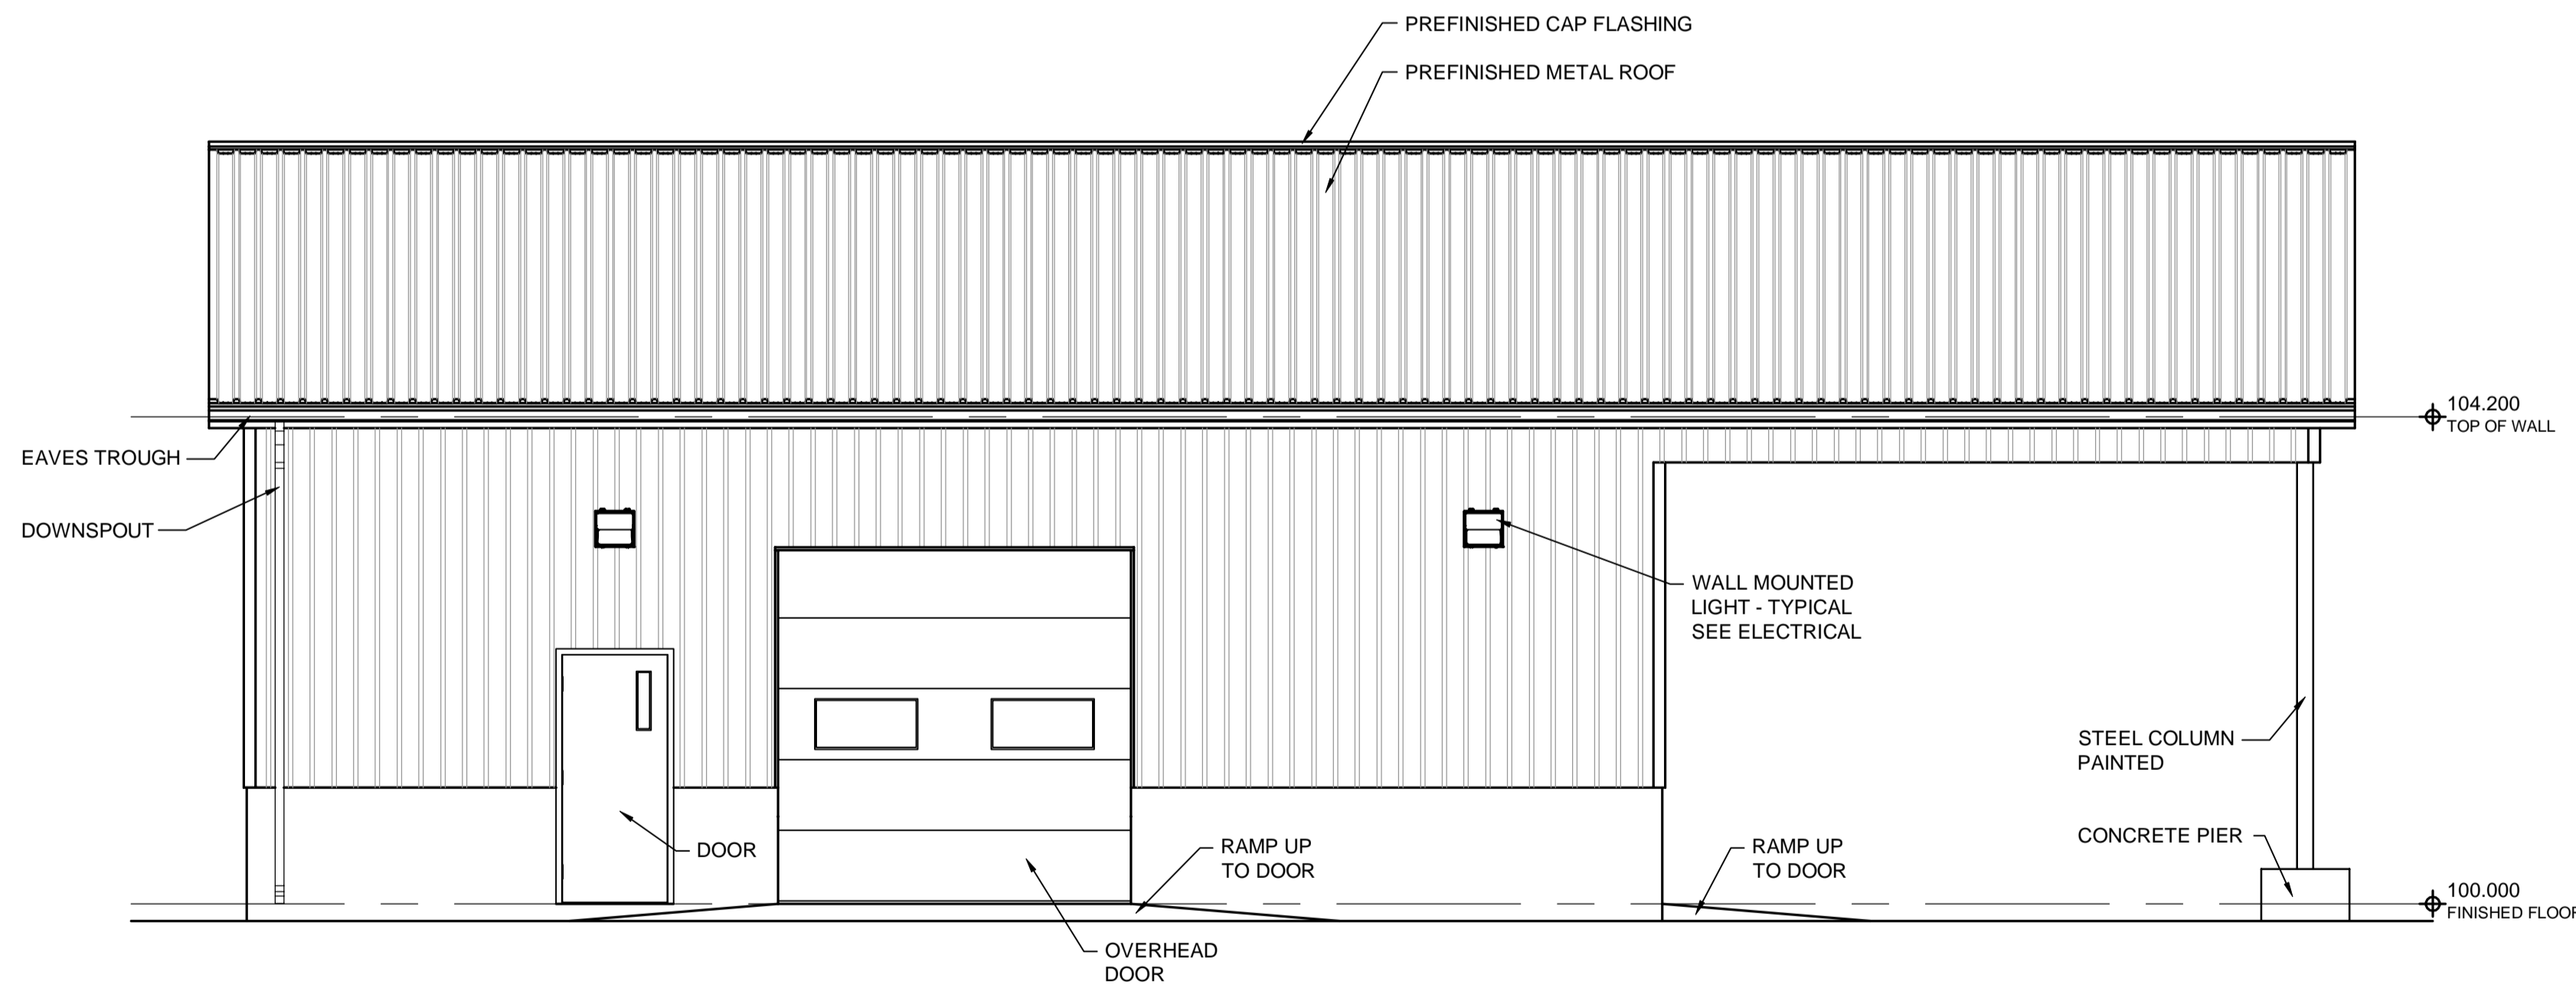

SOUTH ELEVATION
1:50

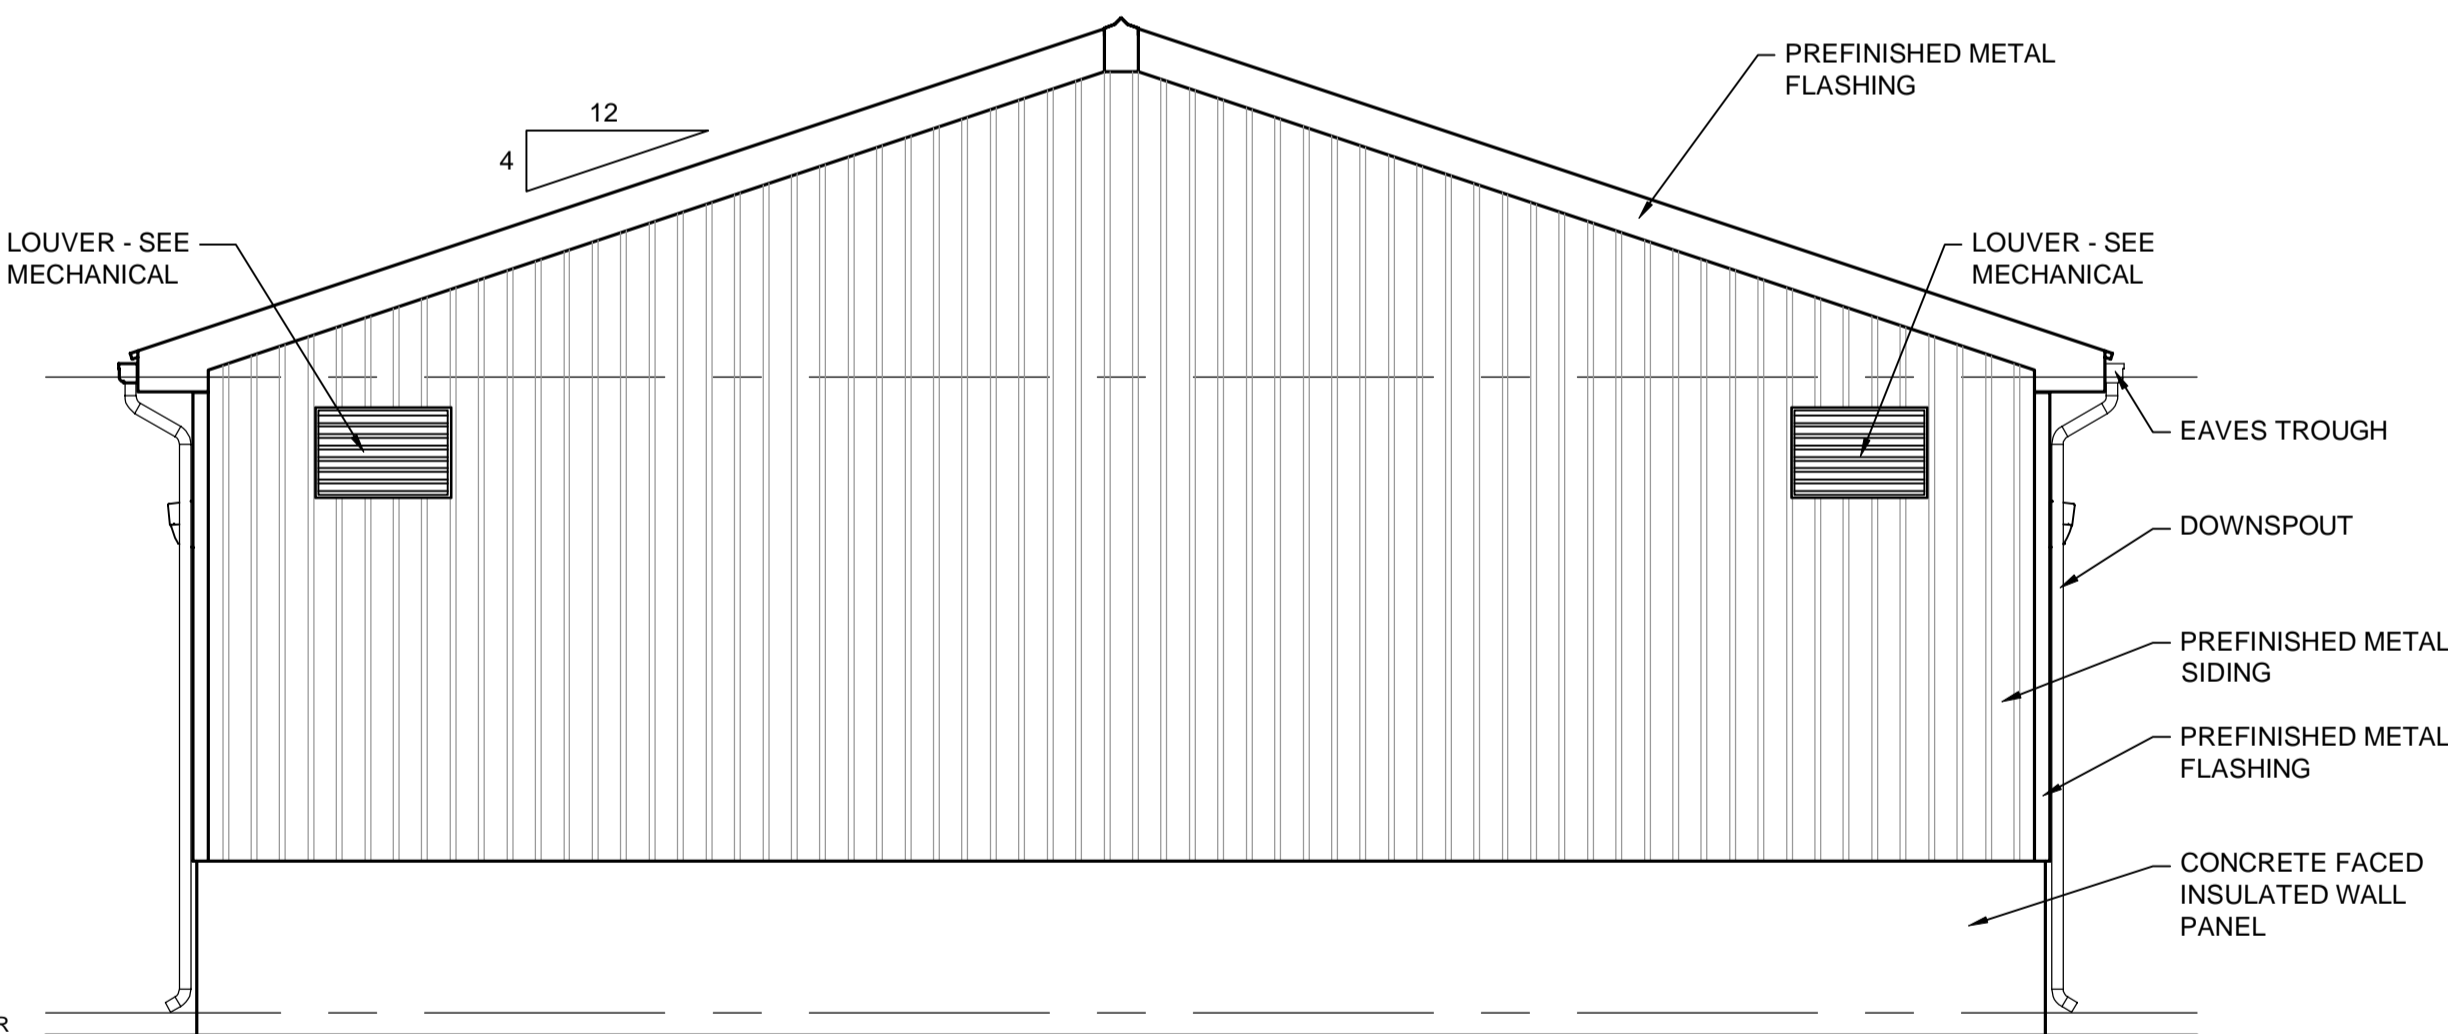

WEST ELEVATION
1:50

APEGM
Certificate of Authorization
Dillon Consulting Limited (MB)
No. 1789 Date: 2014/07/08

METRIC

WHOLE NUMBERS INDICATE MILLIMETRES
DECIMALIZED NUMBERS INDICATE METRES

B.M. ELEV.	DESIGNED BY	DATE
	LDP	
	DRAWN BY	PDR
	CHECKED BY	LDP
	APPROVED BY	ARR
	HOR. SCALE	AS NOTED
	VERTICAL	
1	ISSUED FOR ADDENDUM #1	14/07/08 ARR
NO.	REVISIONS	DATE BY DATE

DESIGNED BY	LDP
DRAWN BY	PDR
CHECKED BY	LDP
APPROVED BY	ARR
HOR. SCALE	AS NOTED
VERTICAL	
DATE	JULY 2014

DILLON CONSULTING

RELEASED FOR CONSTRUCTION

DATE

ENGINEER'S SEAL

PROVINCE OF MANITOBA
ORIGINAL STAMPED BY
E.W.G. GUEST
2014/07/08
REGISTERED PROFESSIONAL ENGINEER

CONSULTANT PROJECT NUMBER
13-8224

THE CITY OF WINNIPEG
WATER AND WASTE DEPARTMENT

4R WINNIPEG DEPOT
BRADY ROAD RESOURCE
MANAGEMENT FACILITY

HHW EWASTE BUILDING
ELEVATIONS

CITY DRAWING NUMBER
1-0400A-A0007-001

SHEET 5 OF 11

CONSULTANT DRAWING NUMBER
A7 (AD-1)