




PLAN
SCALE: 1 : 20

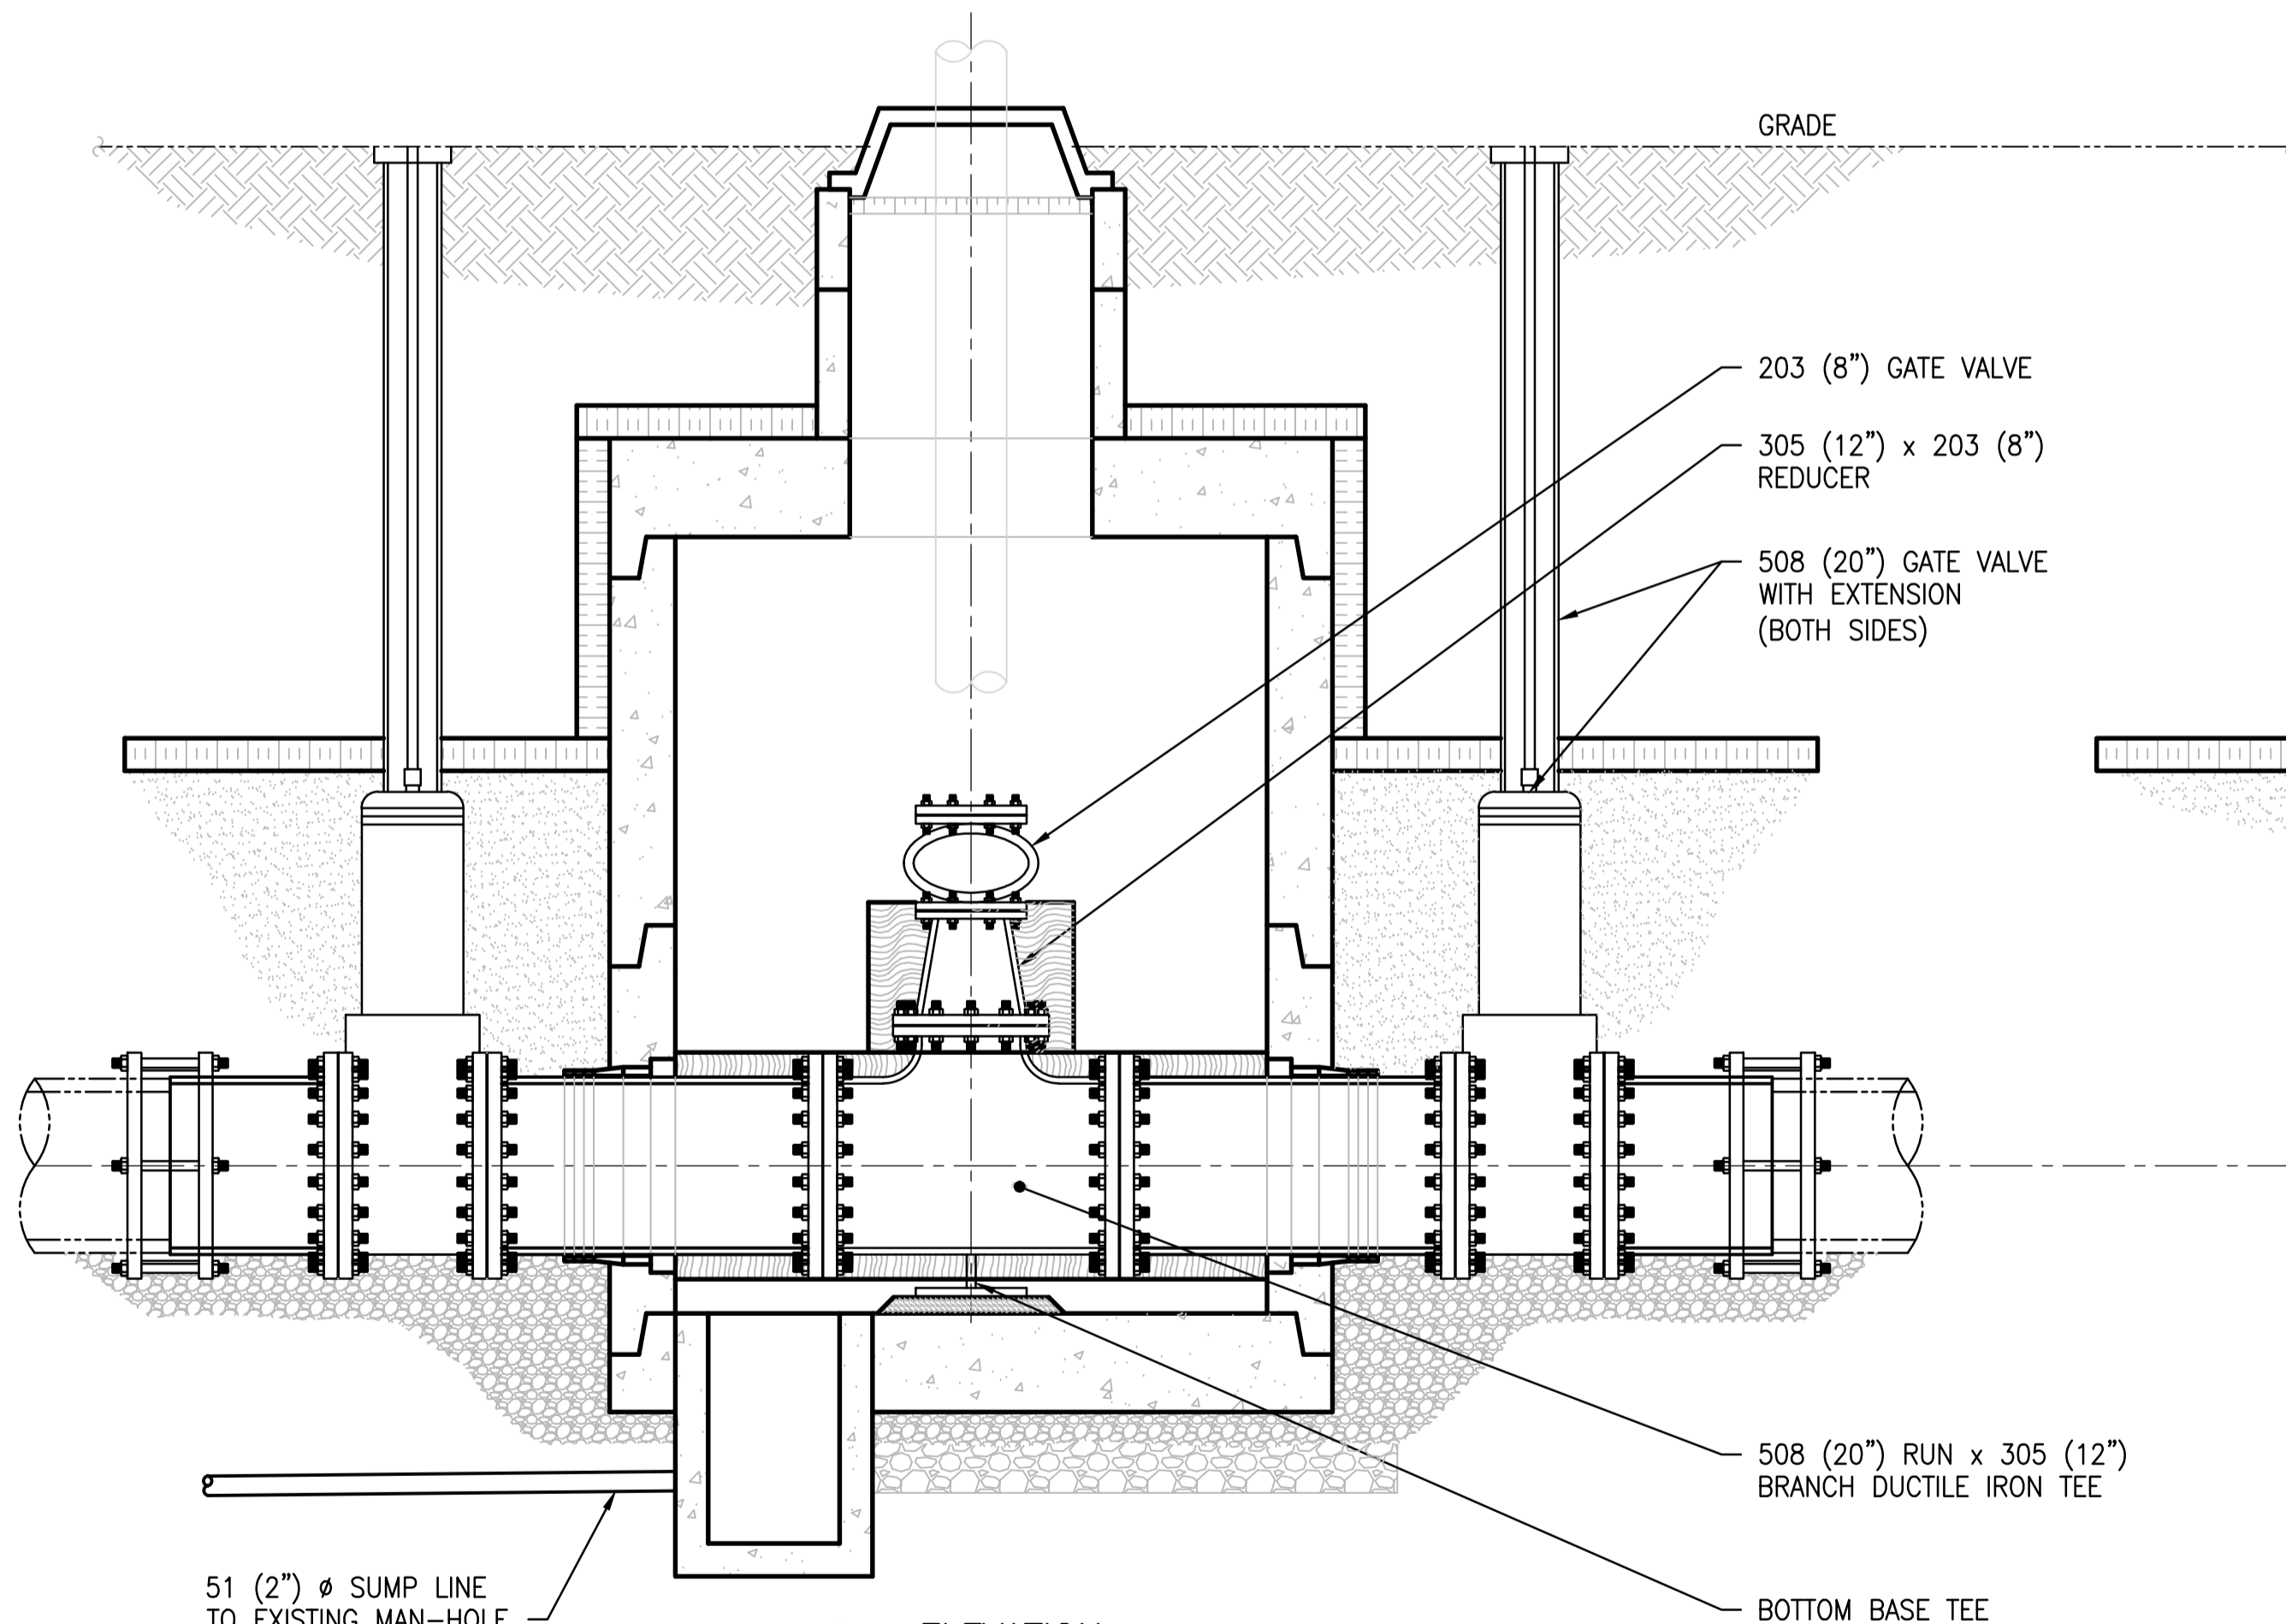

A ELEVATION
SCALE: 1 : 20

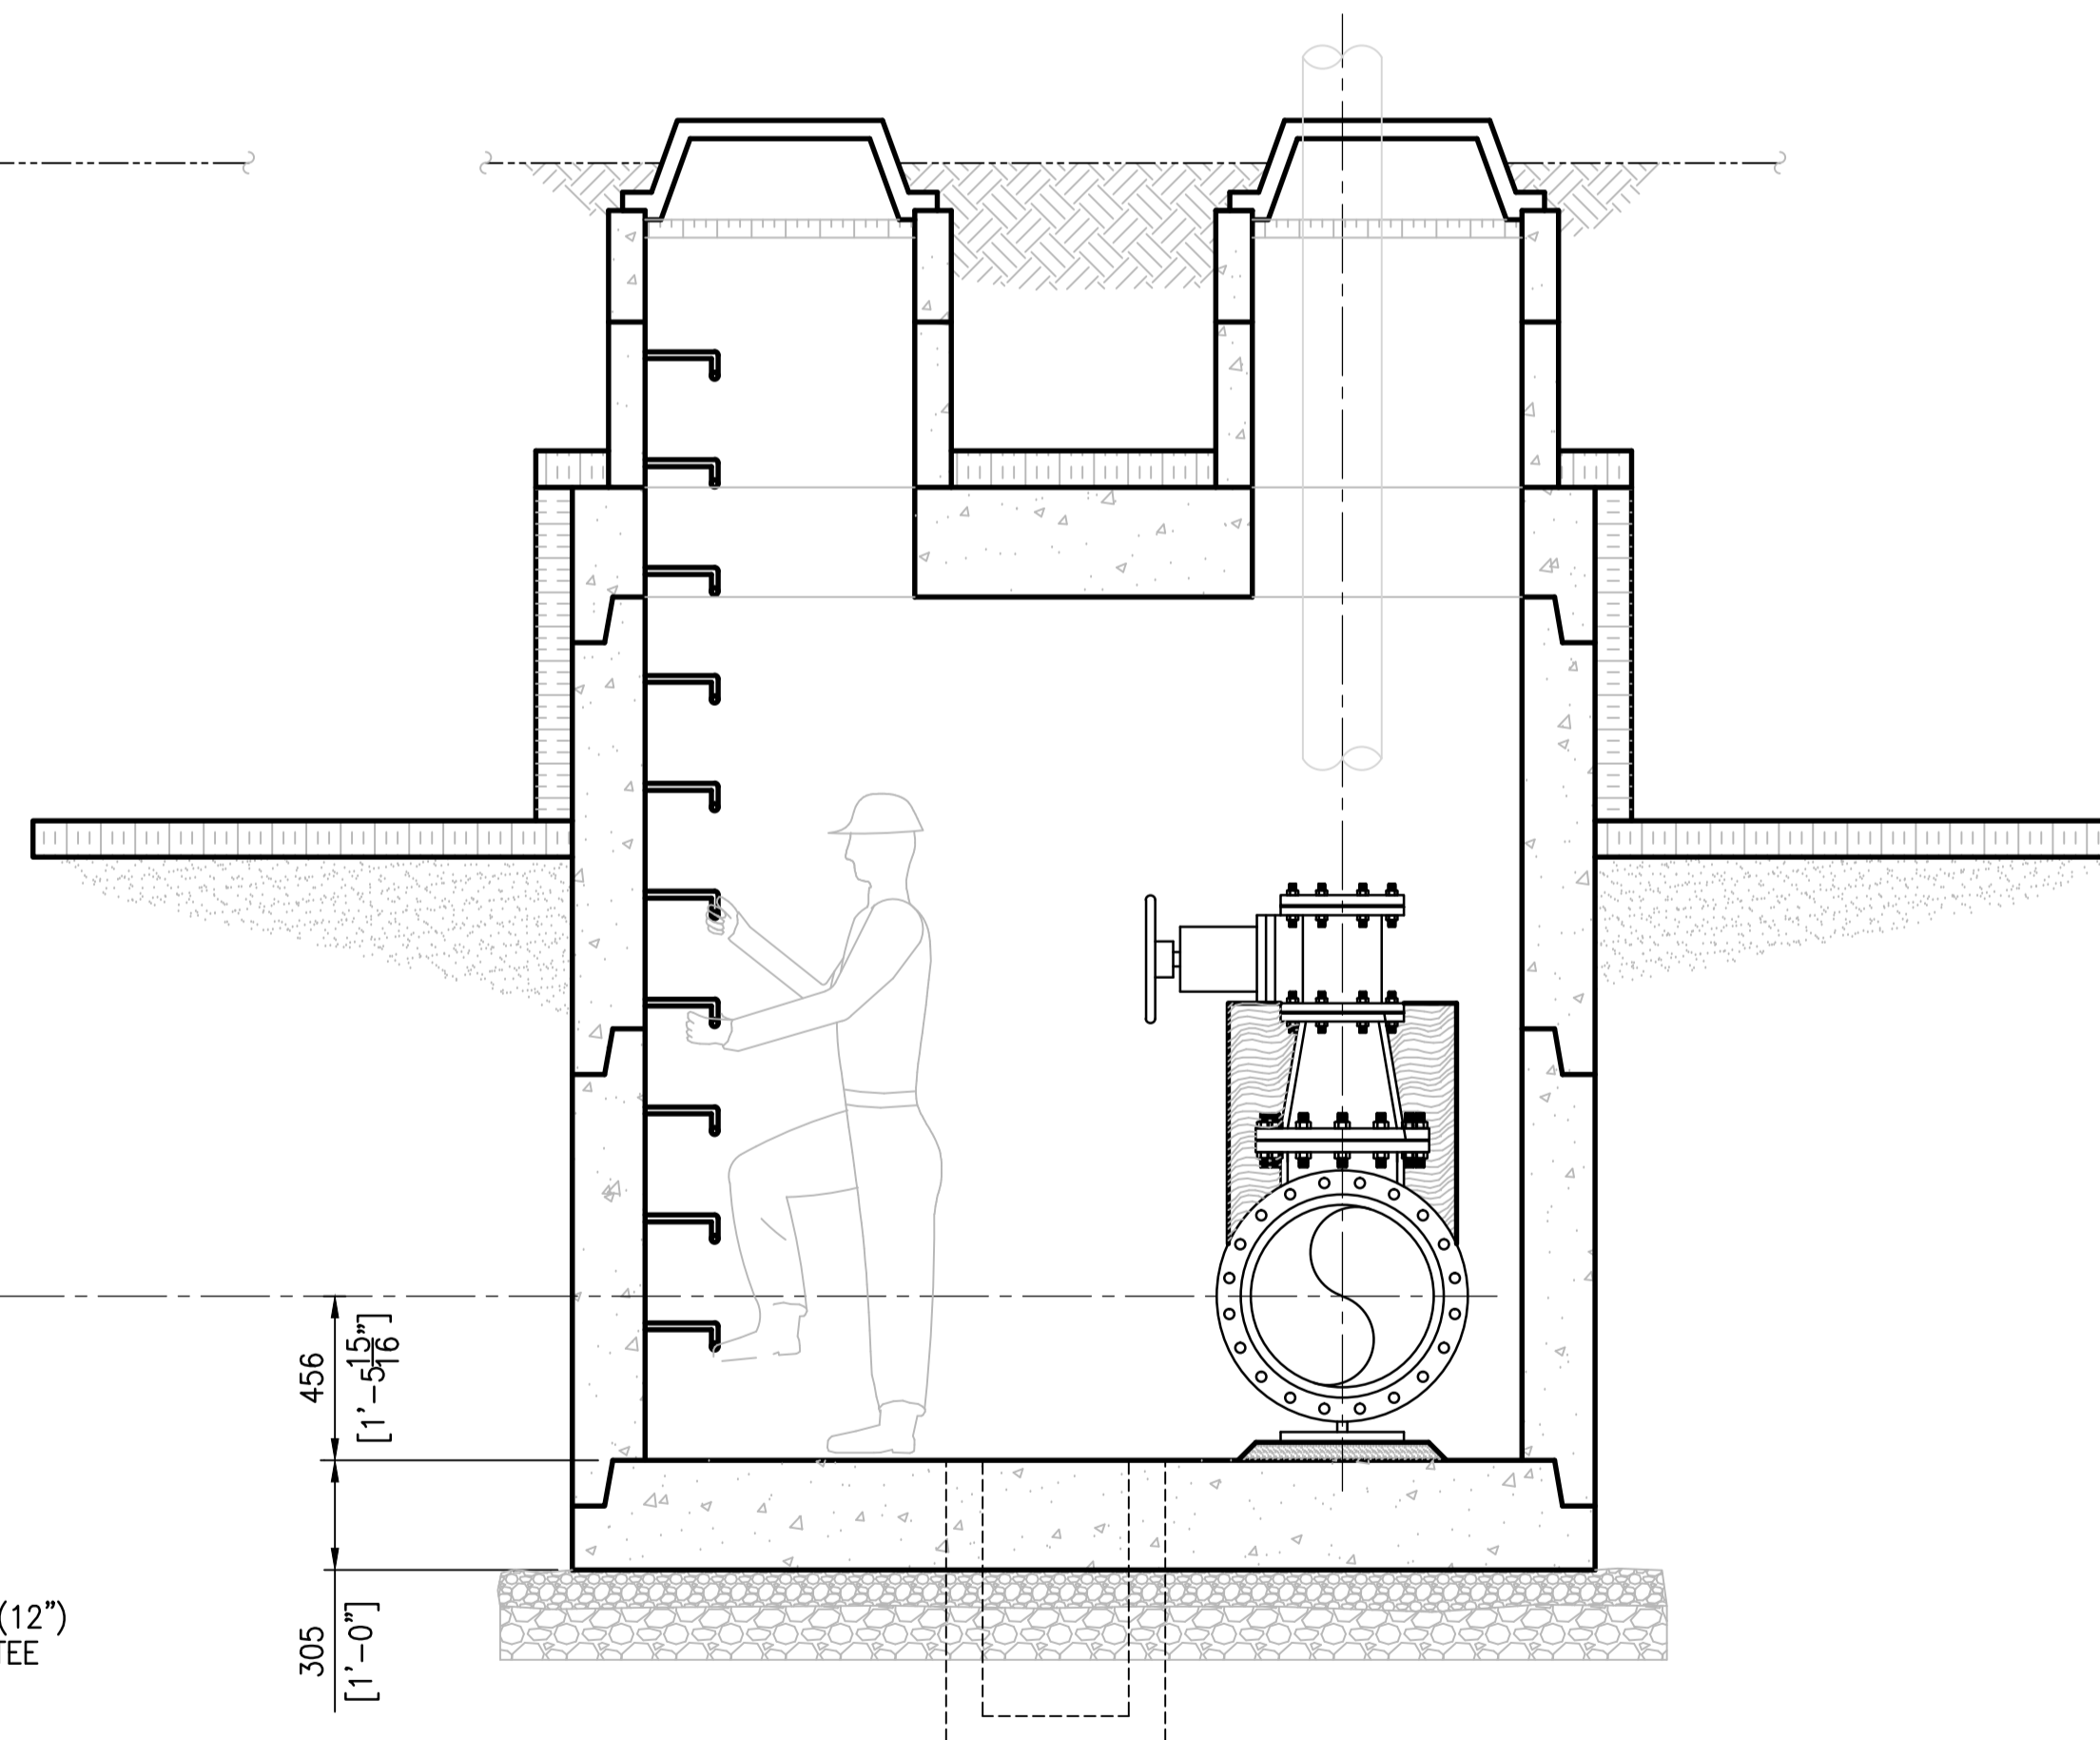

B ELEVATION
SCALE: 1 : 20

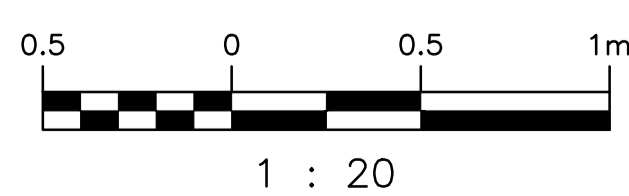

S-265	AINSLIE COMM. & PUMPING STATION - SITE PLAN
403-B	AINSLIE COMM. & PUMPING STATION - SUPERSTRUCTURE & DETAILS
403-A	AINSLIE COMM. & PUMPING STATION - REINFORCING DETAILS
403	AINSLIE COMM. & PUMPING STATION
DRAWING NUMBER	REFERENCE DRAWINGS

00	ISSUED FOR ADDENDUM - MANHOLE DETAILS	2015/09/28	IP
NO.	REVISIONS	DATE	DESIGN/CHECK

		SNC-LAVALIN INC. 148 Nature Park Way Winnipeg, MB, Canada R3P 0X7 204-786-8080	
DESIGNED BY:	I. PARKINSON	CHECKED BY:	J. ALO
DRAWN BY:	B. DICKSON	APPROVED BY:	
SCALE:	1:20	ISSUED FOR CONSTRUCTION	BY:
DATE:	2015/09/28	DATE:	
CONSULTANT NO.:			

ENGINEER'S SEAL
PRELIMINARY
NOT TO BE
USED FOR
CONSTRUCTION

THE CITY OF WINNIPEG WATER AND WASTE DEPARTMENT	
OLIVE WASTEWATER LIFT STATION 2015 UPGRADES PLAN AND ELEVATION MANHOLE STRUCTURE	
CITY DRAWING NUMBER	SHEET REV. SIZE
1-0169L-M0005	001 00 A1