


A1 SIZE - 594mm x 841mm

©CH2M HILL 2015. ALL RIGHTS RESERVED.

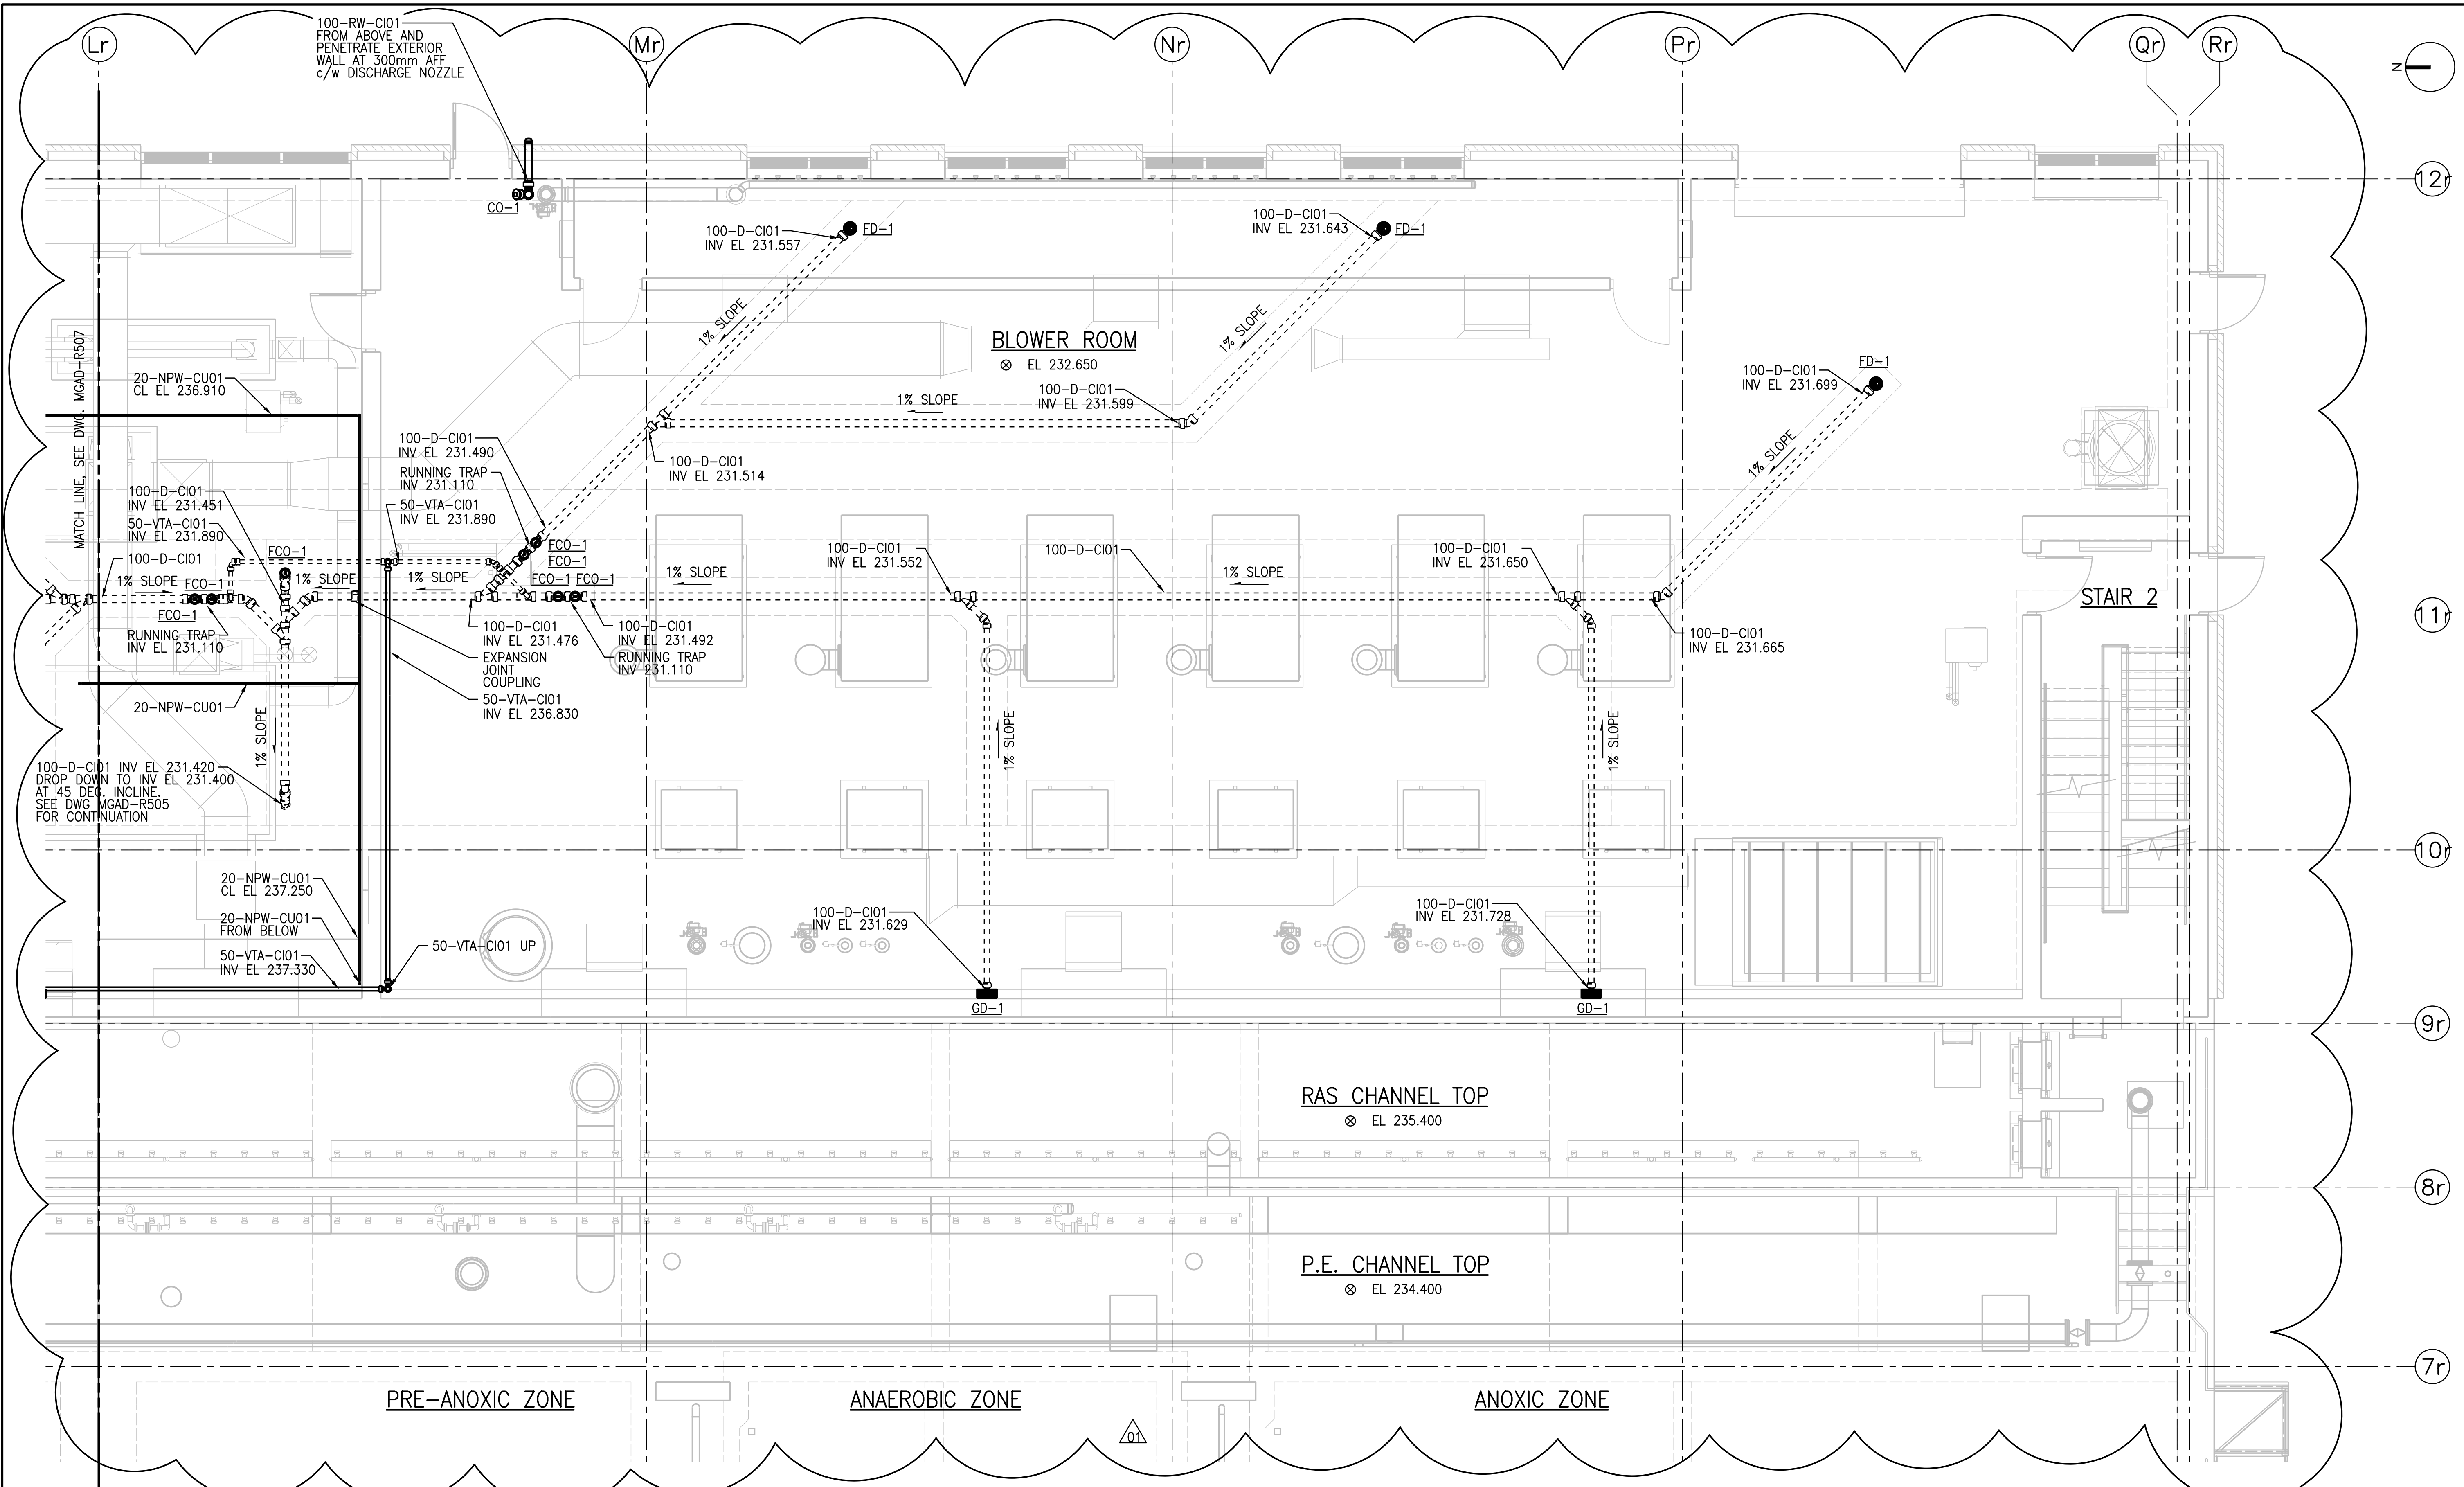

100-RW-CI01 FROM ABOVE AND PENETRATE EXTERIOR WALL AT 300mm AFF c/w DISCHARGE NOZZLE

BLOWER ROOM
⊗ EL 232.650

RAS CHANNEL TOP
⊗ EL 235.400

P.E. CHANNEL TOP
⊗ EL 234.400

 
PRE-ANOXIC ZONE

ANAEROBIC ZONE

ANOXIC ZONE

GROUND FLOOR PLAN - PART B

1:50



APEGM
Certificate of Authorization
CH2M HILL Canada Ltd.
No. 1441

NO.	REVISIONS	DATE	DESIGN	CHECK
01	ISSUED FOR ADD. 2 - B.O.899-2015	02/2016	P.K.	J.C.
00	ISSUED FOR TENDER - B.O. 899-2015	01/2016	P.K.	J.C.

CH2MHILL
SNC-LAVALIN

DESIGNED BY: T. TRAN	CHECKED BY: D. LE
DRAWN BY: P. KWONG	APPROVED BY: H.T. FREIHAMMER
SCALE: 1:50	ISSUED FOR CONSTRUCTION BY: T. TURZAK
DATE: 2016/01/29	DATE: 2016/01/29
CONSULTANT NO.: 474248	


ENGINEER'S SEAL
26/02/2016
PROVINCE OF MANITOBA
REGISTERED PROFESSIONAL ENGINEER
D.H. LE
Member
31604

THE CITY OF WINNIPEG
Winnipeg WATER AND WASTE DEPARTMENT

SOUTH END WATER POLLUTION CONTROL CENTRE
SEWPPC UPGRADING/EXPANSION PROJECT
MECHANICAL
BIOREACTOR/BLOWER BUILDING
PLUMBING - GROUND FLOOR PLAN - PART B

CITY DRAWING NUMBER
1-0102-MGAD-R508

SHEET 001	REV. 01	SIZE A1
--------------	------------	------------

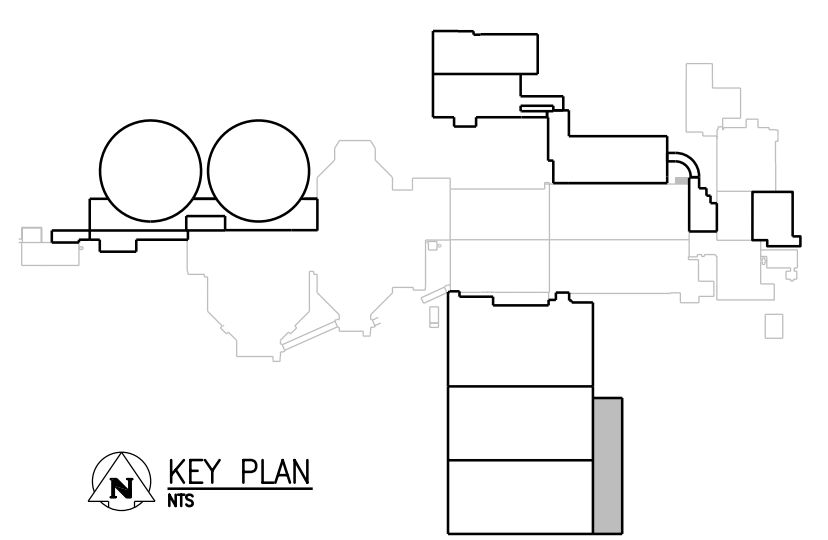

PLOT DATE: 2/25/2016

FILE NAME: 1-0102-MGAD-R508.dgn