


MATCH LINE, SEE DWG. MGAD-US01


ROOF PLAN
1:100

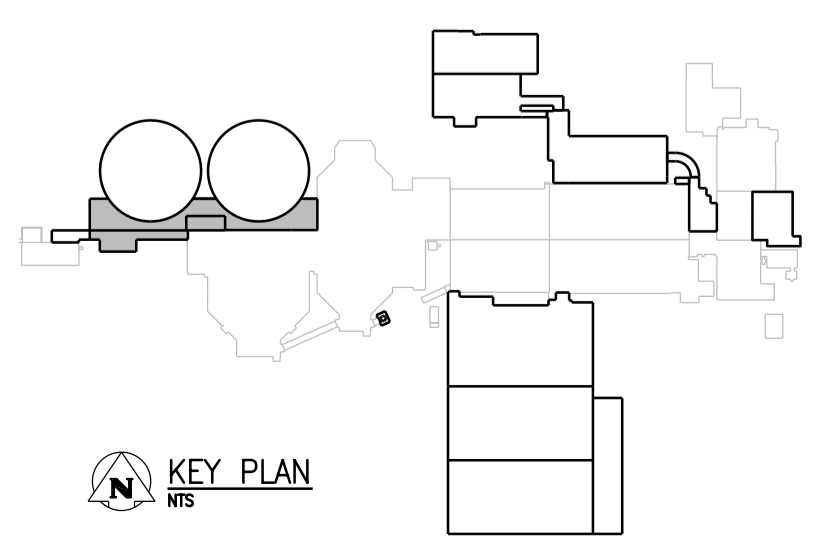

APEGM
Certificate of Authorization
CH2M HILL Canada Ltd.
No. 1441

NO.	REVISIONS	DATE	DESIGN	CHECK
01	ISSUED FOR ADD. 2 - B.O. 899-2015	02/2016	A.B.	T.T.
00	ISSUED FOR TENDER - B.O. 899-2015	01/2016	P.K.	T.T.

CH2MHILL	
DESIGNED BY: T. TRAN	CHECKED BY: D. LE
DRAWN BY: P. KWONG	APPROVED BY: H.T. FREIHAMMER
SCALE: 1:100	ISSUED FOR CONSTRUCTION BY: T. TURZAK
DATE: 2016/01/29	DATE: 2016/01/29
CONSULTANT NO.: 474248	

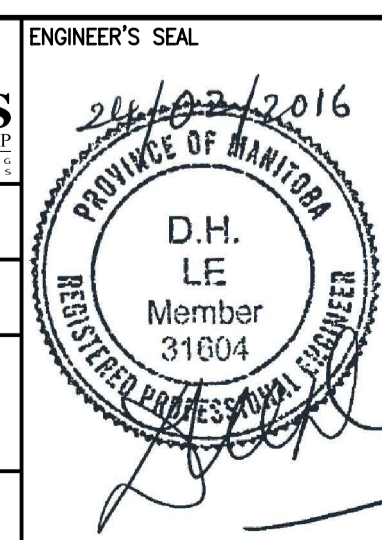

THE CITY OF WINNIPEG
Winnipeg WATER AND WASTE DEPARTMENT

SOUTH END WATER POLLUTION CONTROL CENTRE
SEWPCC UPGRADING/EXPANSION PROJECT
PLUMBING
SECONDARY CLARIFIERS 4 AND 5
PLUMBING - ROOF PLAN

CITY DRAWING NUMBER: 1-0102-MGAD-S507 | SHEET: 001 | REV.: 01 | SIZE: A1