

NOTES :

CONSTRUCTION STANDARDS

TO BE CONSTRUCTED IN ACCORDANCE WITH MANITOBA HYDRO DISTRIBUTION AND SUBTRANSMISSION STANDARDS. LATEST REVISION. NO MAJOR CHANGE SHALL BE MADE WITHOUT APPROVAL OF THE DESIGN ENGINEER OR DELEGATE.

CITY OF WINNIPEG REQUIREMENTS:

WATER AND WASTE DEPARTMENT APPROVAL SUBJECT TO THE FOLLOWING NOTES:

- A MINIMUM CLEARANCE OF 1000 MILLIMETERS SHALL BE PROVIDED BETWEEN THE UNDERSIDE OF ANY EXISTING WATERMAIN OR SEWERMAIN PIPE AND THE TOP OF THE PROPOSED WORKS.
- OR
- A MINIMUM CLEARANCE OF 500 MILLIMETERS SHALL BE PROVIDED BETWEEN THE UNDERSIDE OF THE PROPOSED WORKS AND THE TOP OF ANY EXISTING WATERMAIN OR SEWERMAIN PIPE.
- A MINIMUM LATERAL CLEARANCE OF 1.0 METER SHALL BE PROVIDED BETWEEN THE NEAREST EDGE OF THE PROPOSED WORKS AND THE NEAREST EDGE OF ANY EXISTING WATERMAIN, WATERMAIN VALVE, HYDRANT, SEWERMAIN OR SEWER MANHOLE.



A MINIMUM CLEARANCE OF 3.0 METERS SHALL BE PROVIDED

REEL NUMBER	MANUFACTURER	MANUFACTURE DATE

AUTHORITY	NOTED	NOT REQUIRED	OBTAINED
DISTRICT	X		?
S.C.C.		X	
EASEMENTS		X	
GAS		X	
M.T.S.		X	
SHAW		X	
RAILWAY		X	
DEPT OF HIGHWAYS		X	
CITY OF WINNIPEG	X		?

CONTACT	NAME	PHONE
DESIGN	NICK WIELER	284-8100 ext.1232
DISTRICT ENG TECH	JILL SITAR	360-5718
ENERGY SERVICES ADVISOR	DARRYL STOCKI	360-7715
LOG CONSTRUCTION	BILL AMMETER	981-8356
OIL CONSTRUCTION	WAYNE IRELAND	771-5212
CUSTOMER CONTRACT	BOB FOUGERE	360-7159
CONNECTIONS	ALVARO SILVA	360-6214
TEMP. STRINGING	TERRY TABAK	360-7521


LINE COLOR	MEANING
MAGENTA	PROPOSED TRENCH
RED	PROPOSED OBJECT
PINK	OBJECT TO BE ABANDONED
GREEN	OBJECT TO BE SALVAGED
BLACK	EXISTING OBJECT
L=	ANNOTATION 1 - #4 AL CN STREET LIGHTING CABLE
LL=	ANNOTATION 1 - 1/0 TRIPLEX STREET LIGHTING CABLE

INSTALLED			
Quantity	Fixture Type	Wattage	Pole Type
9	LED	40	EXCLUSIVE

REMOVED			
Quantity	Fixture Type	Wattage	Pole Type
6	HPS	70	EXCLUSIVE
3	LED	40	EXCLUSIVE

LED CONVERSION CHART		
HPS WATTAGE	EQUIVALENT LED WATTAGE	CATALOG NUMBER
100	73	ERS10C3E1540
150	95	ERS10C3E1740
250	138	ERS20H3E1540
400	209	ERS30H3E1540

**COW TENDER
2019-R-04**

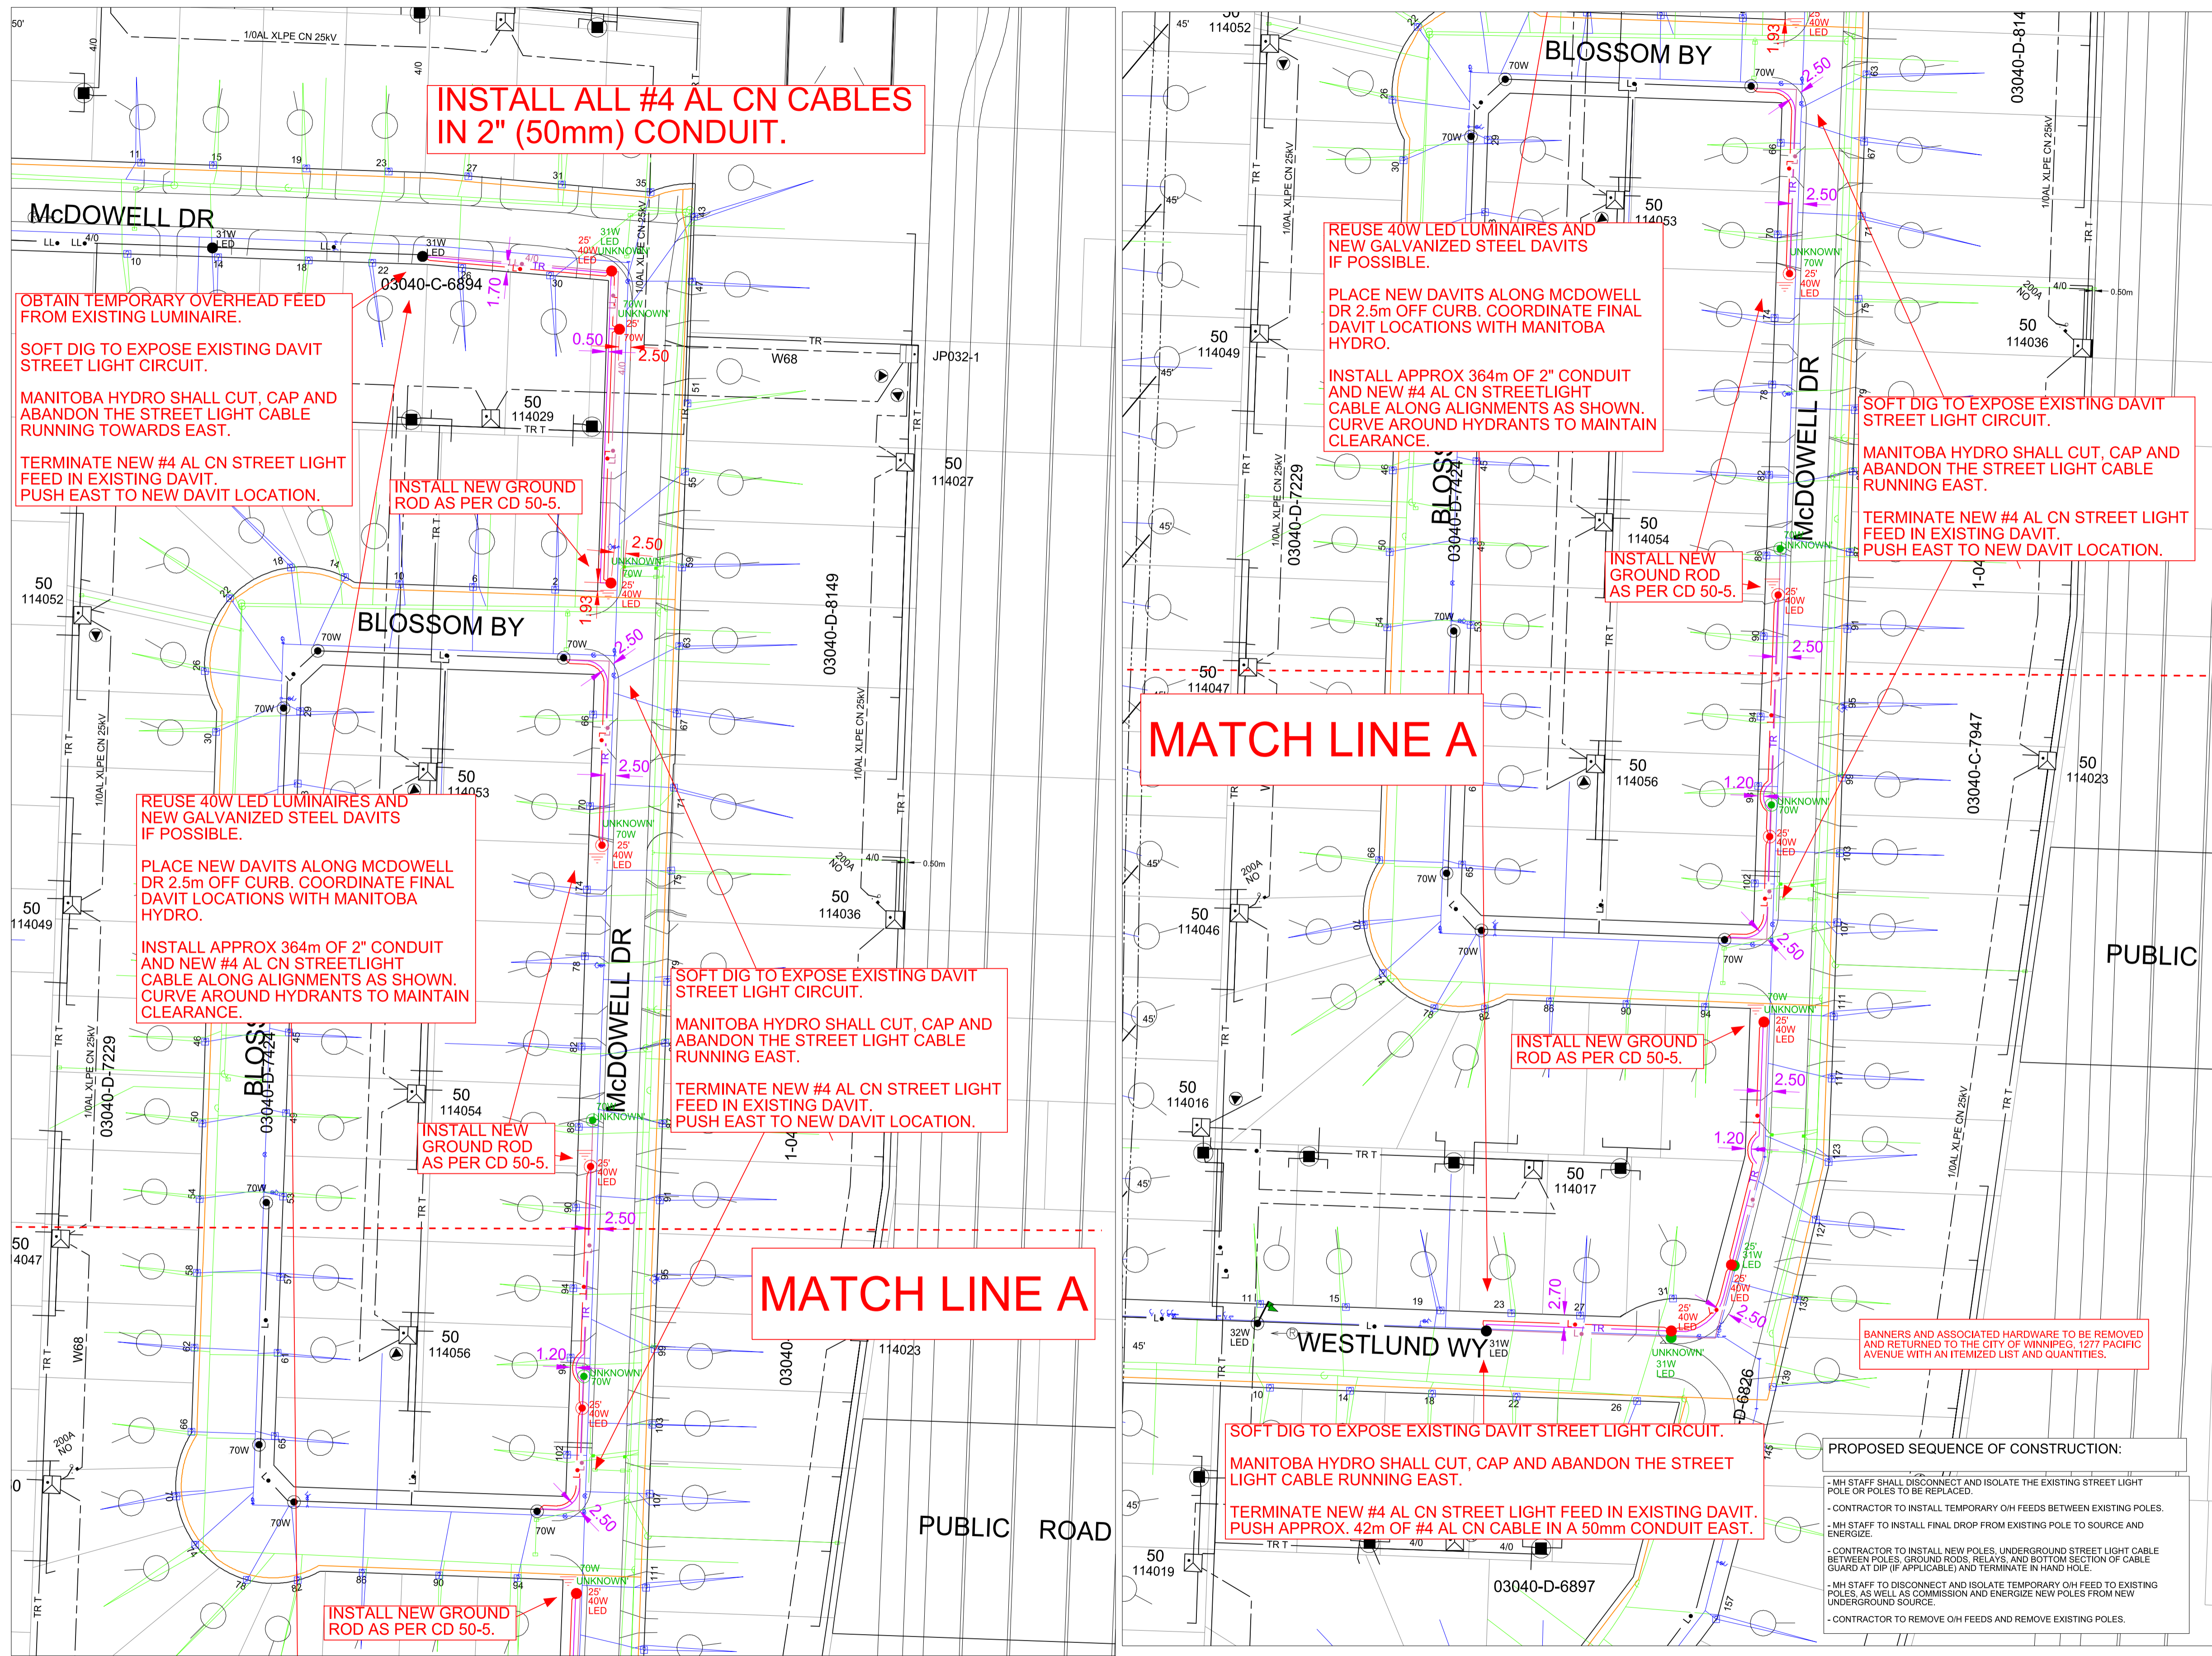


CONTACT "CLICK BEFORE YOU DIG MANITOBA" AT
ClickBeforeYouDigMB.com
THREE FULL WORKING DAYS
PRIOR TO CONSTRUCTION FOR LOCATION OF EXISTING WATER, WASTEWATER, LAND DRAINAGE UTILITIES AND MANITOBA HYDRO UTILITIES

NOTE: INDICATION OF ALL UNDERGROUND UTILITIES IS FOR ILLUSTRATIVE PURPOSES ONLY. CONTACT THE APPLICABLE UTILITIES FOR SPECIFIC PLANT LOCATIONS AND CLEARANCES.

PRELIMINARY NOT TO BE USED FOR CONSTRUCTION

INFORMATION PERTAINING TO THE SIZE AND LOCATION OF MANITOBA HYDRO FACILITIES AND INSTALLATIONS IS ILLUSTRATIVE AND SHOULD NOT BE RELIED ON FOR THE PURPOSES OF ANY ACTIVITY BEING CONDUCTED AT OR NEAR THE IDENTIFIED HYDRO INSTALLATIONS. ALL LOCATIONS AND EQUIPMENT MUST BE VERIFIED BY APPROPRIATE HYDRO DISTRICT OFFICES PRIOR TO ANY PHYSICAL ACTIVITY UNDERTAKEN AT OR NEAR HYDRO INSTALLATIONS. A CURRENT WORK CLEARANCE REQUEST FORM CAN BE OBTAINED FROM THE DISTRICT OFFICE AND MUST BE ON SITE PRIOR TO THE COMMENCEMENT OF ANY EXCAVATIONS.

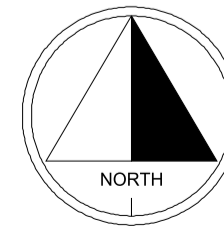

NO.	DATE	REVISION	BY	KCD.	APP.

DRAWING NUMBER	REFERENCE DRAWINGS	DRAWN
?	C.O.W. APPROVED DRAWING	NTW

CHECK	SCALE	DATE
	1:750	2019 03 11

AREA NUMBER	MANITOBA HYDRO DISTRIBUTION PLANNING & DESIGN
4901	WO# P:31742 NETWORK # 4305736
STATION NUMBER	DISTRICT: FORT GARRY
1085	2019 STREET LIGHT RENEWAL PROJECTS
FEEDEE NUMBER	MCDOWELL DR FROM MCDOWELL DR TO WESTLAND WY
W68	CONTRACTOR TO REPLACE EXISTING UNDERGROUND STREET LIGHTING PLANT
SYSTEM VOLTAGE	13.8/24KV