


A SECTION - LOOKING WEST
 REF. 1 SCALE: 1:50

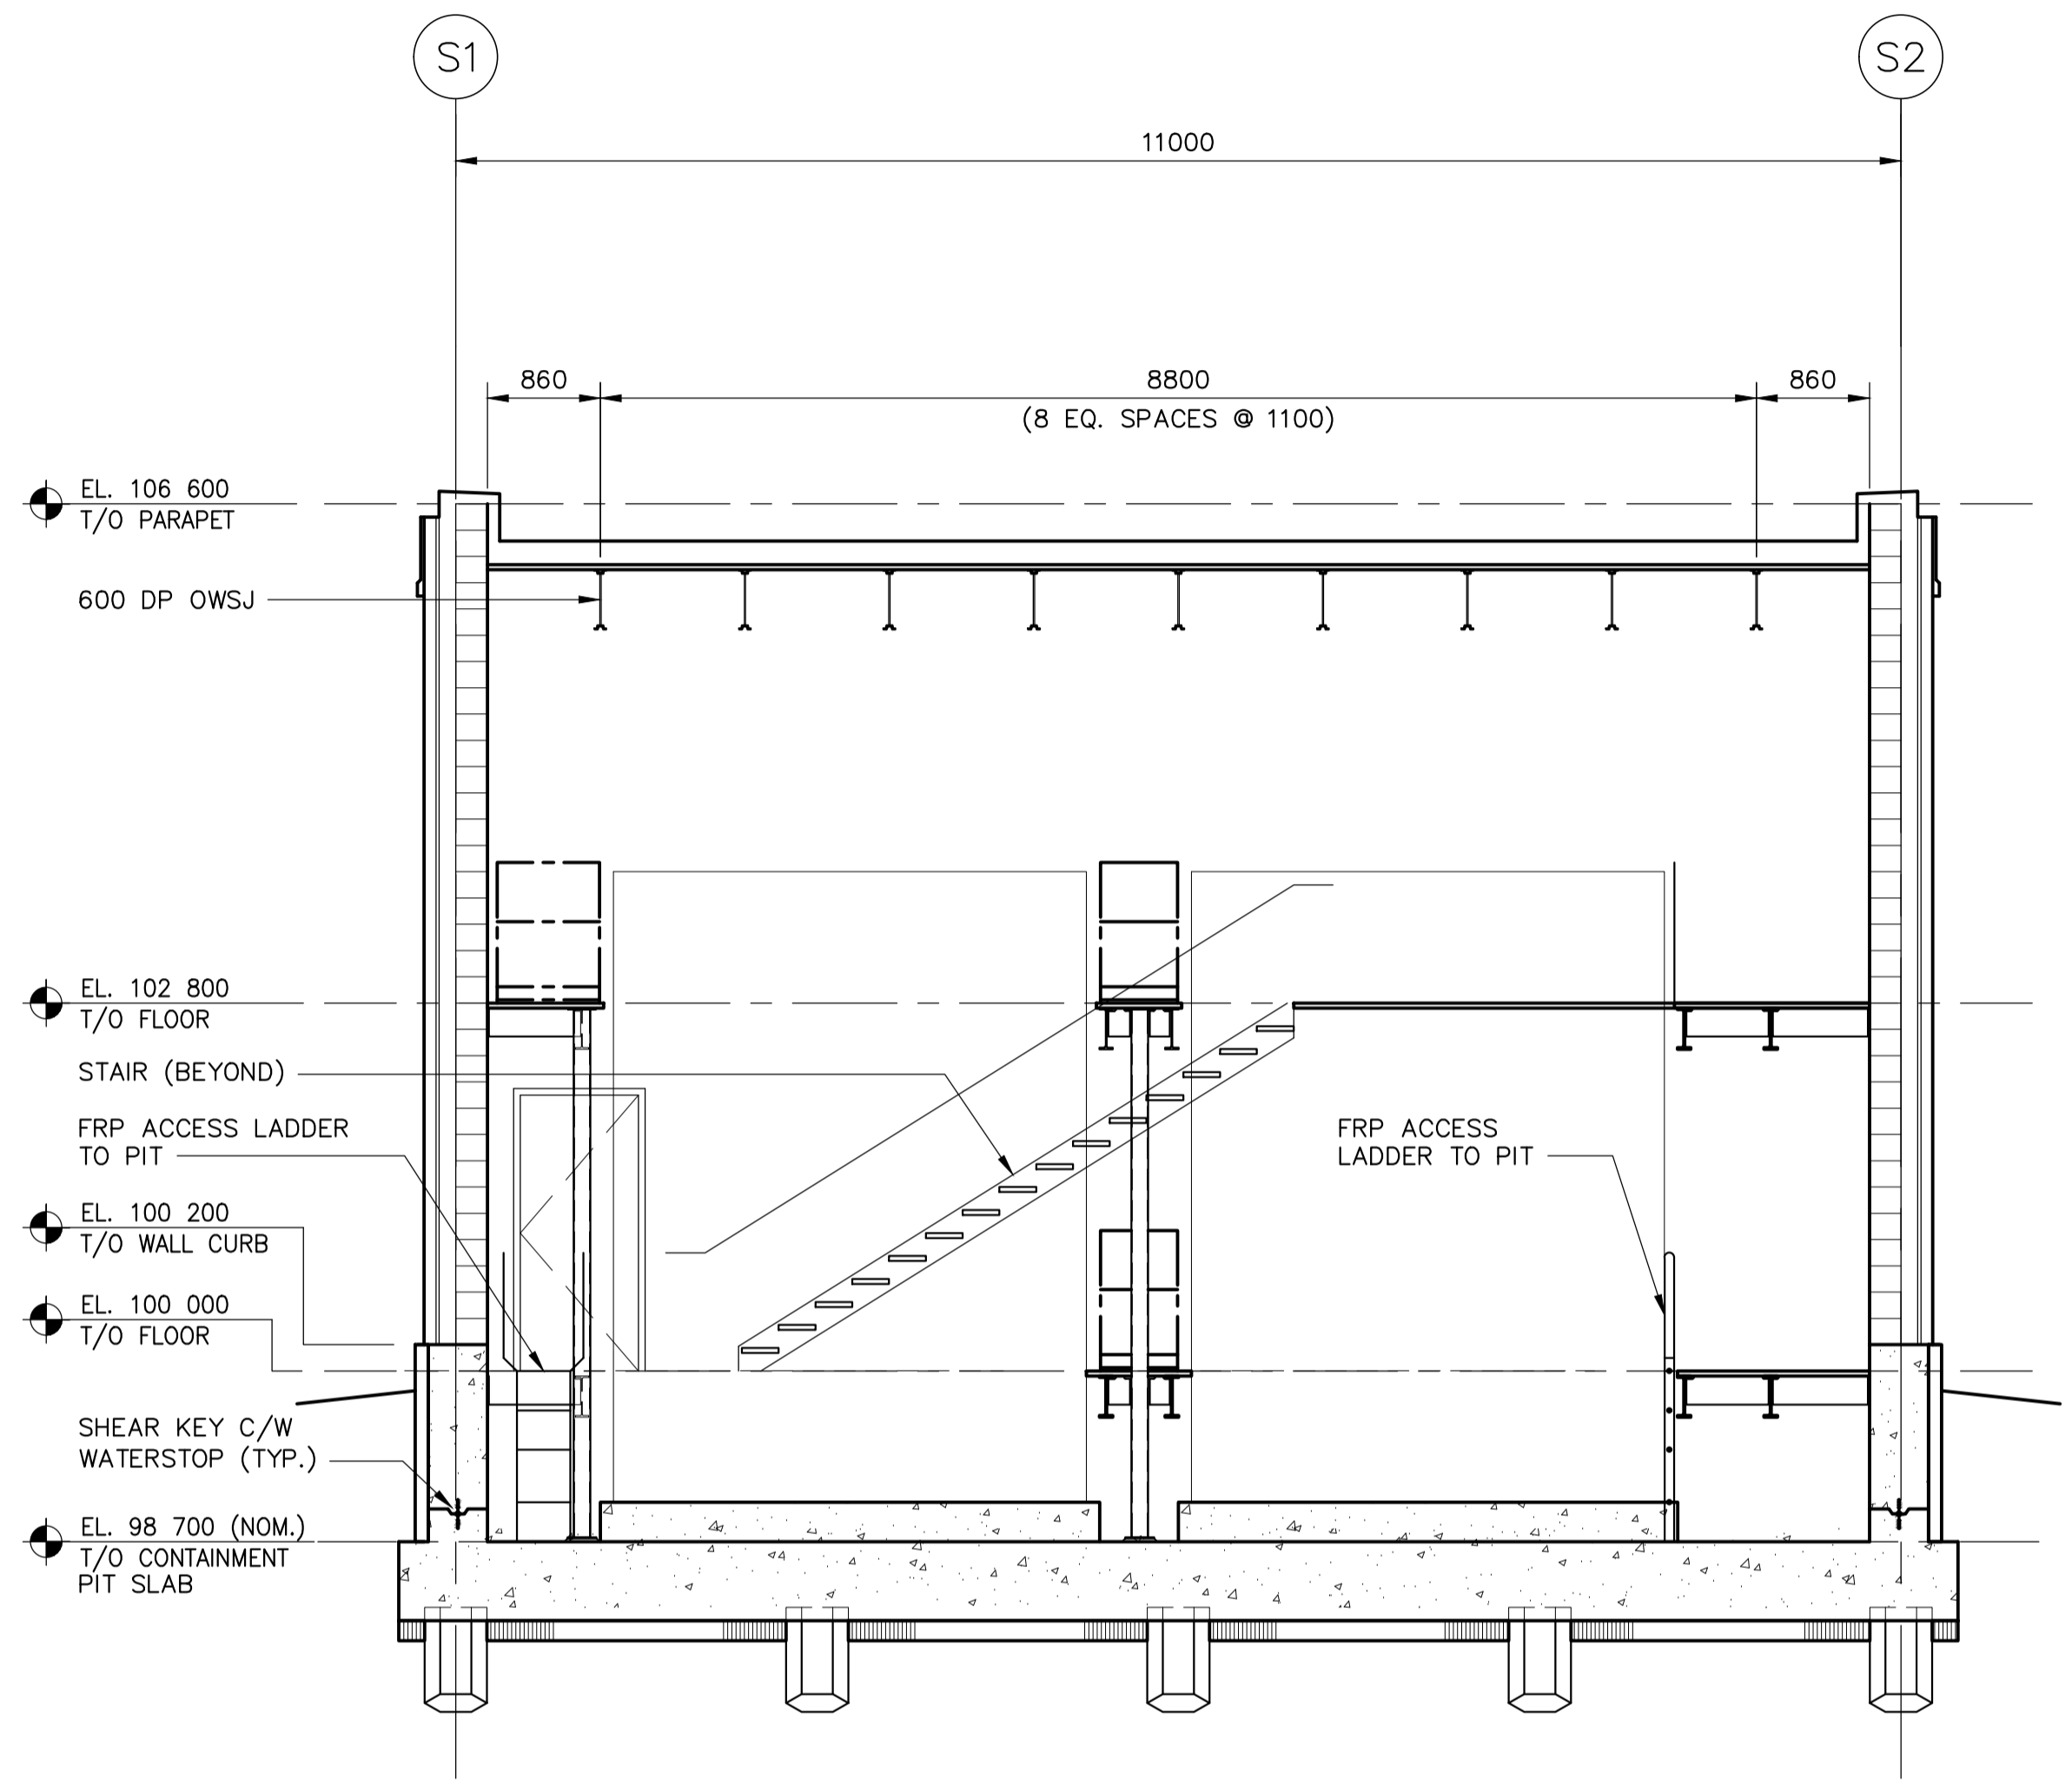

B SECTION - LOOKING NORTH
 REF. 1 SCALE: 1:50

10		
9		
8		
7		
6		
5		
4		
3		
2	1-0101-SDTL-F202-001	SECTIONS & DETAILS
1	1-0101-SSST-F202-001	MAIN FLOOR & PLATFORM FRAMING PLAN
NO.	DRAWING NUMBER	REFERENCE DRAWING TITLE
REFERENCE DRAWINGS		

EG ENGINEERS
 GEOSCIENTISTS
 MANITOBA
 Certificate of Authorization
 KGS Group
 No. 245

S.M. ELEV.			
CONSTRUCTION COMPLETION DATE: YYYY MM DD			
1	RE-ISSUED FOR CONSTRUCTION	2022 06 17	JMV
0	ISSUED FOR CONSTRUCTION	2022 05 18	JMW
NO.	REVISIONS	DATE	BY

KGS GROUP

DESIGNED BY	J. WALTER	CHECKED BY	<i>CMS</i>
DRAWN BY	F. VALENCIA	APPROVED BY	<i>JMV</i>
SCALE:	AS SHOWN	RELEASED FOR CONSTRUCTION	

DATE: 2022 02 24
 PLOT DATE: 2022 06 17

ENGINEER'S SEAL	
CONSULTANT DRAWING NUMBER	
21-0107-015_S4.201	

Winnipeg THE CITY OF WINNIPEG
 WATER AND WASTE DEPARTMENT
 ENGINEERING DIVISION
 NORTH END SEWAGE TREATMENT PLANT (NEWPPC)
 INTERIM PHOSPHOROUS REMOVAL
 AREA F - CHEMICAL RECEIVING AND STORAGE FACILITY
 SECTIONS
 BUILDING 102

CITY DRAWING NUMBER: 1-0101-SGAD-F205-001
 SHEET 1 OF 1

BID OPPORTUNITY: 197-2022
 CONTRACT NUMBER: 1-0101-SGAD-F205-001.dwg
 FILE PATH: U:\FMS\21-0107-015\