

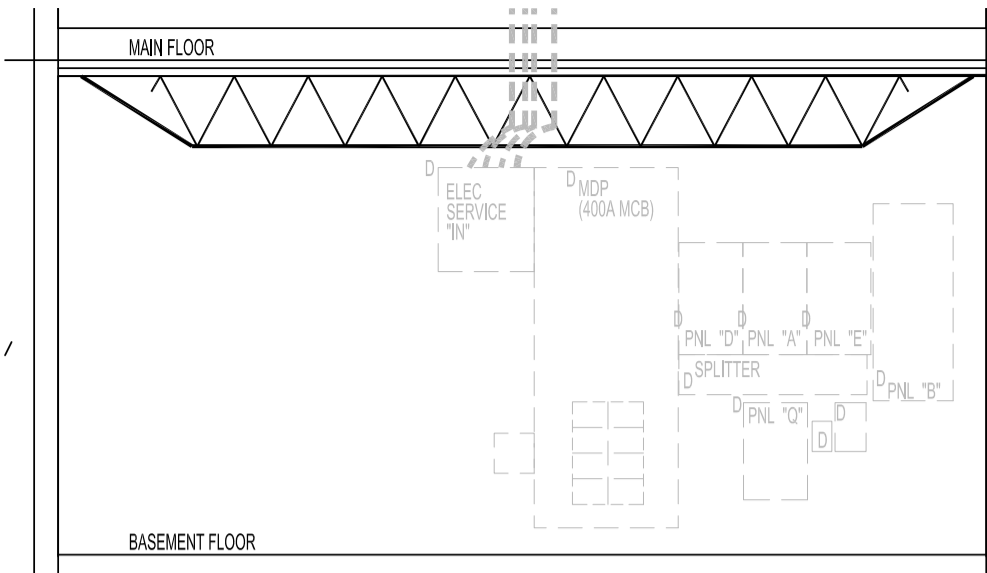


GENERAL NOTES:
1. REFER TO DRAWING E1.0 & SPECIFICATIONS.

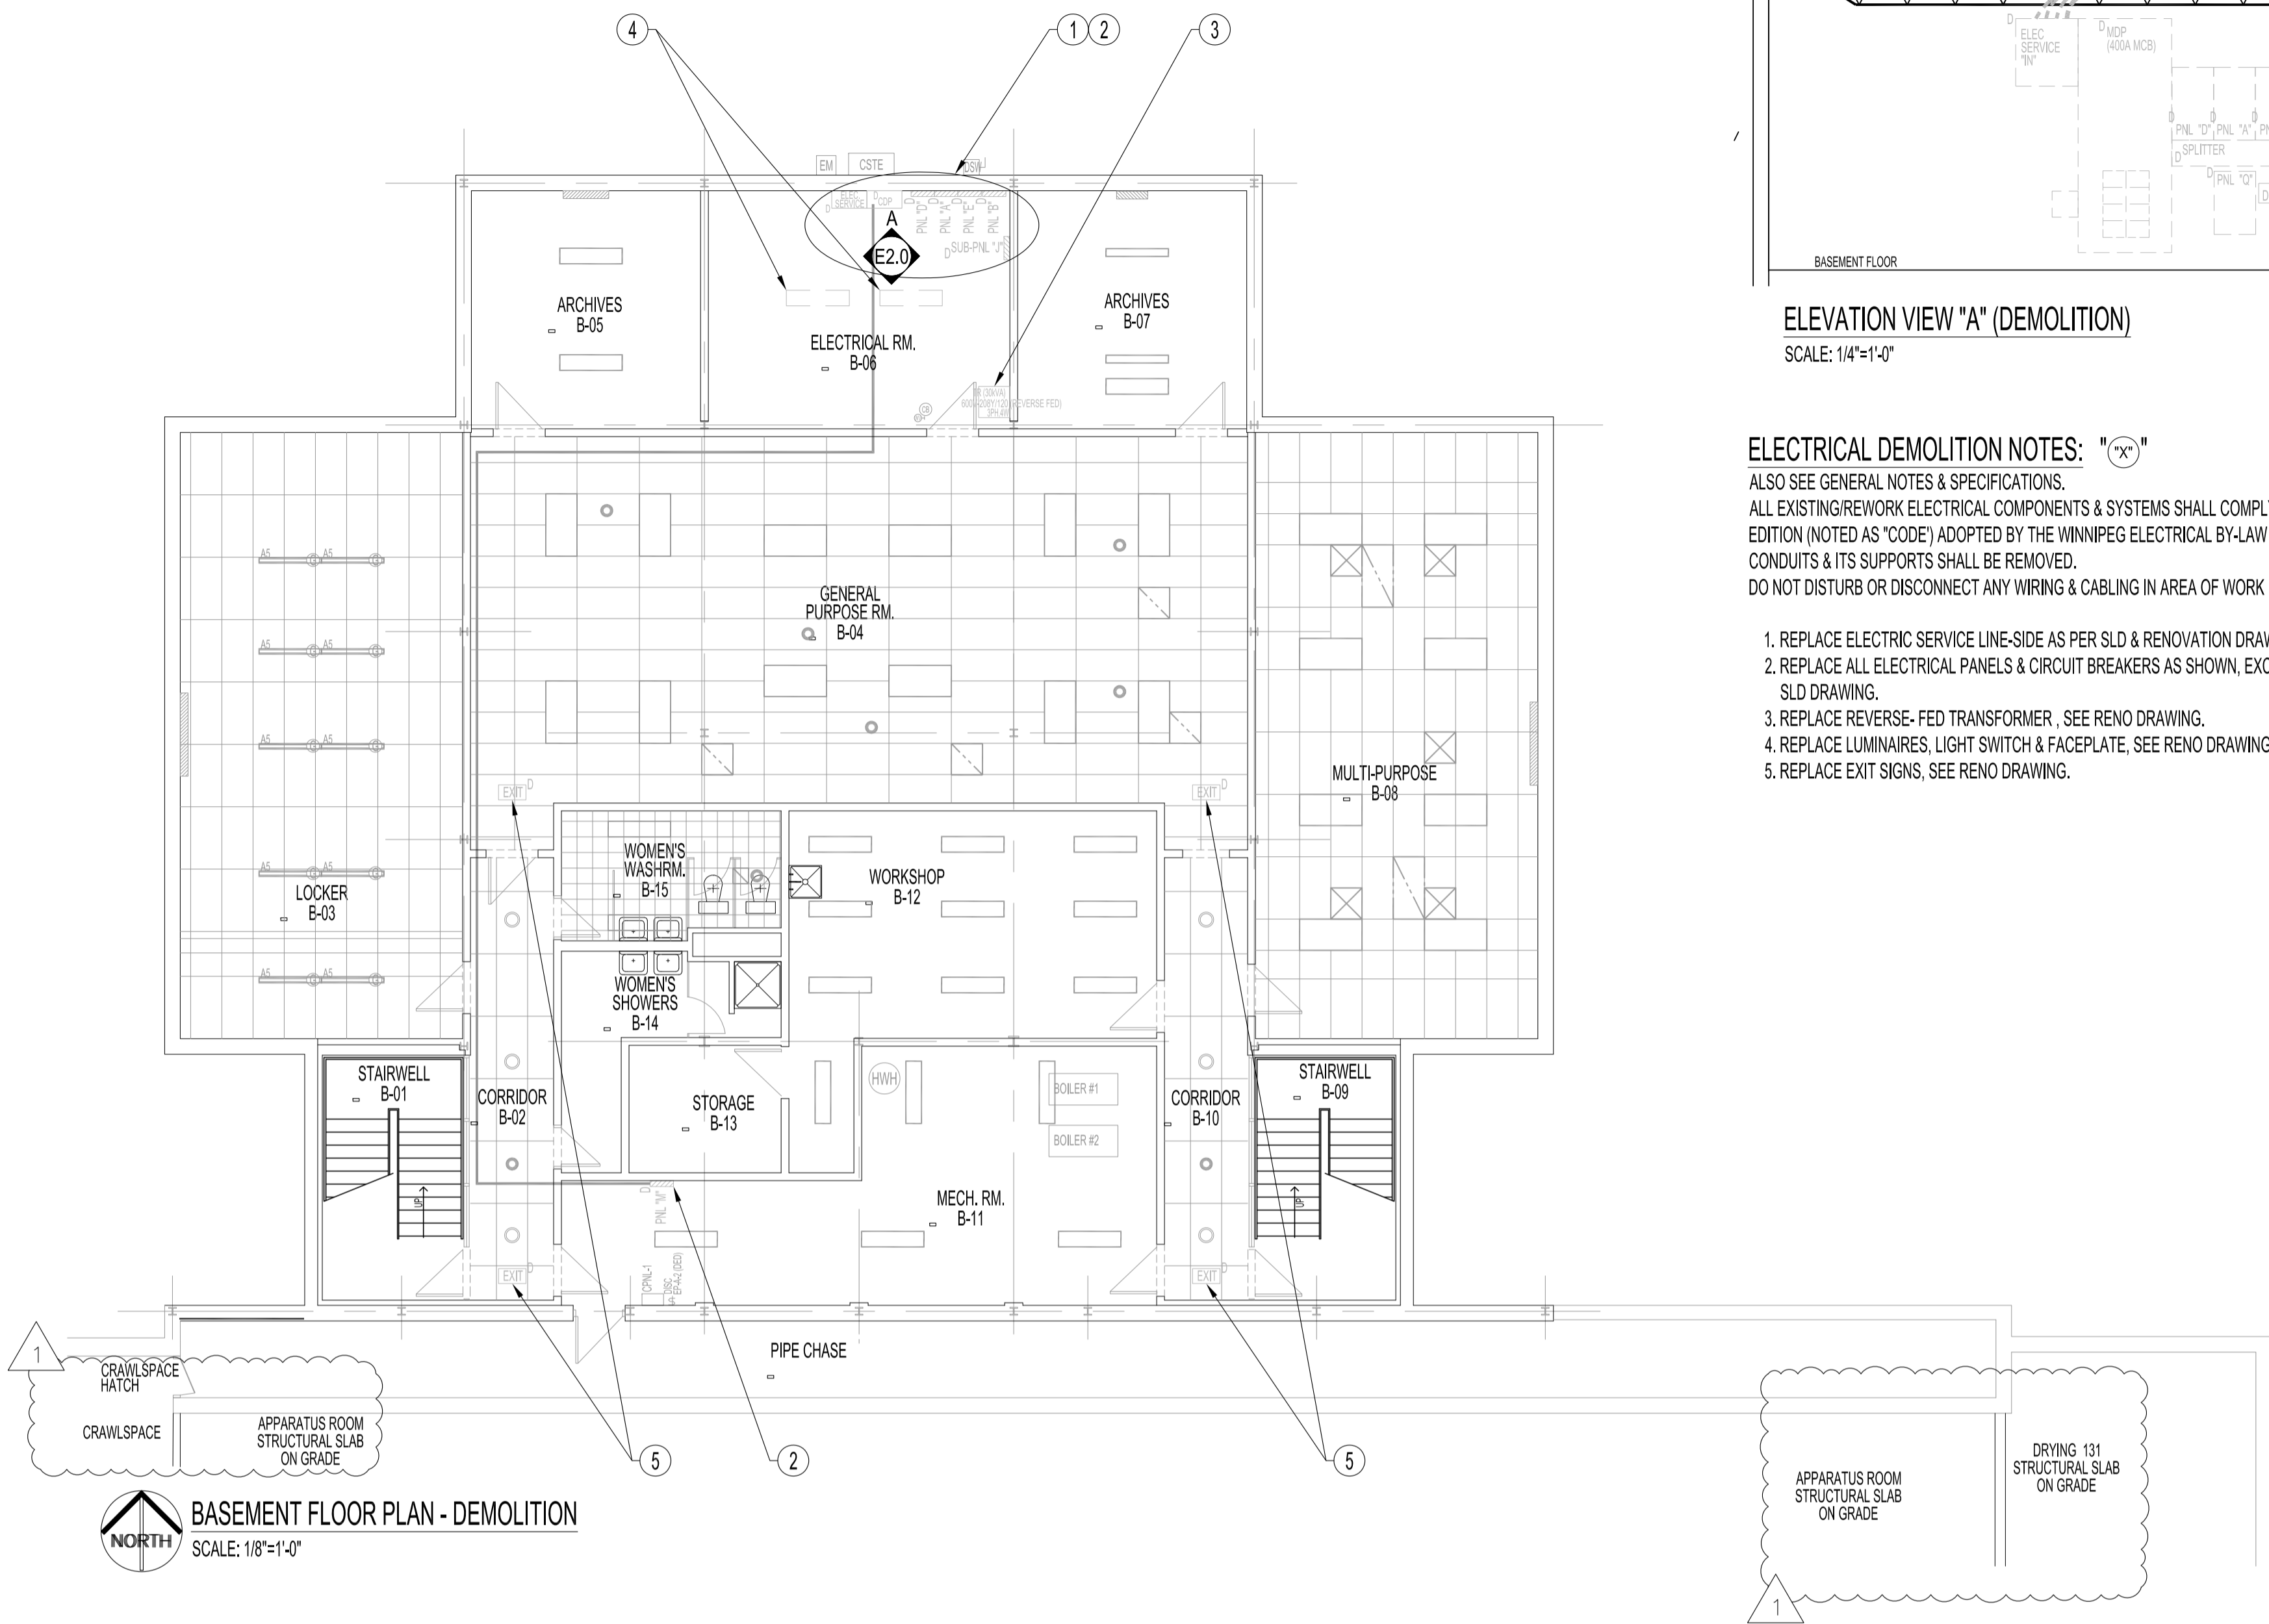

ELEVATION VIEW "A" (DEMOLITION)
SCALE: 1/4"=1'-0"

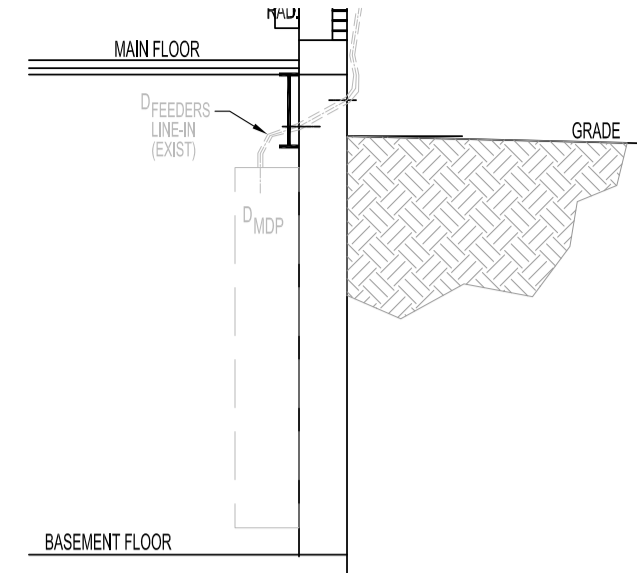

ELEVATION VIEW "A", X-SECTION (DEMOLITION)
SCALE: 1/4"=1'-0"

ELECTRICAL DEMOLITION NOTES: "X"
ALSO SEE GENERAL NOTES & SPECIFICATIONS.
ALL EXISTING/REWORK ELECTRICAL COMPONENTS & SYSTEMS SHALL COMPLY TO THE 2021 CANADIAN ELECTRICAL CODE, PART I, 25TH EDITION (NOTED AS 'CODE') ADOPTED BY THE WINNIPEG ELECTRICAL BY-LAW NO. 72/2022. THIS INCLUDES ABANDONED WIRES, CABLES, CONDUITS & ITS SUPPORTS SHALL BE REMOVED.
DO NOT DISTURB OR DISCONNECT ANY WIRING & CABLING IN AREA OF WORK REQUIRED FOR OTHER AREAS.

1. REPLACE ELECTRIC SERVICE LINE-SIDE AS PER SLD & RENOVATION DRAWINGS.
2. REPLACE ALL ELECTRICAL PANELS & CIRCUIT BREAKERS AS SHOWN, EXCEPT PANEL "SUB-J" SHALL BE REMOVED & RE-CIRC AS PER SLD DRAWING.
3. REPLACE REVERSE-FED TRANSFORMER, SEE RENO DRAWING.
4. REPLACE LUMINAIRES, LIGHT SWITCH & FACEPLATE, SEE RENO DRAWING.
5. REPLACE EXIT SIGNS, SEE RENO DRAWING.

BASEMENT FLOOR PLAN - DEMOLITION
SCALE: 1/8"=1'-0"

No.	REVISION/DESCRIPTION	BY	DATE
1	ISSUED FOR ADDENDUM 1	DTA	2022 12.15
0	ISSUED FOR CONSTRUCTION	DTA	2022 11.03

SEAL

DATE	USER	CHECKED	DESIGNED	APPROVED
2022.10.24	DTA	DTA	DTA	DTA

Winnipeg THE CITY OF WINNIPEG
 PLANNING, PROPERTY AND
 DEVELOPMENT DEPARTMENT
 MUNICIPAL ACCOMMODATIONS DIVISION
 3-65 GARRY STREET, R3C 4K4
 PROJECT
 WINNIPEG FIRE PARAMEDIC SERVICES
 FIRE STATION #1
 ELECTRICAL SERVICE UPGRADE AND EMERGENCY GENERATOR
 65 ELLEN STREET BID OPP: 805-2022

SHEET TITLE
 BASEMENT FLOOR PLAN
 ELECTRICAL - DEMOLITION
 POWER AND SYSTEMS

SCALE	PROJECT No:	SHEET No:
AS SHOWN	2019-150-01	E2.0-R1