

CONSULTANTS

300-275 Carlton Street  
Winnipeg, Manitoba R3C 5R6  
T 204. 943. 7501  
F 204. 943. 7507



Crosier Kilgour  
& Partners Ltd.

CONSULTING STRUCTURAL ENGINEERS

**SMS Engineering**  
770 Bradford Street Winnipeg, Canada (204) 775-0291  
smseng.com

DRAWING INDEX

WWD PROJECT #: W-1049  
PROJECT TITLE: DRINKING WATER TREATMENT PLANT ROOF REPLACEMENT  
BID OPPORTUNITY NO.: 37-2023

GENERAL

CITY OF WINNIPEG DRAWING NO.	CROSIER KILGOUR DRAWING NO.	REV.	DISCIPLINE	TITLE	DRAWING TYPE
1-0601B-G0002-001	S0.1	0	N/A	N/A	N/A
1-0601B-G0003-001	S0.2	02	GENERAL	DRAWING INDEX	N/A

BUILDING

CITY OF WINNIPEG DRAWING NO.	CROSIER KILGOUR DRAWING NO.	REV.	DISCIPLINE	TITLE	DRAWING TYPE
1-0601B-G0004-001	S1.1	01	BUILDING	NOTES, SCHEDULE & LEGENDS	
1-0601B-B0064-001	S2.1	01	BUILDING	WF, WR, WO & WC ROOF DEMOLITION	PLAN
1-0601B-B0065-001	S2.2	0	BUILDING	WP ROOF DEMOLITION	PLAN
1-0601B-B0066-001	S2.3	0	BUILDING	WA ROOF DEMOLITION	PLAN
1-0601B-B0067-001	S2.4	0	BUILDING	WM & WI ROOF DEMOLITION	PLAN
1-0601B-B0068-001	S2.5	01	BUILDING	WF, WR, WO & WC ROOF	PLAN
1-0601B-B0069-001	S2.6	0	BUILDING	WP ROOF	PLAN
1-0601B-B0070-001	S2.7	0	BUILDING	WA ROOF	PLAN
1-0601B-B0071-001	S2.8	0	BUILDING	WM & WI ROOF	PLAN
1-0601B-B0072-001	S3.1	01	BUILDING	ROOF DEMOLITION	DETAILS 1 OF 4
1-0601B-B0073-001	S3.2	0	BUILDING	ROOF DEMOLITION	DETAILS 2 OF 4
1-0601B-B0074-001	S3.3	0	BUILDING	ROOF DEMOLITION	DETAILS 3 OF 4
1-0601B-B0075-001	S3.4	0	BUILDING	ROOF DEMOLITION	DETAILS 4 OF 4
1-0601B-B0076-001	S4.1	0	BUILDING	ROOF	DETAILS 1 OF 9
1-0601B-B0076-002	S4.2	0	BUILDING	ROOF	DETAILS 2 OF 9
1-0601B-B0076-003	S4.3	0	BUILDING	ROOF	DETAILS 3 OF 9
1-0601B-B0076-004	S4.4	0	BUILDING	ROOF	DETAILS 4 OF 9
1-0601B-B0076-005	S4.5	0	BUILDING	ROOF	DETAILS 5 OF 9
1-0601B-B0076-006	S4.6	0	BUILDING	ROOF	DETAILS 6 OF 9
1-0601B-B0076-007	S4.7	0	BUILDING	ROOF	DETAILS 7 OF 9
1-0601B-B0076-008	S4.8	0	BUILDING	ROOF	DETAILS 8 OF 9
1-0601B-B0076-009	S4.9	0	BUILDING	ROOF	DETAILS 9 OF 9

STRUCTURAL



CITY OF WINNIPEG DRAWING NO.	CROSIER KILGOUR DRAWING NO.	REV.	DISCIPLINE	TITLE	DRAWING TYPE
1-0601B-S0038-001	S5.1	01	STRUCTURAL	REINFORCED CONCRETE REPAIR	DETAILS

MECHANICAL

CITY OF WINNIPEG DRAWING NO.	SMS DRAWING NO.	REV.	DISCIPLINE	TITLE	DRAWING TYPE
1-0601B-M0011-001	M1.1	0	MECHANICAL	WF, WR, WO & WC ROOF DEMOLITION	PLAN
1-0601B-M0012-001	M1.2	0	MECHANICAL	WP ROOF DEMOLITION	PLAN
1-0601B-M0013-001	M1.3	0	MECHANICAL	WA ROOF DEMOLITION	PLAN
1-0601B-M0014-001	M1.4	0	MECHANICAL	WM & WI ROOF DEMOLITION	PLAN
1-0601B-M0015-001	M2.17	0	MECHANICAL	WF,WR, WO & WC ROOF"	PLAN
1-0601B-M0016-001	M2.18	0	MECHANICAL	WP ROOF	PLAN
1-0601B-M0017-001	M2.19	0	MECHANICAL	WA ROOF	PLAN
1-0601B-M0018-001	M2.20	0	MECHANICAL	WI & WM ROOF	PLAN
1-0601B-M0019-001	M3.3	0	MECHANICAL	MISCELLANEOUS PLUMBING AND VENTING	DETAILS

PLUMBING

CITY OF WINNIPEG DRAWING NO.	SMS DRAWING NO.	REV.	DISCIPLINE	TITLE	DRAWING TYPE
1-0601B-H0022-001	M2.1	0	PLUMBING	WF, WR, WO & WC STORM DRAIN UPGRADES	LOWER LEVEL PLAN
1-0601B-H0023-001	M2.2	0	PLUMBING	WP STORM DRAIN UPGRADES	LOWER LEVEL PLAN
1-0601B-H0024-001	M2.3	0	PLUMBING	WA STORM DRAIN UPGRADES	LOWER LEVEL PLAN
1-0601B-H0025-001	M2.4	0	PLUMBING	WM & WI STORM DRAIN UPGRADES	LOWER LEVEL PLAN
1-0601B-H0026-001	M2.5	0	PLUMBING	WF, WR, WO & WC STORM DRAIN UPGRADES	FIRST FLOOR PLAN
1-0601B-H0027-001	M2.6	0	PLUMBING	WP STORM DRAIN UPGRADES	FIRST FLOOR PLAN
1-0601B-H0028-001	M2.7	0	PLUMBING	WA STORM DRAIN UPGRADES	FIRST FLOOR PLAN
1-0601B-H0029-001	M2.8	0	PLUMBING	WM & WI STORM DRAIN UPGRADES	FIRST FLOOR PLAN
1-0601B-H0030-001	M2.9	0	PLUMBING	WF, WR, WO & WC STORM DRAIN UPGRADES	SECOND FLOOR PLAN
1-0601B-H0031-001	M2.10	0	PLUMBING	WP STORM DRAIN UPGRADES	SECOND FLOOR PLAN
1-0601B-H0032-001	M2.11	0	PLUMBING	WA STORM DRAIN UPGRADES	SECOND FLOOR PLAN
1-0601B-H0033-001	M2.12	0	PLUMBING	WM & WI STORM DRAIN UPGRADES	SECOND FLOOR PLAN
1-0601B-H0034-001	M2.13	0	PLUMBING	WF, WR, WO & WC STORM DRAIN UPGRADES	THIRD FLOOR PLAN
1-0601B-H0035-001	M2.14	0	PLUMBING	WP STORM DRAIN UPGRADES	THIRD FLOOR PLAN
1-0601B-H0036-001	M2.15	0	PLUMBING	WA STORM DRAIN UPGRADES	THIRD FLOOR PLAN
1-0601B-H0037-001	M2.16	0	PLUMBING	WM & WI STORM DRAIN UPGRADES	THIRD FLOOR PLAN
1-0601B-H0038-001	M3.1	0	PLUMBING	NORTH STORM DRAIN SCHEMATIC	ELEVATION
1-0601B-H0039-001	M3.2	0	PLUMBING	SOUTH STORM DRAIN SCHEMATIC	ELEVATION

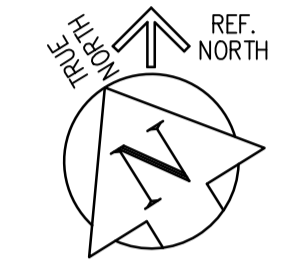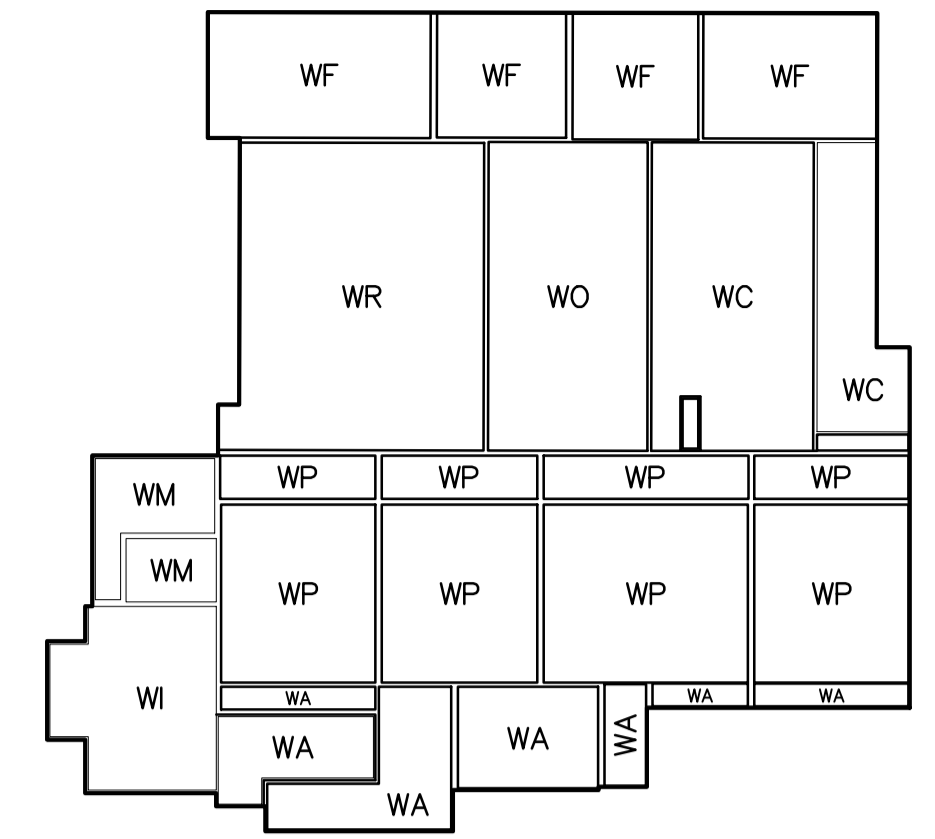

KEY PLAN  
NOT TO SCALE

<p><b>ENGINEERS GEOSCIENTISTS MANITOBA</b> Certificate of Authorization Crosier Kilgour &amp; Partners Ltd. No. 235</p>	B.M. ELEV.		<p>300-275 Carlton Street Winnipeg, Manitoba R3C 5R6 T 204. 943. 7501 F 204. 943. 7507 2022-1008</p>		<p>ENGINEER'S SEAL</p> <p>ORIGINAL DRAWING SEALED BY JOHN WELLS AND DATED 2023-03-21</p>	<p><b>THE CITY OF WINNIPEG</b> WATER AND WASTE DEPARTMENT ENGINEERING DIVISION</p>		
	DESIGNED BY: GJH	CHECKED BY: JAW	DRINKING WATER TREATMENT PLANT MAIN BUILDING ROOF REPLACEMENT				CITY FILE NUMBER: W-1049	
	DRAWN BY: LOL	APPROVED BY: GJH	SCALE: NTS				SHEET 1 OF 1	
	02 ISSUED FOR ADDENDUM 03 23/04/17 GJH	01 ISSUED FOR ADDENDUM 02 23/04/13 GJH	RELEASED FOR CONSTRUCTION BY:				CITY DRAWING NUMBER: 1-0601B-G0003-001	
00 ISSUED FOR TENDER 23/03/21 GJH	NO. REVISIONS	DATE	BY	DATE	2023/04/13	DATE	CONSULTANT DRAWING NO. S0.2	GENERAL DRAWING INDEX