


LAST SAVE: 2025/05/01 - 2:36pm
PATH: M:\694715\EN\49PROC\10 - General DWG\McPhillips\1-0640C-P0002-001-02.dwg
A1 SIZE - 594mm x 841mm

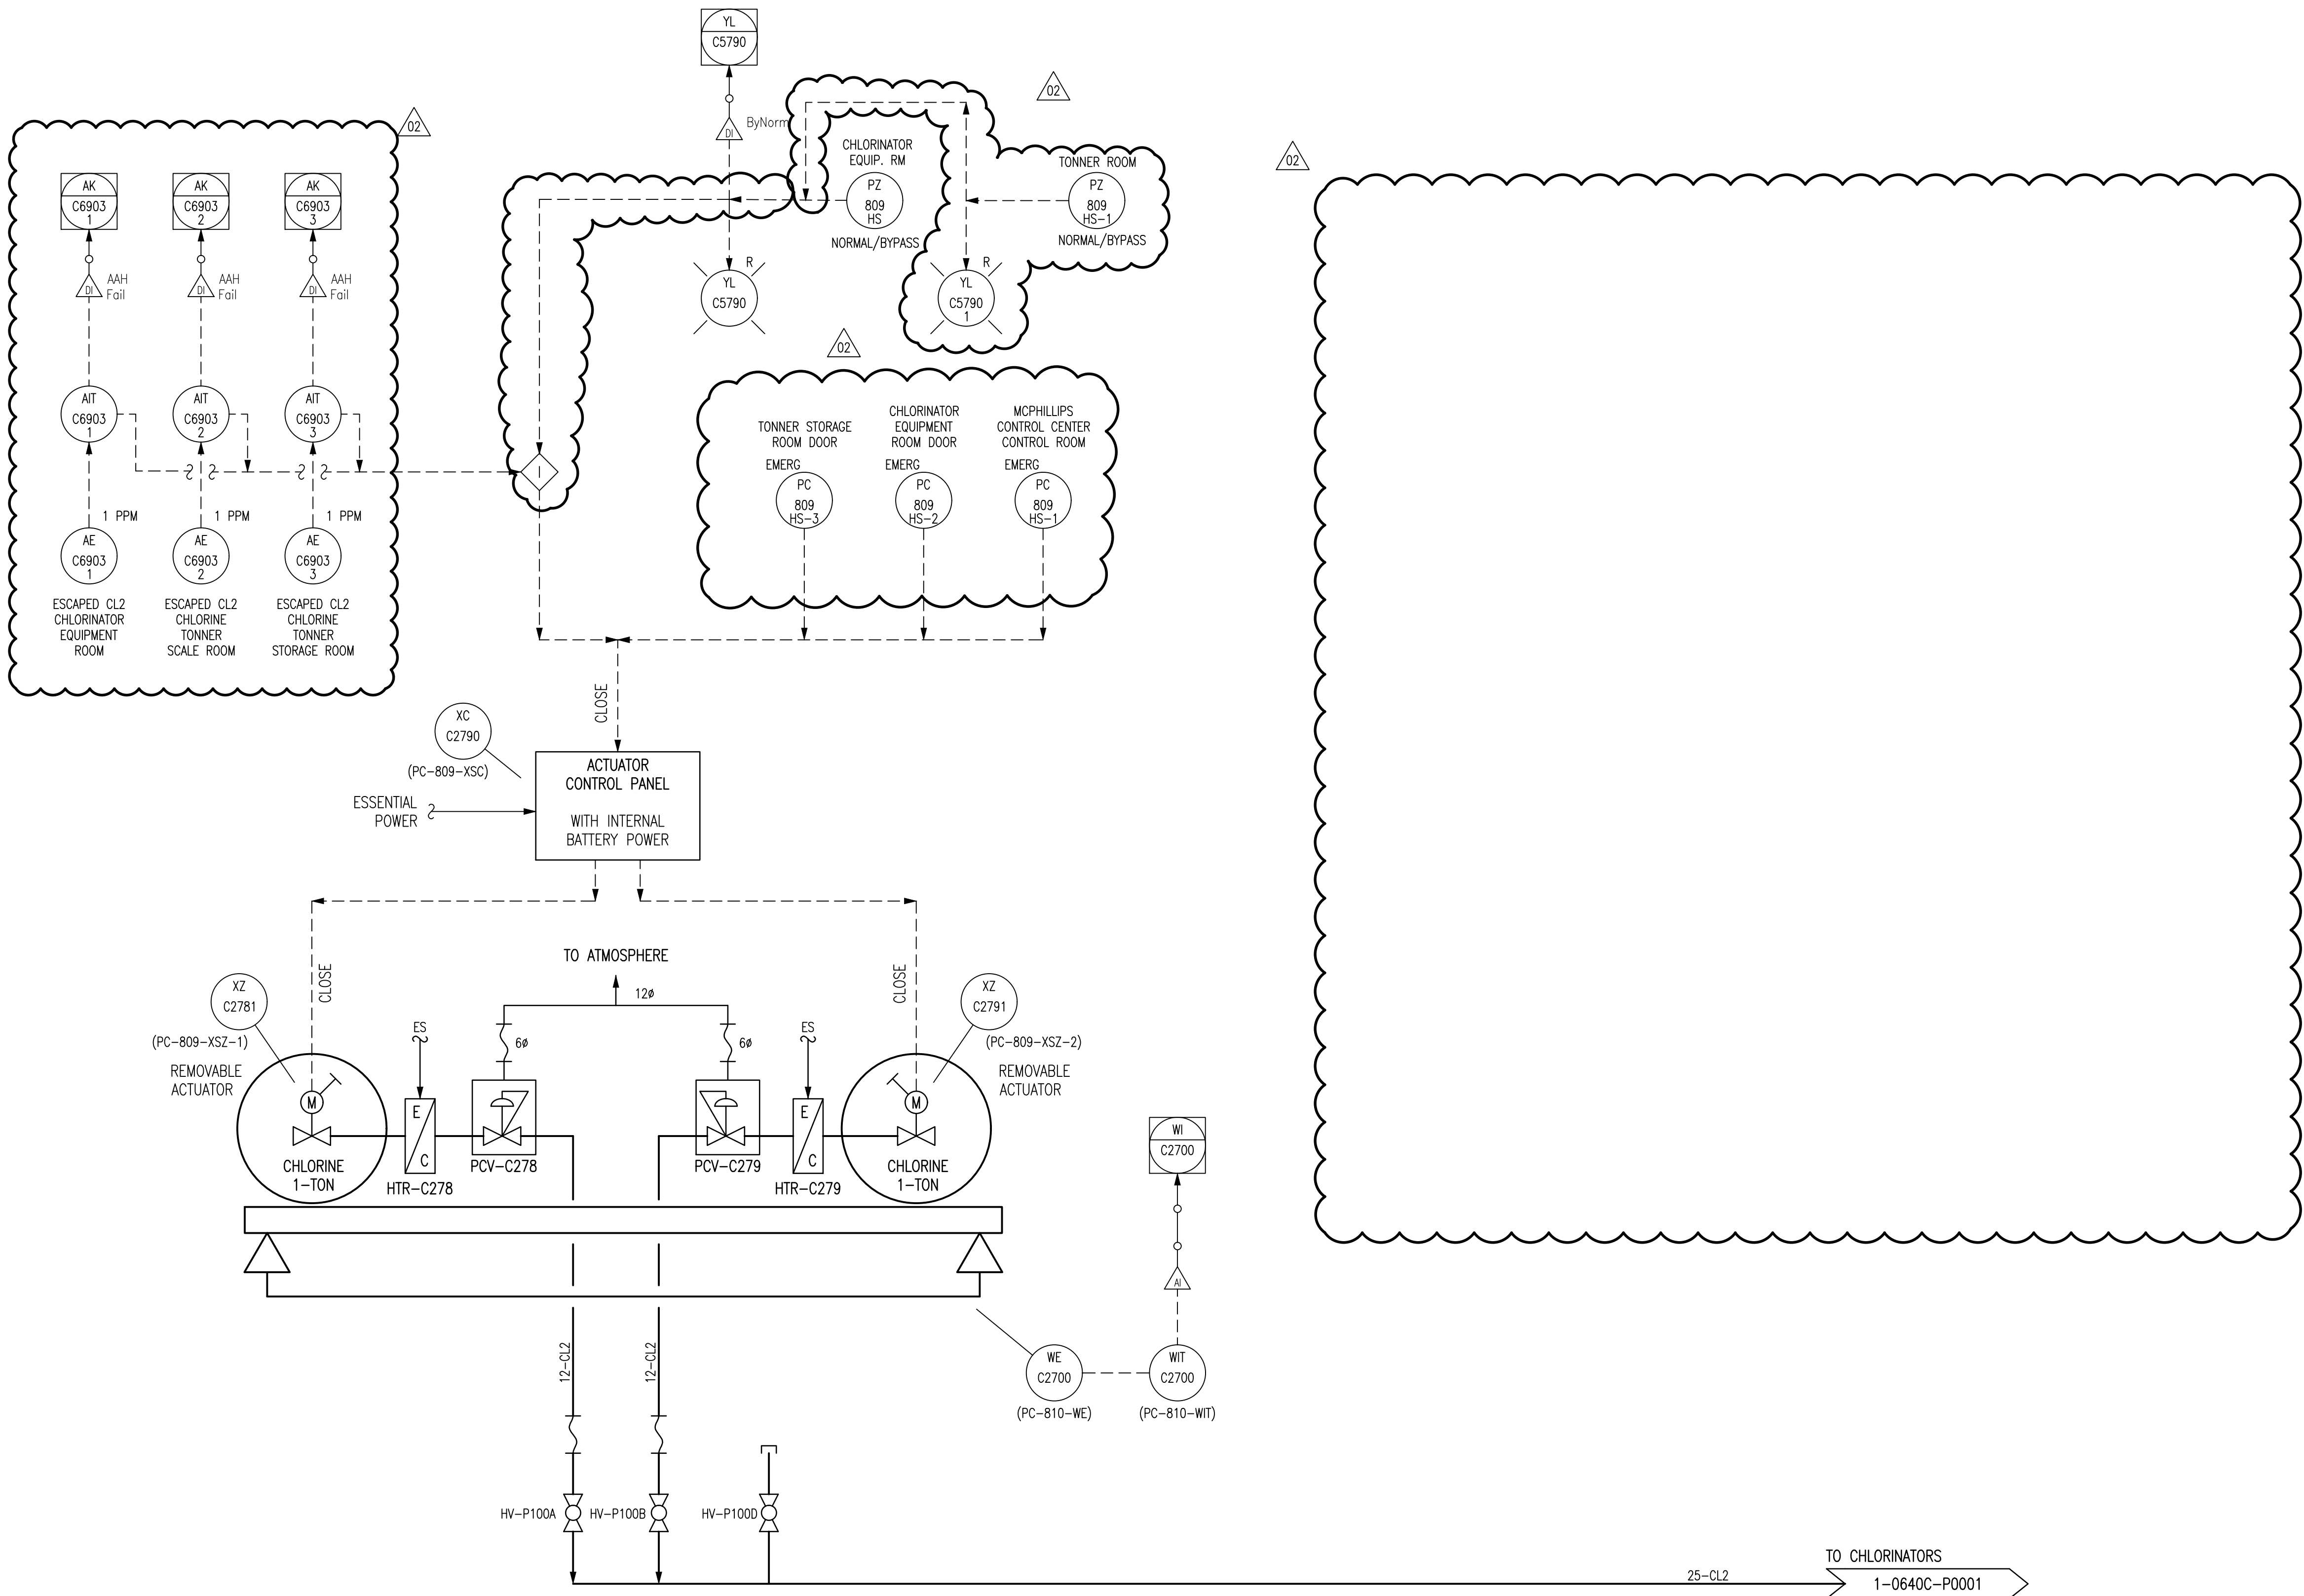

NOTES:
1. DRAWING 1-0640M-A0025 REPRESENTS THE PREVIOUS P&ID. MOST EXISTING DOCUMENTATION IS BASED ON THE IDENTIFICATION SHOWN IN PREVIOUS P&ID.

**ENGINEERS
GEOSCIENTISTS
MANITOBA**
Certificate of Authorization
AtkinsRéalis Canada Inc.
No. 4489

DESIGNED BY: EXISTING				CHECKED BY: T. CHURCH			
DRAWN BY: S. FUNK				APPROVED BY: E. RYCZKOWSKI			
SCALE: NTS				ISSUED FOR CONSTRUCTION BY: M. SKINNER			
DATE: 2013/03/07				DATE: 2025/04/30			
CONSULTANT NO.: 611003-0000-49DD							
02	ISSUED FOR TENDER AND CONSTRUCTION	2025/04/30	VE	VE			
01	REVISED DWG	2019/09/03	-	TL			
00	ISSUED FOR CITY USE	2013/11/29	EFB	TMC			
NO.	REVISIONS	DATE	DESIGN	CHECK			

AtkinsRéalis 148 Nature Park Way, Winnipeg, Manitoba Canada R3P 0X7		THE CITY OF WINNIPEG WATER AND WASTE DEPARTMENT	
DESIGNED BY: EXISTING		CHECKED BY: T. CHURCH	
DRAWN BY: S. FUNK		APPROVED BY: E. RYCZKOWSKI	
SCALE: NTS		ISSUED FOR CONSTRUCTION BY: M. SKINNER	
DATE: 2013/03/07		DATE: 2025/04/30	
CONSULTANT NO.: 611003-0000-49DD			
CITY DRAWING NUMBER 1-0640C-P0002		SHEET 001	REV. 02
		SIZE A1	

1-0640A-P0001	PROCESS & INSTRUMENTATION DIAGRAM LEGEND & DETAILS
DRAWING NUMBER	REFERENCE DRAWINGS