
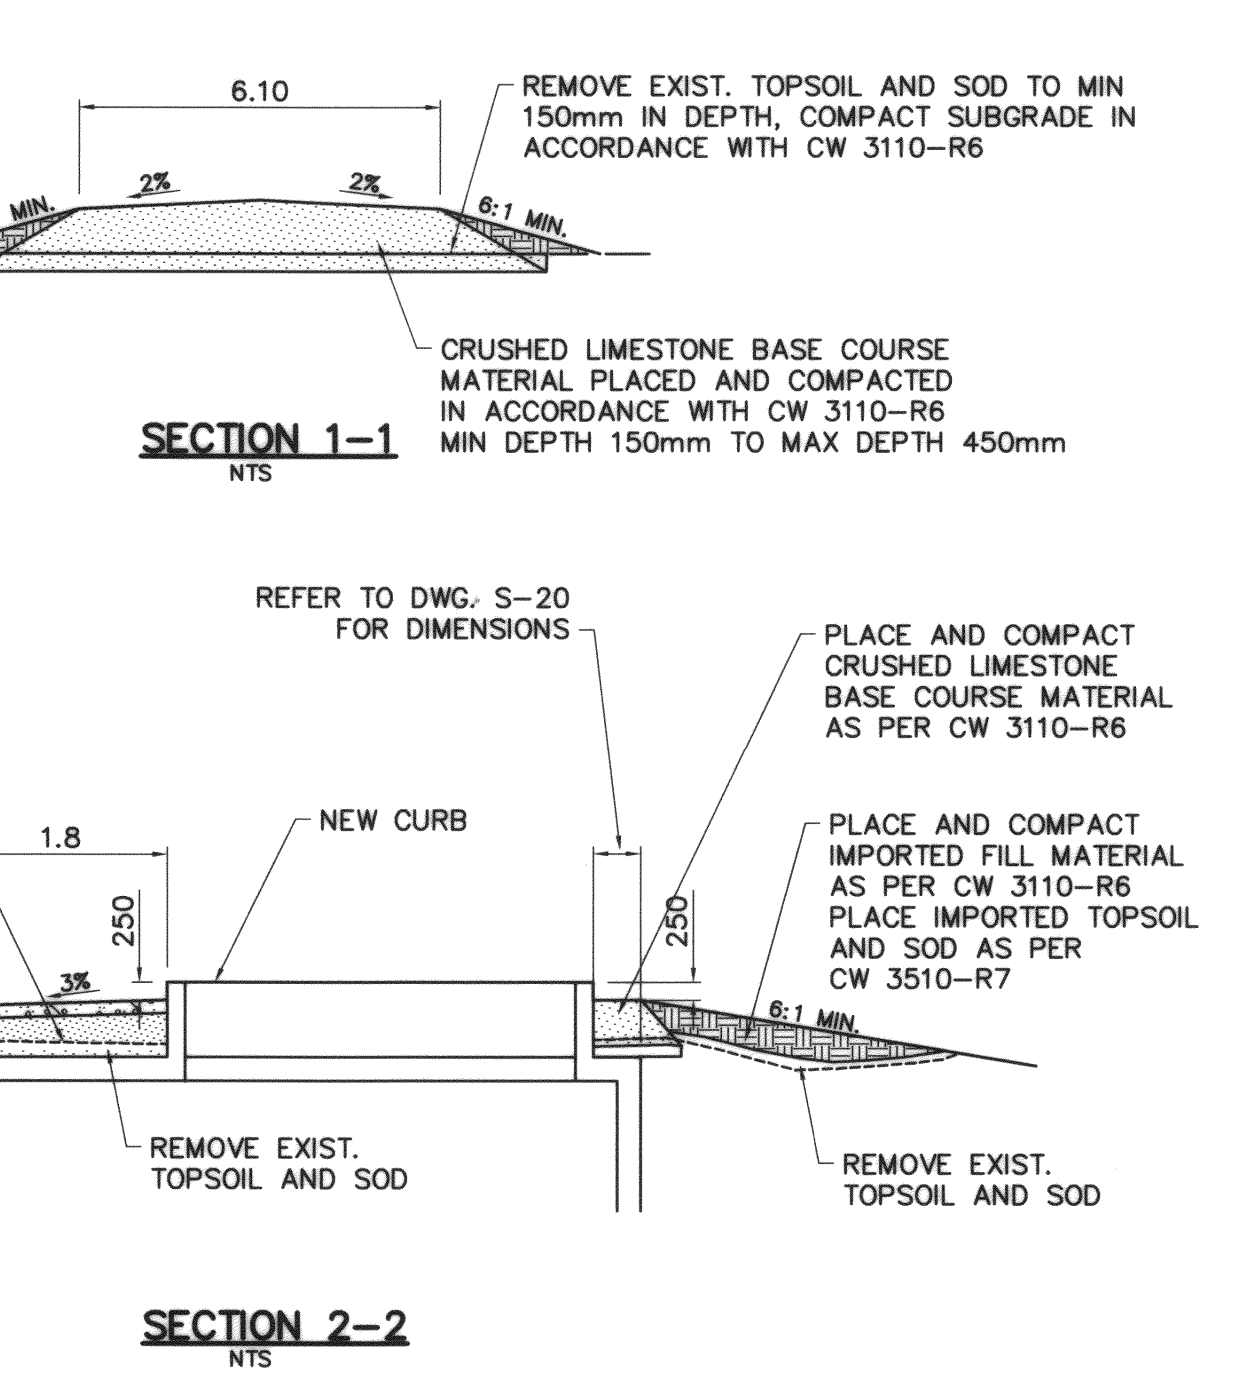


SHEET: 03-11-1 (17/0000)

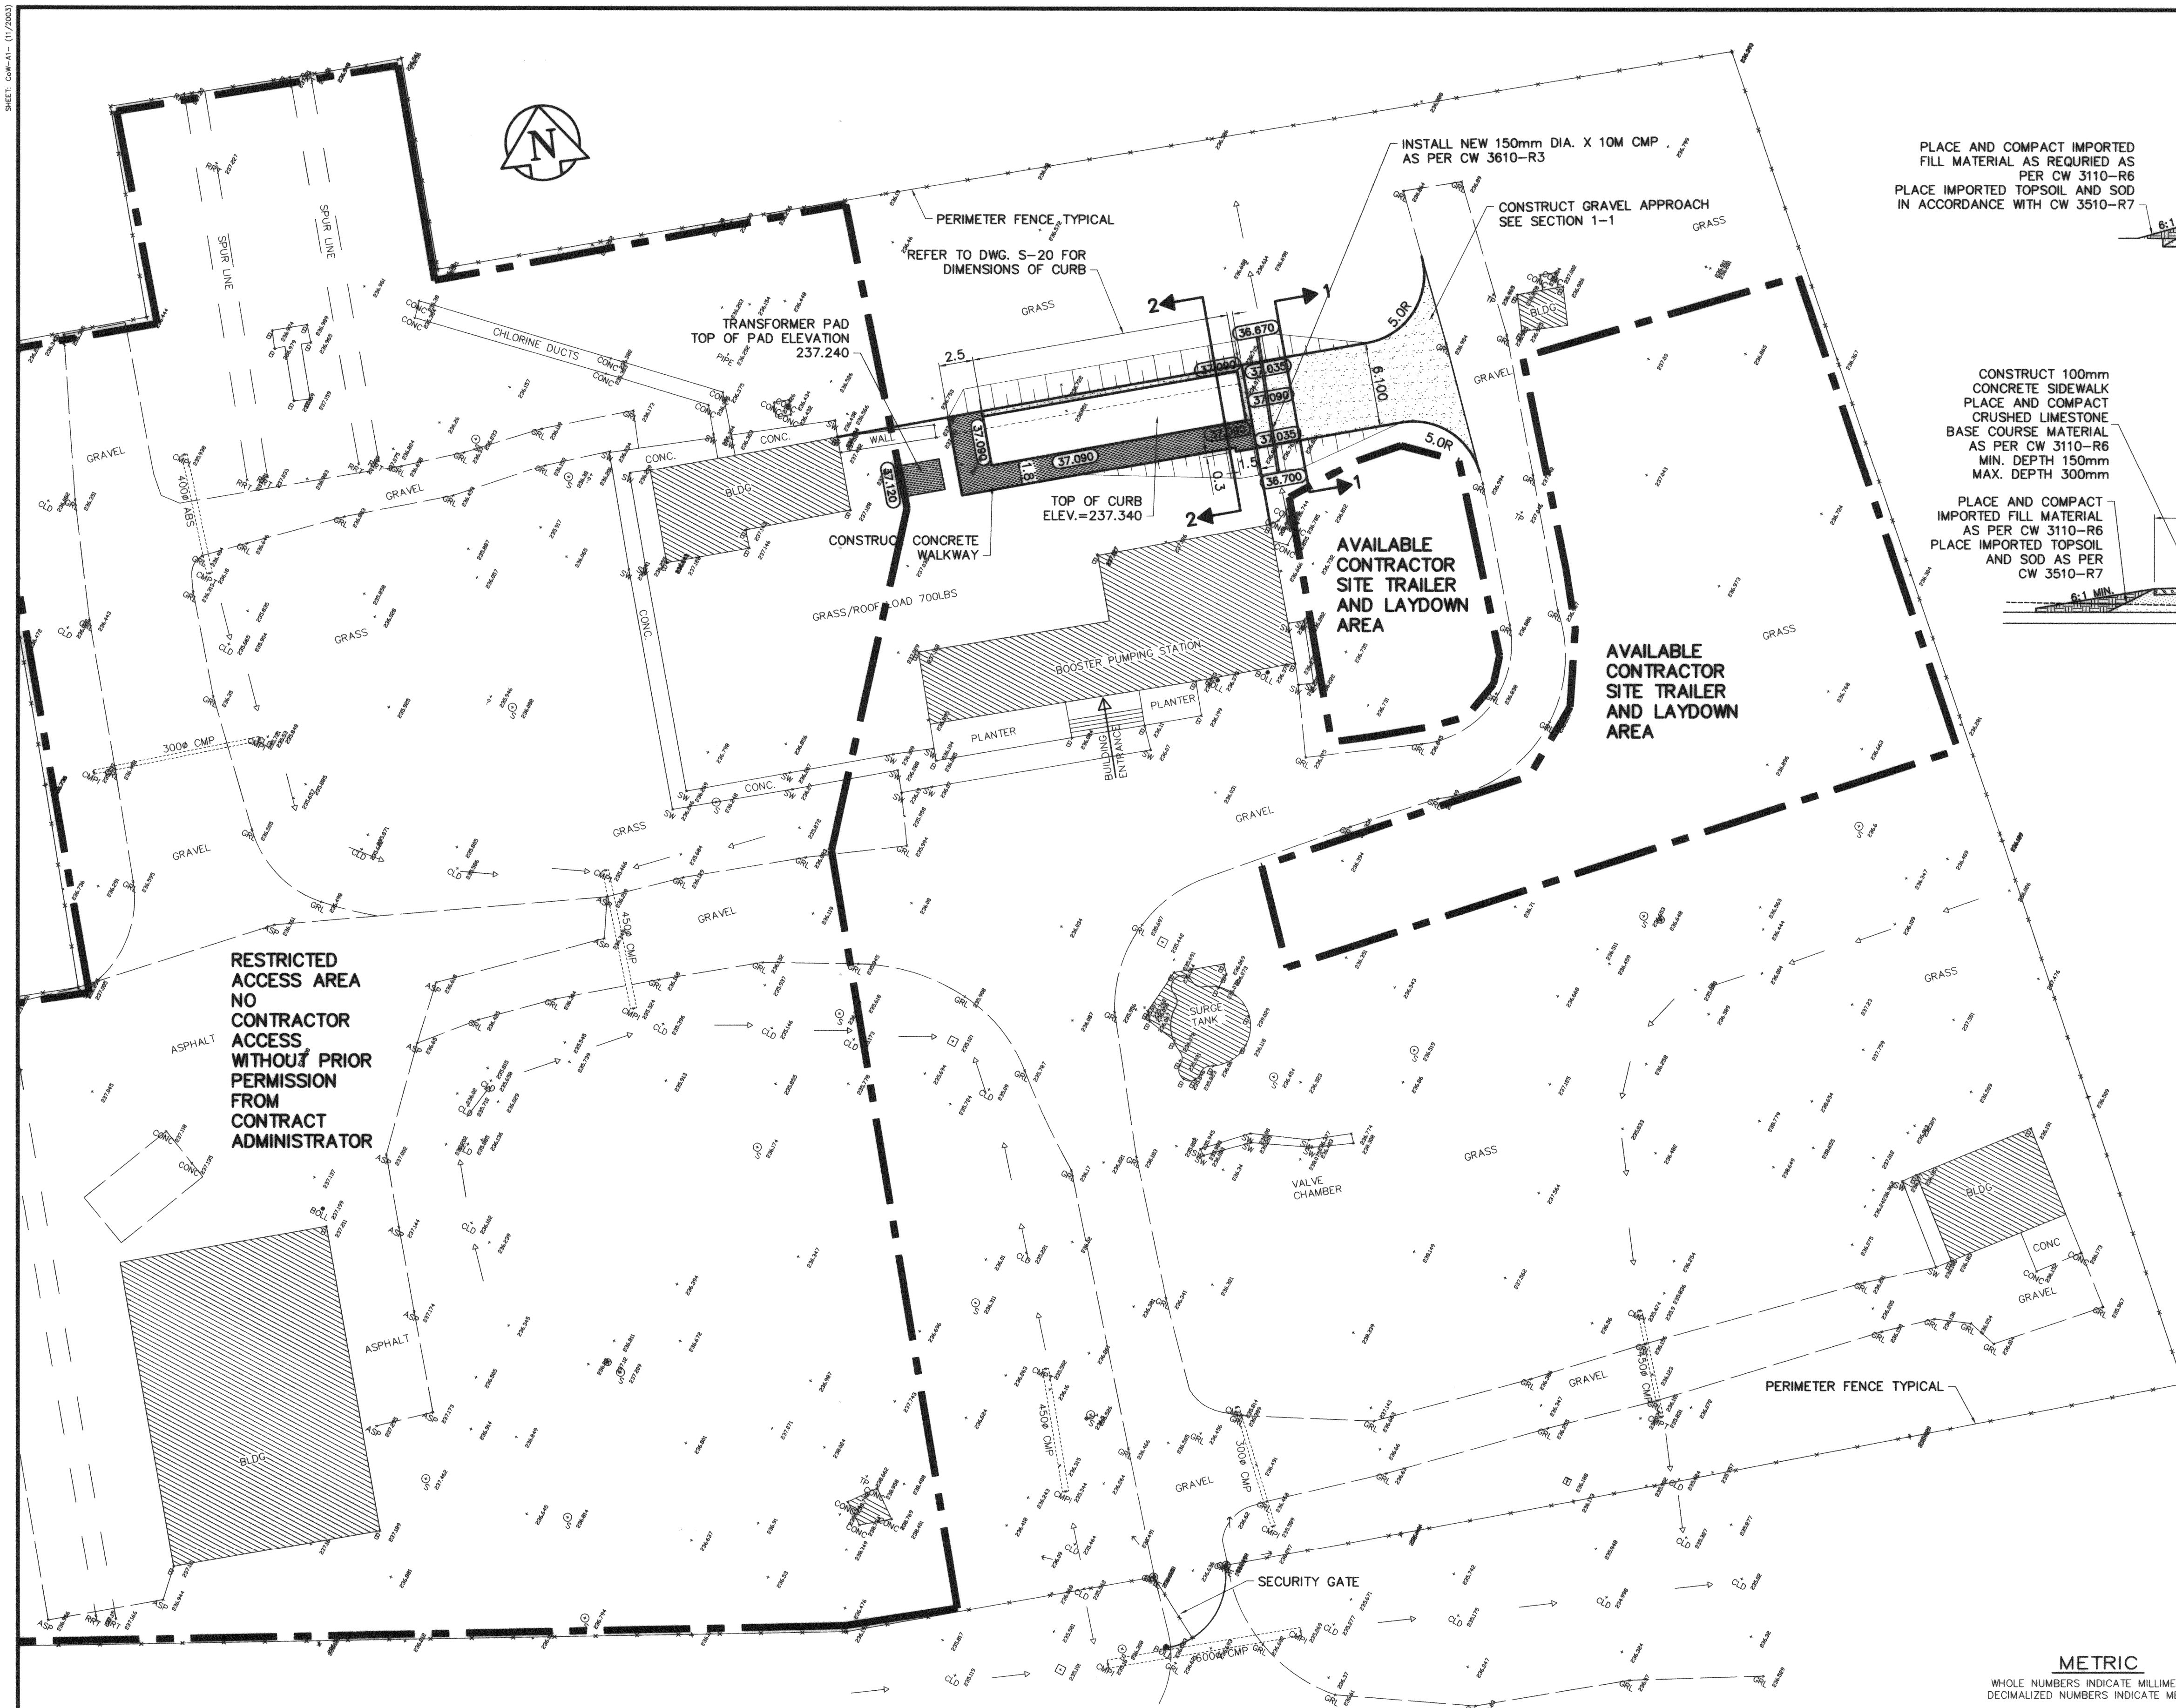

**RESTRICTED ACCESS AREA  
NO CONTRACTOR ACCESS  
WITHOUT PRIOR PERMISSION  
FROM CONTRACT ADMINISTRATOR**

- CONSTRUCTION NOTES:**
1. ALL SURFACE WORKS TO BE CONSTRUCTED IN ACCORDANCE WITH THE LATEST EDITION OF THE CITY OF WINNIPEG STANDARD CONSTRUCTION SPECIFICATIONS AND ALL TERMS AND CONDITIONS INCLUDED THEREIN.
  2. SPECIFICATIONS GOVERNING SURFACE WORKS SHALL INCLUDE BUT NOT BE LIMITED TO THE FOLLOWING:  
 CW 3110-R6 SUBGRADE, SUB-BASE AND BASE COURSE CONSTRUCTION  
 CW 3150-R4 GRAVEL SURFACING  
 CW 3170-R3 EARTHWORK AND GRADING  
 CW 3325-R2 PORTLAND CEMENT CONCRETE SIDEWALK  
 CW 3510-R7 SODDING  
 CW 3610-R3 INSTALLATIONS OF CULVERTS

**NOTE:**  
CONTRACTOR VEHICLE PARKING NOT PERMITTED INSIDE PERIMETER FENCE, ALL PARKING ALONG SOUTH SIDE OF DEACON ACCESS ROAD AND SUBJECT TO CONTRACT ADMINISTRATOR'S APPROVAL.

**METRIC**  
WHOLE NUMBERS INDICATE MILLIMETRES  
DECIMALIZED NUMBERS INDICATE METRES

150 mm W.M.	WATERMAIN HYDRANT	150 mm W.M.	HYDRO M.T.S.	150 mm W.M.	WATERMAIN HYDRANT
300mm L.D.S.	LAND DRAINAGE SEWER	300mm L.D.S.	CONCRETE ASPHALT	300mm L.D.S.	LAND DRAINAGE SEWER
250mm W.W.S.	WASTEWATER SEWER	250mm W.W.S.	PROPERTY LINE	250mm W.W.S.	WASTE WATER SEWER
	MANHOLE		SURVEY BAR		WASTE WATER SEWER
	CATCH BASIN		ELEVATION		Q PROFILE
	CURB INLET		TREE		
	JUNCTIONS		SIDEWALK RAMP		
	CULVERT		CONCRETE SIDEWALK		
	GAS		FENCE		
EXISTING	LEGEND - PLAN	PROPOSED	EXISTING	LEGEND - PLAN	PROPOSED
EXISTING	LEGEND - PROFILE	PROPOSED	EXISTING	LEGEND - PROFILE	PROPOSED

**APECA**  
Certificate of Authorization  
Earth Tech Canada Inc.  
No. 730 Expiry: April 30, 2004

B.M. EARTH TECH SURVEY BASED ON MAIN FLOOR OF BUILDING BOOSTER PUMPING STATION ELEVATION = 236.500

ISSUED FOR TENDER 03/12/12 PAAP

NO. REVISIONS DATE BY

**EARTH TECH**  
DESIGNED BY: KWR  
DRAWN BY: PAAP  
HOR. SCALE: 1:250  
VERTICAL SCALE:

**CH2MHILL**  
CHECKED BY: NHK  
APPROVED BY: DT  
RELEASED FOR CONSTRUCTION BY:

DATE 2003/11/13

ENGINEER'S SEAL  
PROVINCE OF MANITOBA  
K.W. RAE  
Dec 16/03  
REGISTERED PROFESSIONAL ENGINEER

CONSULTANT DRAWING NO. 63672-C5-U01

**THE CITY OF WINNIPEG**  
Winnipeg WATER AND WASTE DEPARTMENT

**DEACON ULTRAVIOLET (UV) LIGHT DISINFECTATION PROJECT**

GENERAL - UV INSTALLATION SITE PLAN

CITY FILE NUMBER  
SHEET 3 OF 3  
CITY DRAWING NUMBER  
**D-8384**