


DRAWN BY	AA
CHECKED BY	CB
DATE	APRIL 2004
PROJECT NO.	
REV. DATE	
REVISIONS	
1.	ISSUED FOR 50% REVIEW FEBRUARY 6, 2004
2.	ISSUED FOR 75% REVIEW MARCH 5, 2004
3.	ISSUED FOR PRETENDER REVIEW APRIL 2004
4.	ISSUED FOR TENDER MAY 14, 2004

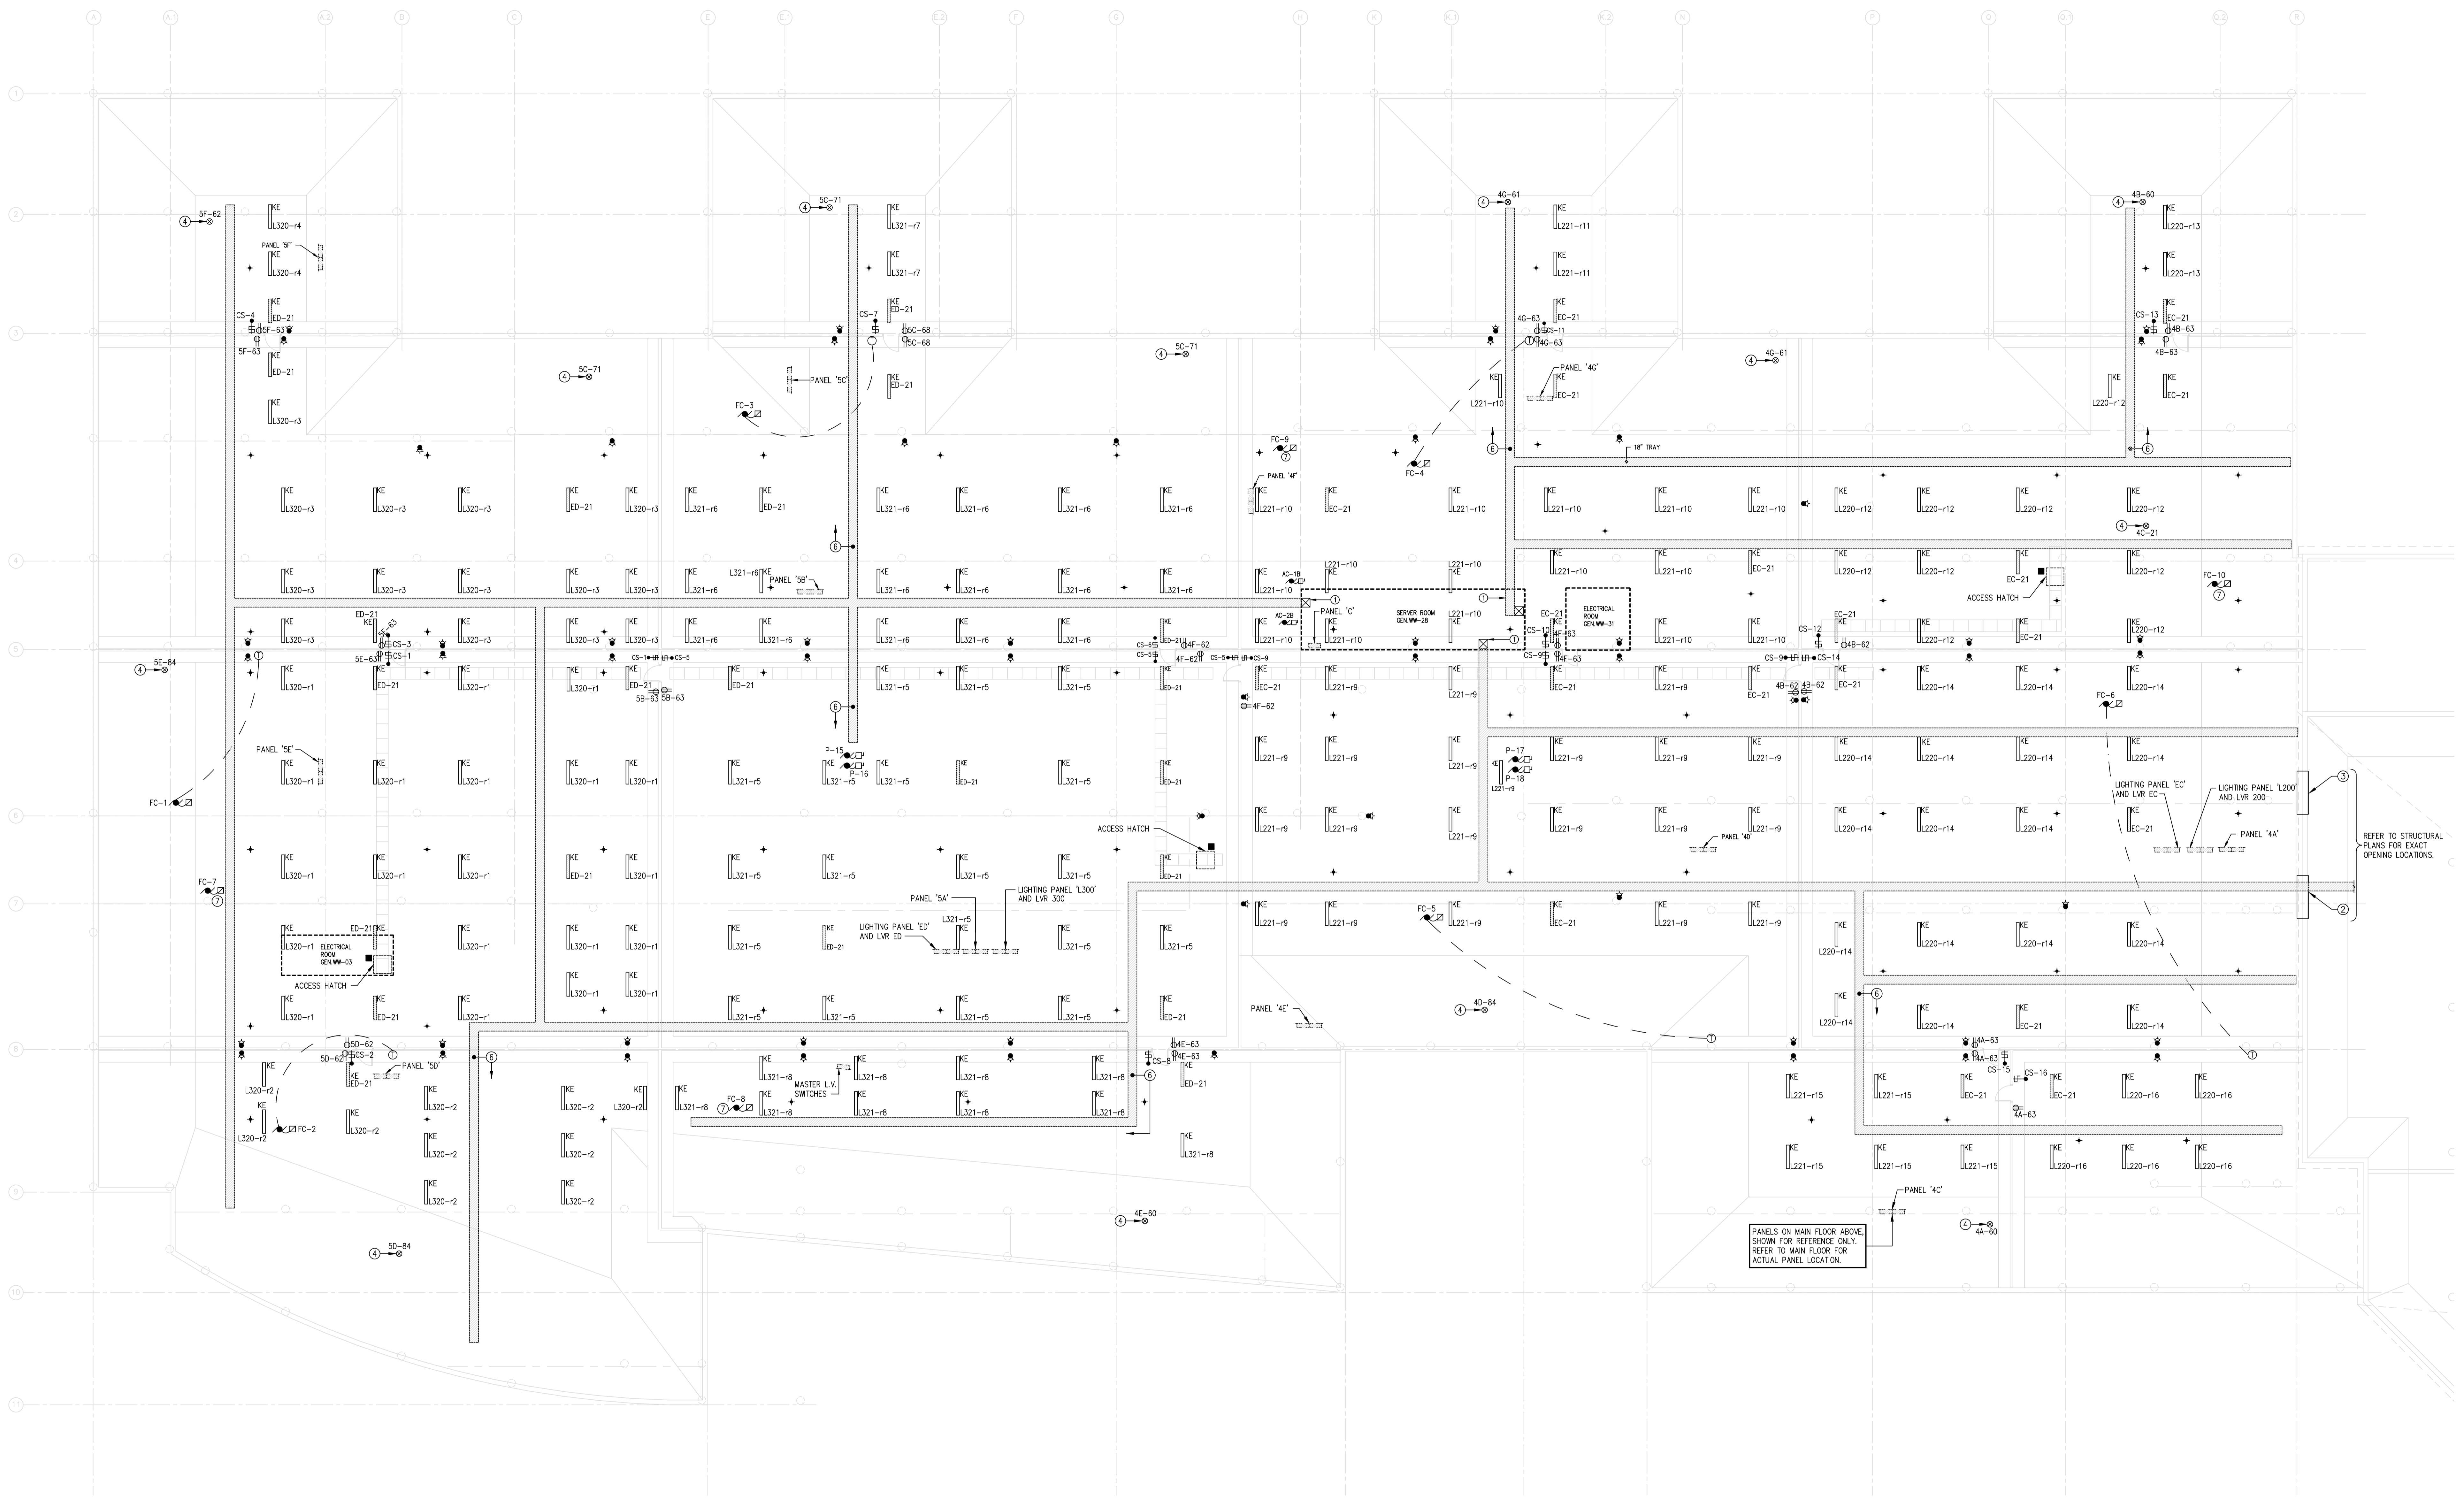

CRAWLSPACE PLAN - ELECTRICAL
 SCALE 1/20

- GENERAL NOTES:
- FIRE ALARM - ADJACENT BELL/SIROBES IN AN AREA TO BE ON ALTERNATE BELL/SIROBRE CIRCUITS.
- NOTES:
- TRAY GOES UP INTO SERVER ROOM, TO CEILING TRAY.
 - G.C. TO PROVIDE OPENING FOR NEW CABLE TRAY INTO EXISTING CRAWLSPACE, (APPROXIMATELY 18" WIDE x 12" DEEP)
 - G.C. TO PROVIDE OPENING UNDER GRADE BEAM FOR 600V FEEDERS INTO EXISTING CRAWLSPACE.
 - 120V CONNECTION TO CONTROL TRANSFORMER FOR MECHANICAL CONTROLS.
 - CABLE TRAY IS 24" WIDE AS PER ED-8 UNLESS NOTED OTHERWISE.
 - CABLE TRAY IS 12" WIDE.
 - REFER TO MAIN FLOOR PLANS FOR THERMOSTAT LOCATIONS FOR THIS FAN COIL.



SMS Engineering Ltd. Consulting Engineers
 770 Buxton Street Winnipeg MB Canada R3B 0G3
 Telephone: 204.772.9301 Fax: 204.772.9300
 smseng.com

ORIGINAL CONTRACT DRAWING
 OPENED AND RESEAL BY
 ANDY LOHSE, P.ENG.
 MAY 12, 2004



Certificate of Authorization
 SMS Engineering Ltd.
 No. 106 Expiry: April 30, 2005

Drawings and specifications, as
 instruments of service are the
 property of the architect, the
 copyright in the same being
 reserved to him. No reproduction
 may be made without the
 permission of the architect and
 where made, must bear his name.
 All prints to be returned to the
 architect.
 The contractor shall verify
 dimensions and data noted herein
 with conditions on the site and is
 held responsible for reporting any
 discrepancy to the architect for
 adjustment.
 This drawing shall not be used for
 building purposes and
 counterigned by:

THE
 CITY OF
 WINNIPEG

OFFICE ADDITION AND RENOVATION
 1155 PACIFIC AVENUE
 WINNIPEG, MANITOBA



NEW CRAWLSPACE PLAN
 LIGHTING, POWER AND SYSTEMS

E2.2

E2019e22.dwg 5-13-04 2:27:31 pm CST