


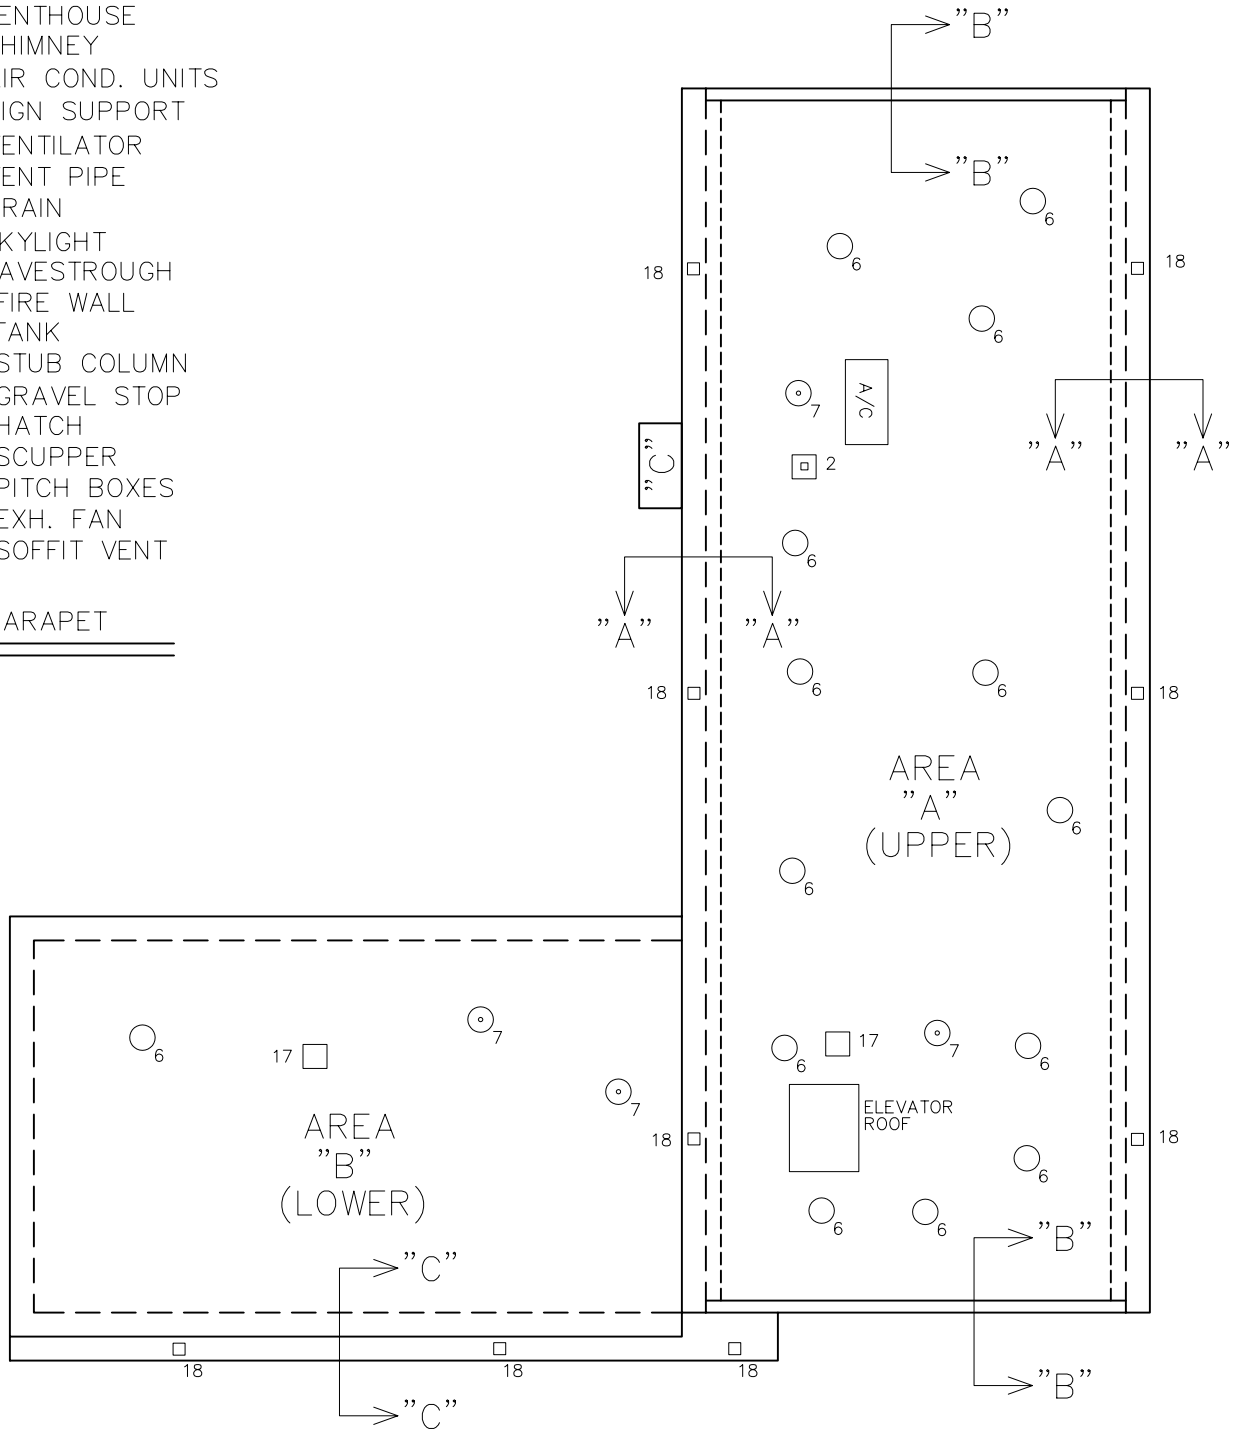

CODE

- 1. PENTHOUSE
- 2. CHIMNEY
- 3. AIR COND. UNITS
- 4. SIGN SUPPORT
- 5. VENTILATOR
- 6. VENT PIPE
- 7. DRAIN
- 8. SKYLIGHT
- 9. EAVESTROUGH
- 10. FIRE WALL
- 11. TANK
- 12. STUB COLUMN
- 13. GRAVEL STOP
- 14. HATCH
- 15. SCUPPER
- 16. PITCH BOXES
- 17. EXH. FAN
- 18. SOFFIT VENT

PARAPET



	CITY OF WINNIPEG PLANNING, PROPERTY & DEVELOPMENT DEPARTMENT CIVIC ACCOMMODATIONS DIVISION 300-65 GARRY STREET R3C 4K4			PROJECT ROOF REPLACEMENT 385 RIVER AVENUE		SHEET TITLE ROOF PLAN	
	DRAWN BY MBD	CHECKED BY LR	APPROVED BY LR	DATE 2003.03.24 eFILE 2004-031A1 .dwg	SCALE NTS PROJECT NO. 2004-031	SHEET NO. A-1	