




**THE CITY OF WINNIPEG**  
**PUBLIC WORKS DEPARTMENT**  
**ENGINEERING DIVISION**  
**SAND and SALT STORAGE FACILITY**  
**at 1539 WAVERLEY STREET**  
**YARD WORKS**  
**BID OPPORTUNITY No. 187-2004**

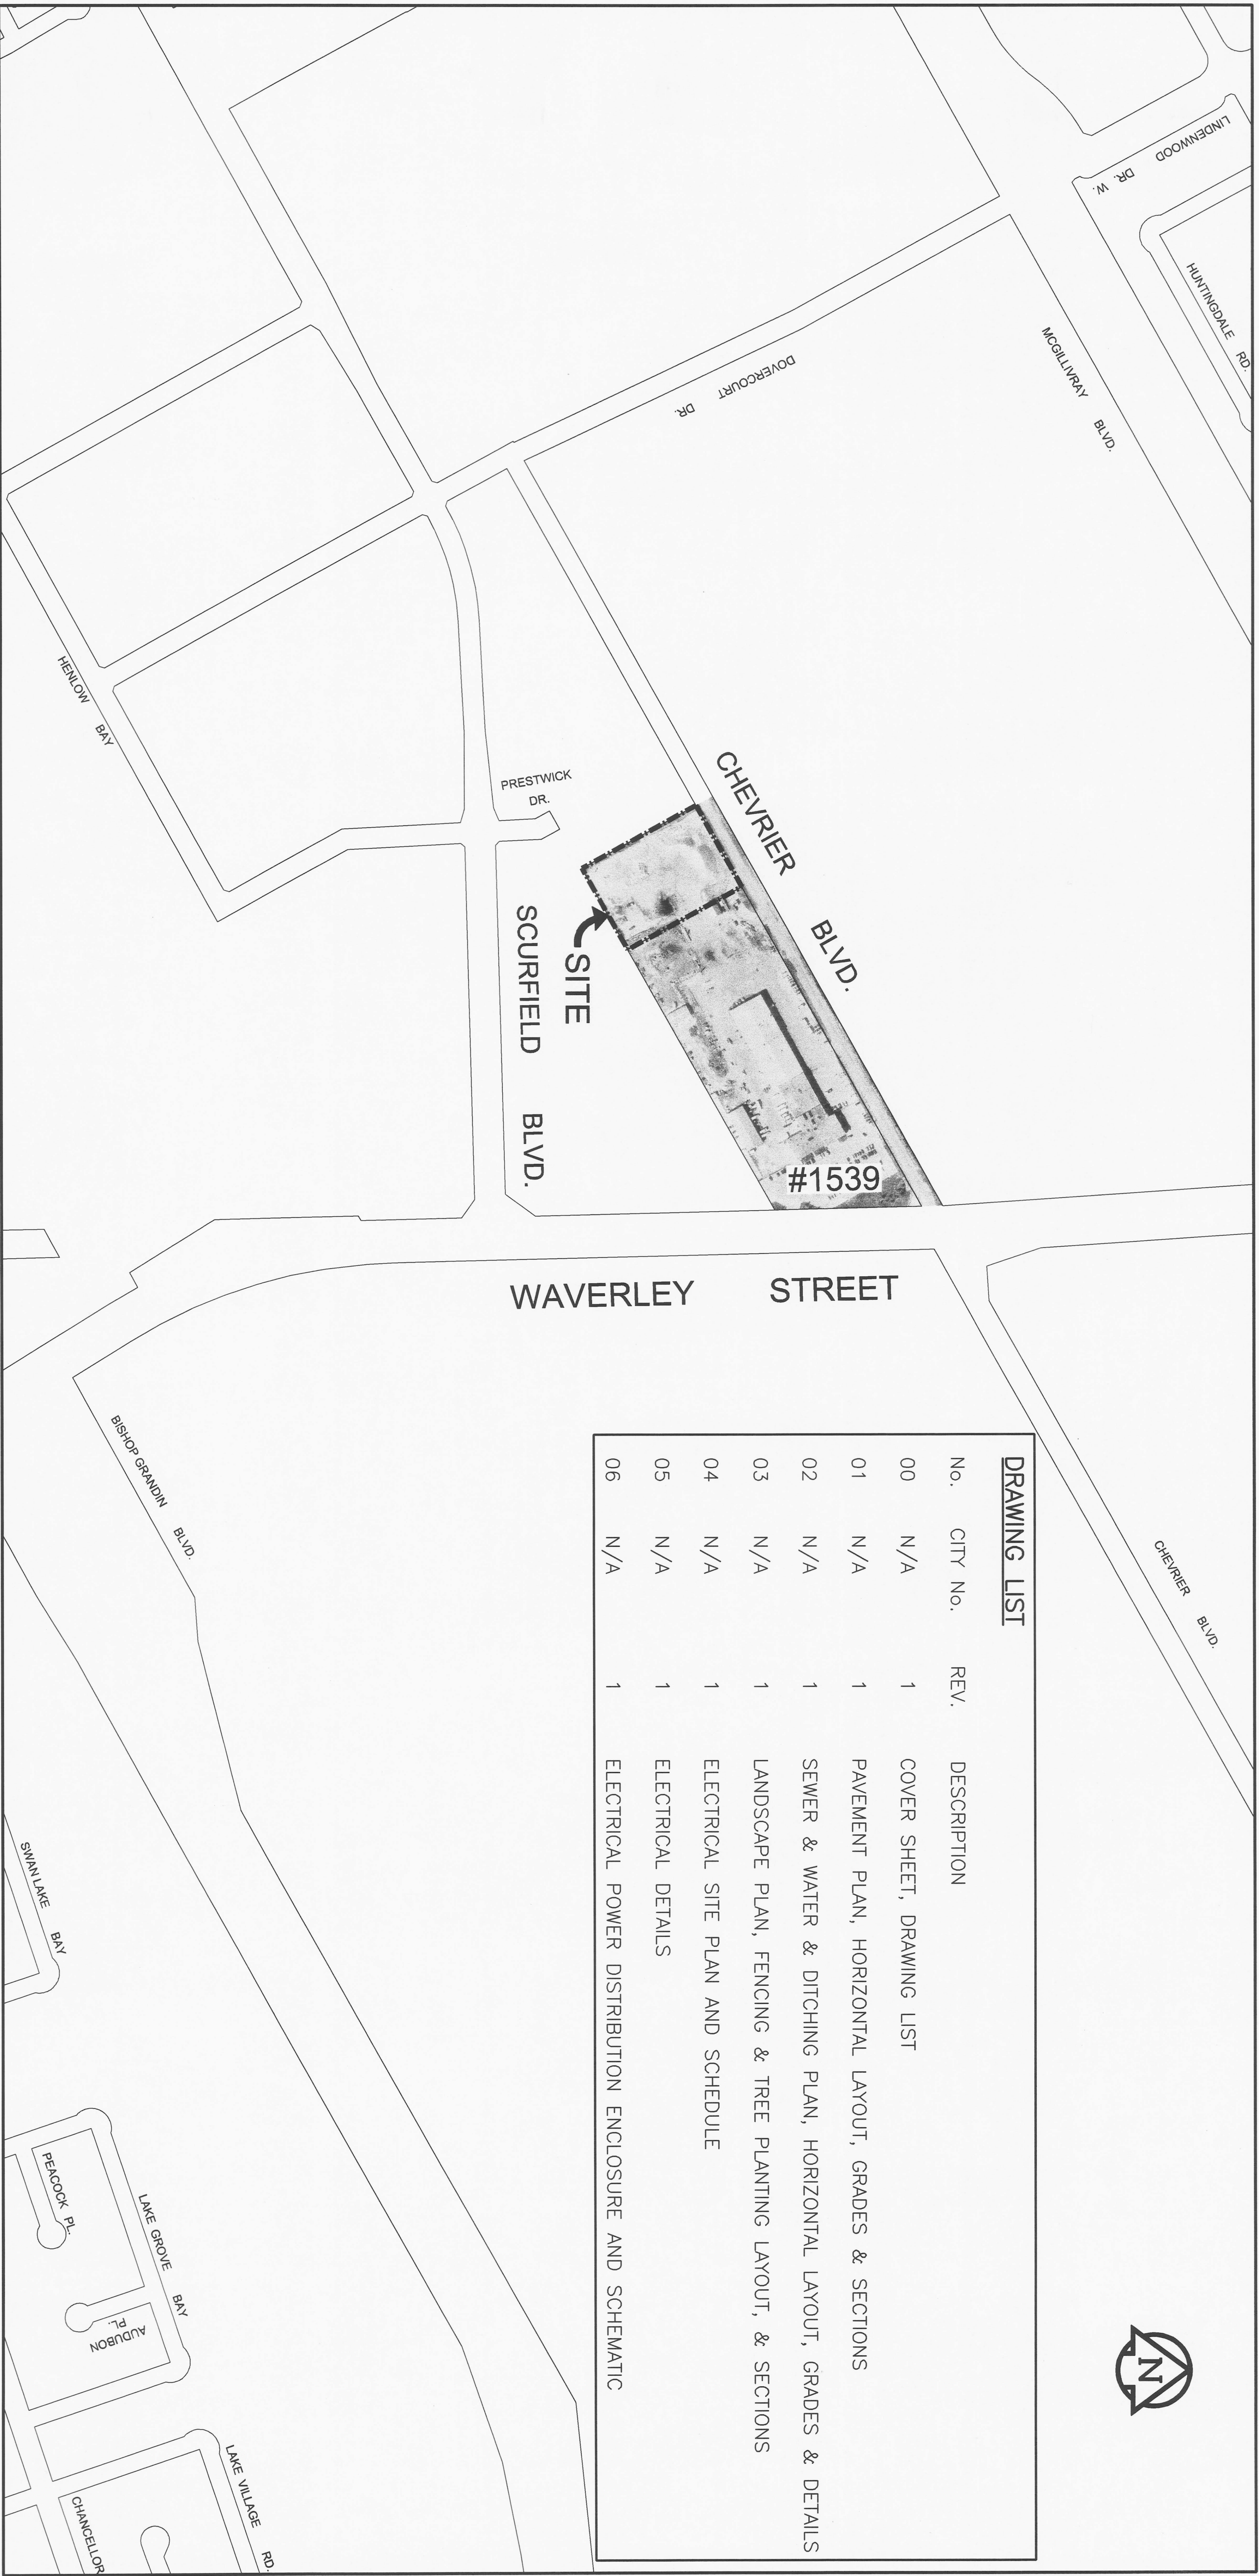

DRAWING LIST			
No.	CITY No.	REV.	DESCRIPTION
00	N/A	1	COVER SHEET, DRAWING LIST
01	N/A	1	PAVEMENT PLAN, HORIZONTAL LAYOUT, GRADES & SECTIONS
02	N/A	1	SEWER & WATER & DITCHING PLAN, HORIZONTAL LAYOUT, GRADES & DETAILS
03	N/A	1	LANDSCAPE PLAN, FENCING & TREE PLANTING LAYOUT, & SECTIONS
04	N/A	1	ELECTRICAL SITE PLAN AND SCHEDULE
05	N/A	1	ELECTRICAL DETAILS
06	N/A	1	ELECTRICAL POWER DISTRIBUTION ENCLOSURE AND SCHEMATIC

**UMA** **UMA Engineering Ltd.**  
 • Consulting • Engineering • Construction • Management Services

RELEASED FOR CONSTRUCTION BY:  
 STREETS PROJECT ENGINEER

DATE: April 22, 2004

**APREGM**  
 Certificate of Authorization  
 UMA Engineering Ltd.  
 No. 256 Expiry: April 30, 2004

COVER SHEET  
 AND LOCATION PLAN  
 CITY DRAWING NUMBER  
 N/A  
 CONSULTANT NO.  
 41-0103-0265-366-00