

REVISIONS		
NO.	DATE	PARTICULARS
1	05-03-23	EXPANDED TENDER
3	05-05-10	ADDENDUM ITEMS

NOTES

SMS ENGINEERING
 SMS Engineering Ltd., Consulting Engineers
 770 Brandon Street Winnipeg MB Canada R3M 0G5
 Telephone: 204.775.0291 Fax: 204.772.2153
 03-514-01 sms@smseng.com

PROFESSIONAL SEALS

APEGM
 Certificate of Authorization
 SMS Engineering Ltd.
 No. 166 Expiry: April 30, 2005

ORIGINAL CONTRACT DRAWING
 SIGNED AND SEALED BY
 B. D. LESKO, P. ENG.
 MARCH 23, 2005

THIS DRAWING MUST NOT BE SCALED.
 THE CONTRACTOR SHALL VERIFY ALL DIMENSIONS AND OTHER DATA ON SITE PRIOR TO COMMENCEMENT OF WORK. ANY DISCREPANCIES, ERRORS AND OMISSIONS ARE TO BE REPORTED TO THE ARCHITECT.
 DRAWING AND SPECIFICATIONS, AS INSTRUMENTS OF SERVICE, ARE THE PROPERTY OF SMS ENGINEERING LTD. NO REPRODUCTION MAY BE MADE WITHOUT THE PERMISSION OF THE ARCHITECT AND WHEN MADE, MUST BEAR HIS NAME. ALL PRINTS TO BE RETURNED TO THE ARCHITECT ON REQUEST.

200 -141 Bannatyne Avenue, Winnipeg, Manitoba R3B 0R3
 Telephone - 204.956.0938 Facsimile - 204.943.5597


PROJECT TITLE
RED RIVER COMMUNITY CENTRE REDEVELOPMENT

LOCATION
 WINNIPEG, MB
 293 MURRAY AVENUE

CLIENT
 THE CITY OF WINNIPEG

DRAWING TITLE
**Ground Floor Plan
 Mezzanine Floor Plan
 Lighting**

DRAWN RC/CM	APPROVED ALG	DRAWING E2.1
SCALE 1:75	DATE ISSUED 05-03-23	REVISION R-3
JOB NUMBER 03-514-01	DATE PLOTTED 05-03-23	

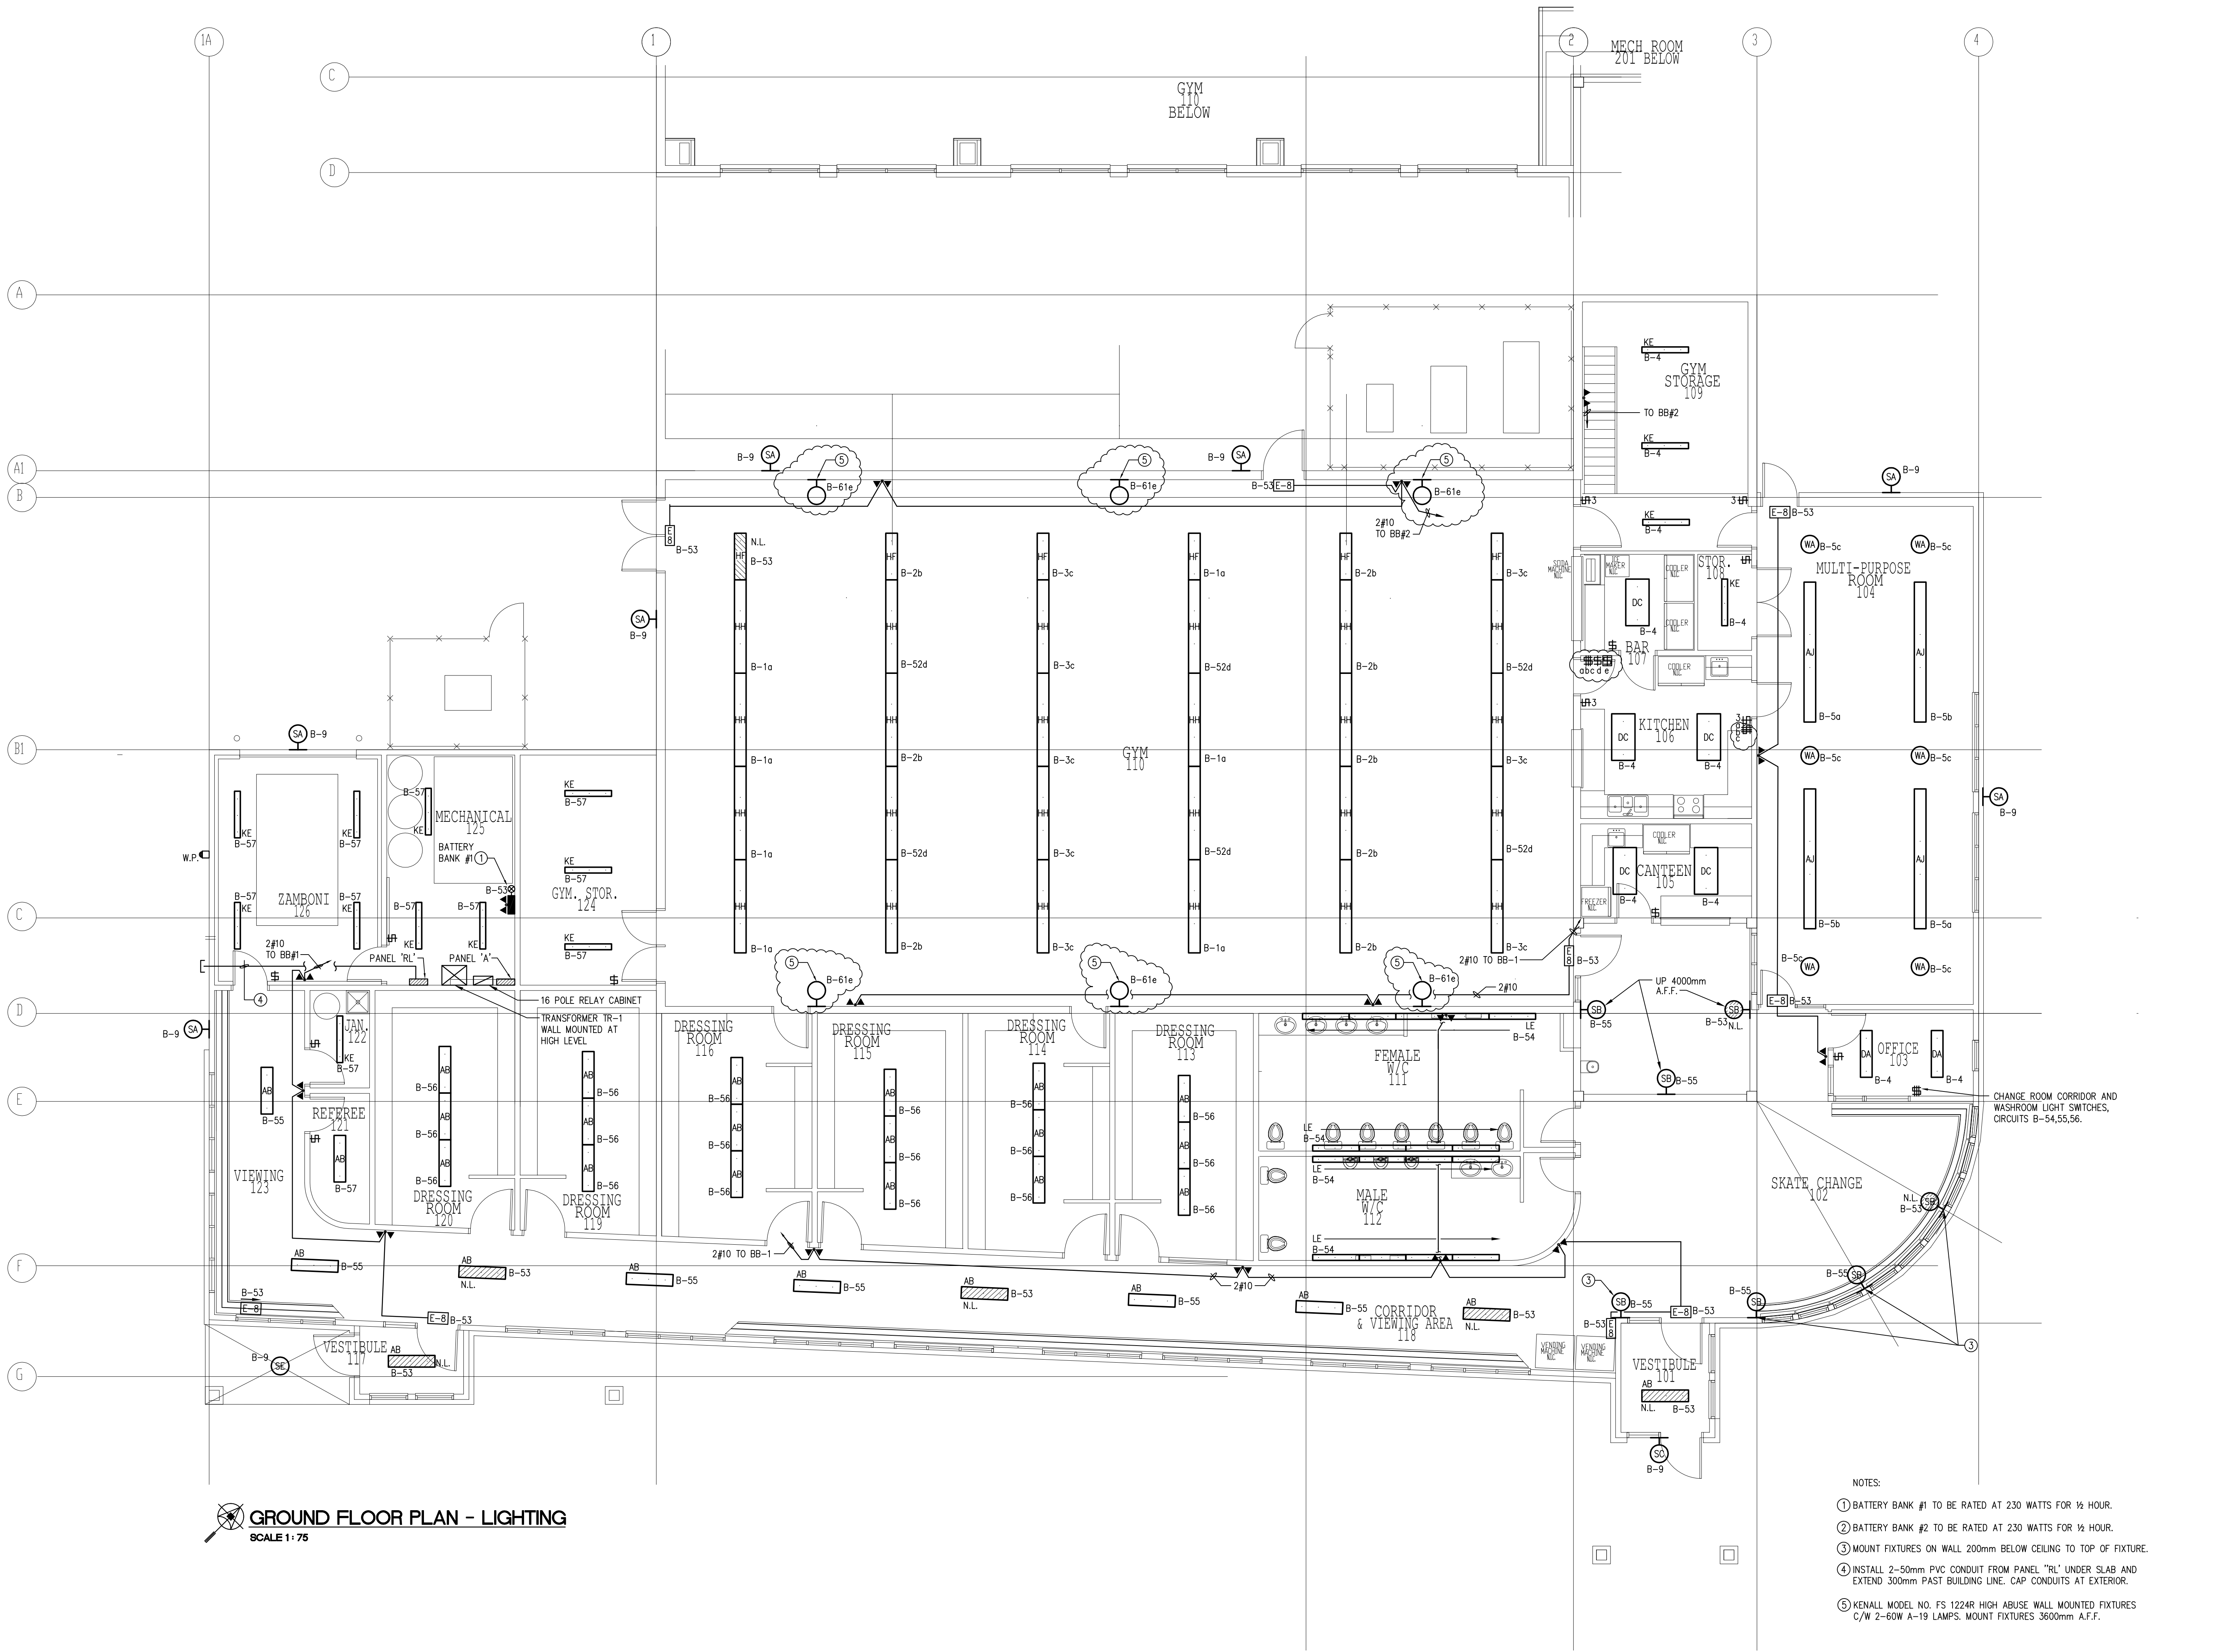

GROUND FLOOR PLAN - LIGHTING
 SCALE 1:75

- NOTES:
- BATTERY BANK #1 TO BE RATED AT 230 WATTS FOR 1/2 HOUR.
 - BATTERY BANK #2 TO BE RATED AT 230 WATTS FOR 1/2 HOUR.
 - MOUNT FIXTURES ON WALL 200mm BELOW CEILING TO TOP OF FIXTURE.
 - INSTALL 2-50mm PVC CONDUIT FROM PANEL "RL" UNDER SLAB AND EXTEND 300mm PAST BUILDING LINE. CAP CONDUITS AT EXTERIOR.
 - KENALL MODEL NO. FS 1224R HIGH ABUSE WALL MOUNTED FIXTURES C/W 2-60W A-19 LAMPS. MOUNT FIXTURES 3600mm A.F.F.