


**SITE FURNISHINGS EQUIPMENT SCHEDULE:**

NOTE: THE CONTRACTOR IS TO SUPPLY AND INSTALL THE FOLLOWING SITE FURNISHINGS, TO BE FIELD LOCATED BY OWNER:

1. SIX (6) CONCRETE PICNIC TABLES
2. SIX (6) CONCRETE TRASH CONTAINERS
3. FOUR (4) CONCRETE FLOWER PLANTERS, C/W MIXED TOPSOIL.
4. TWO (2) CONCRETE CIGARETTE SNUFFERS

2 TYPICAL SHRUB BED SECTION  
L6 Scale: 1:10

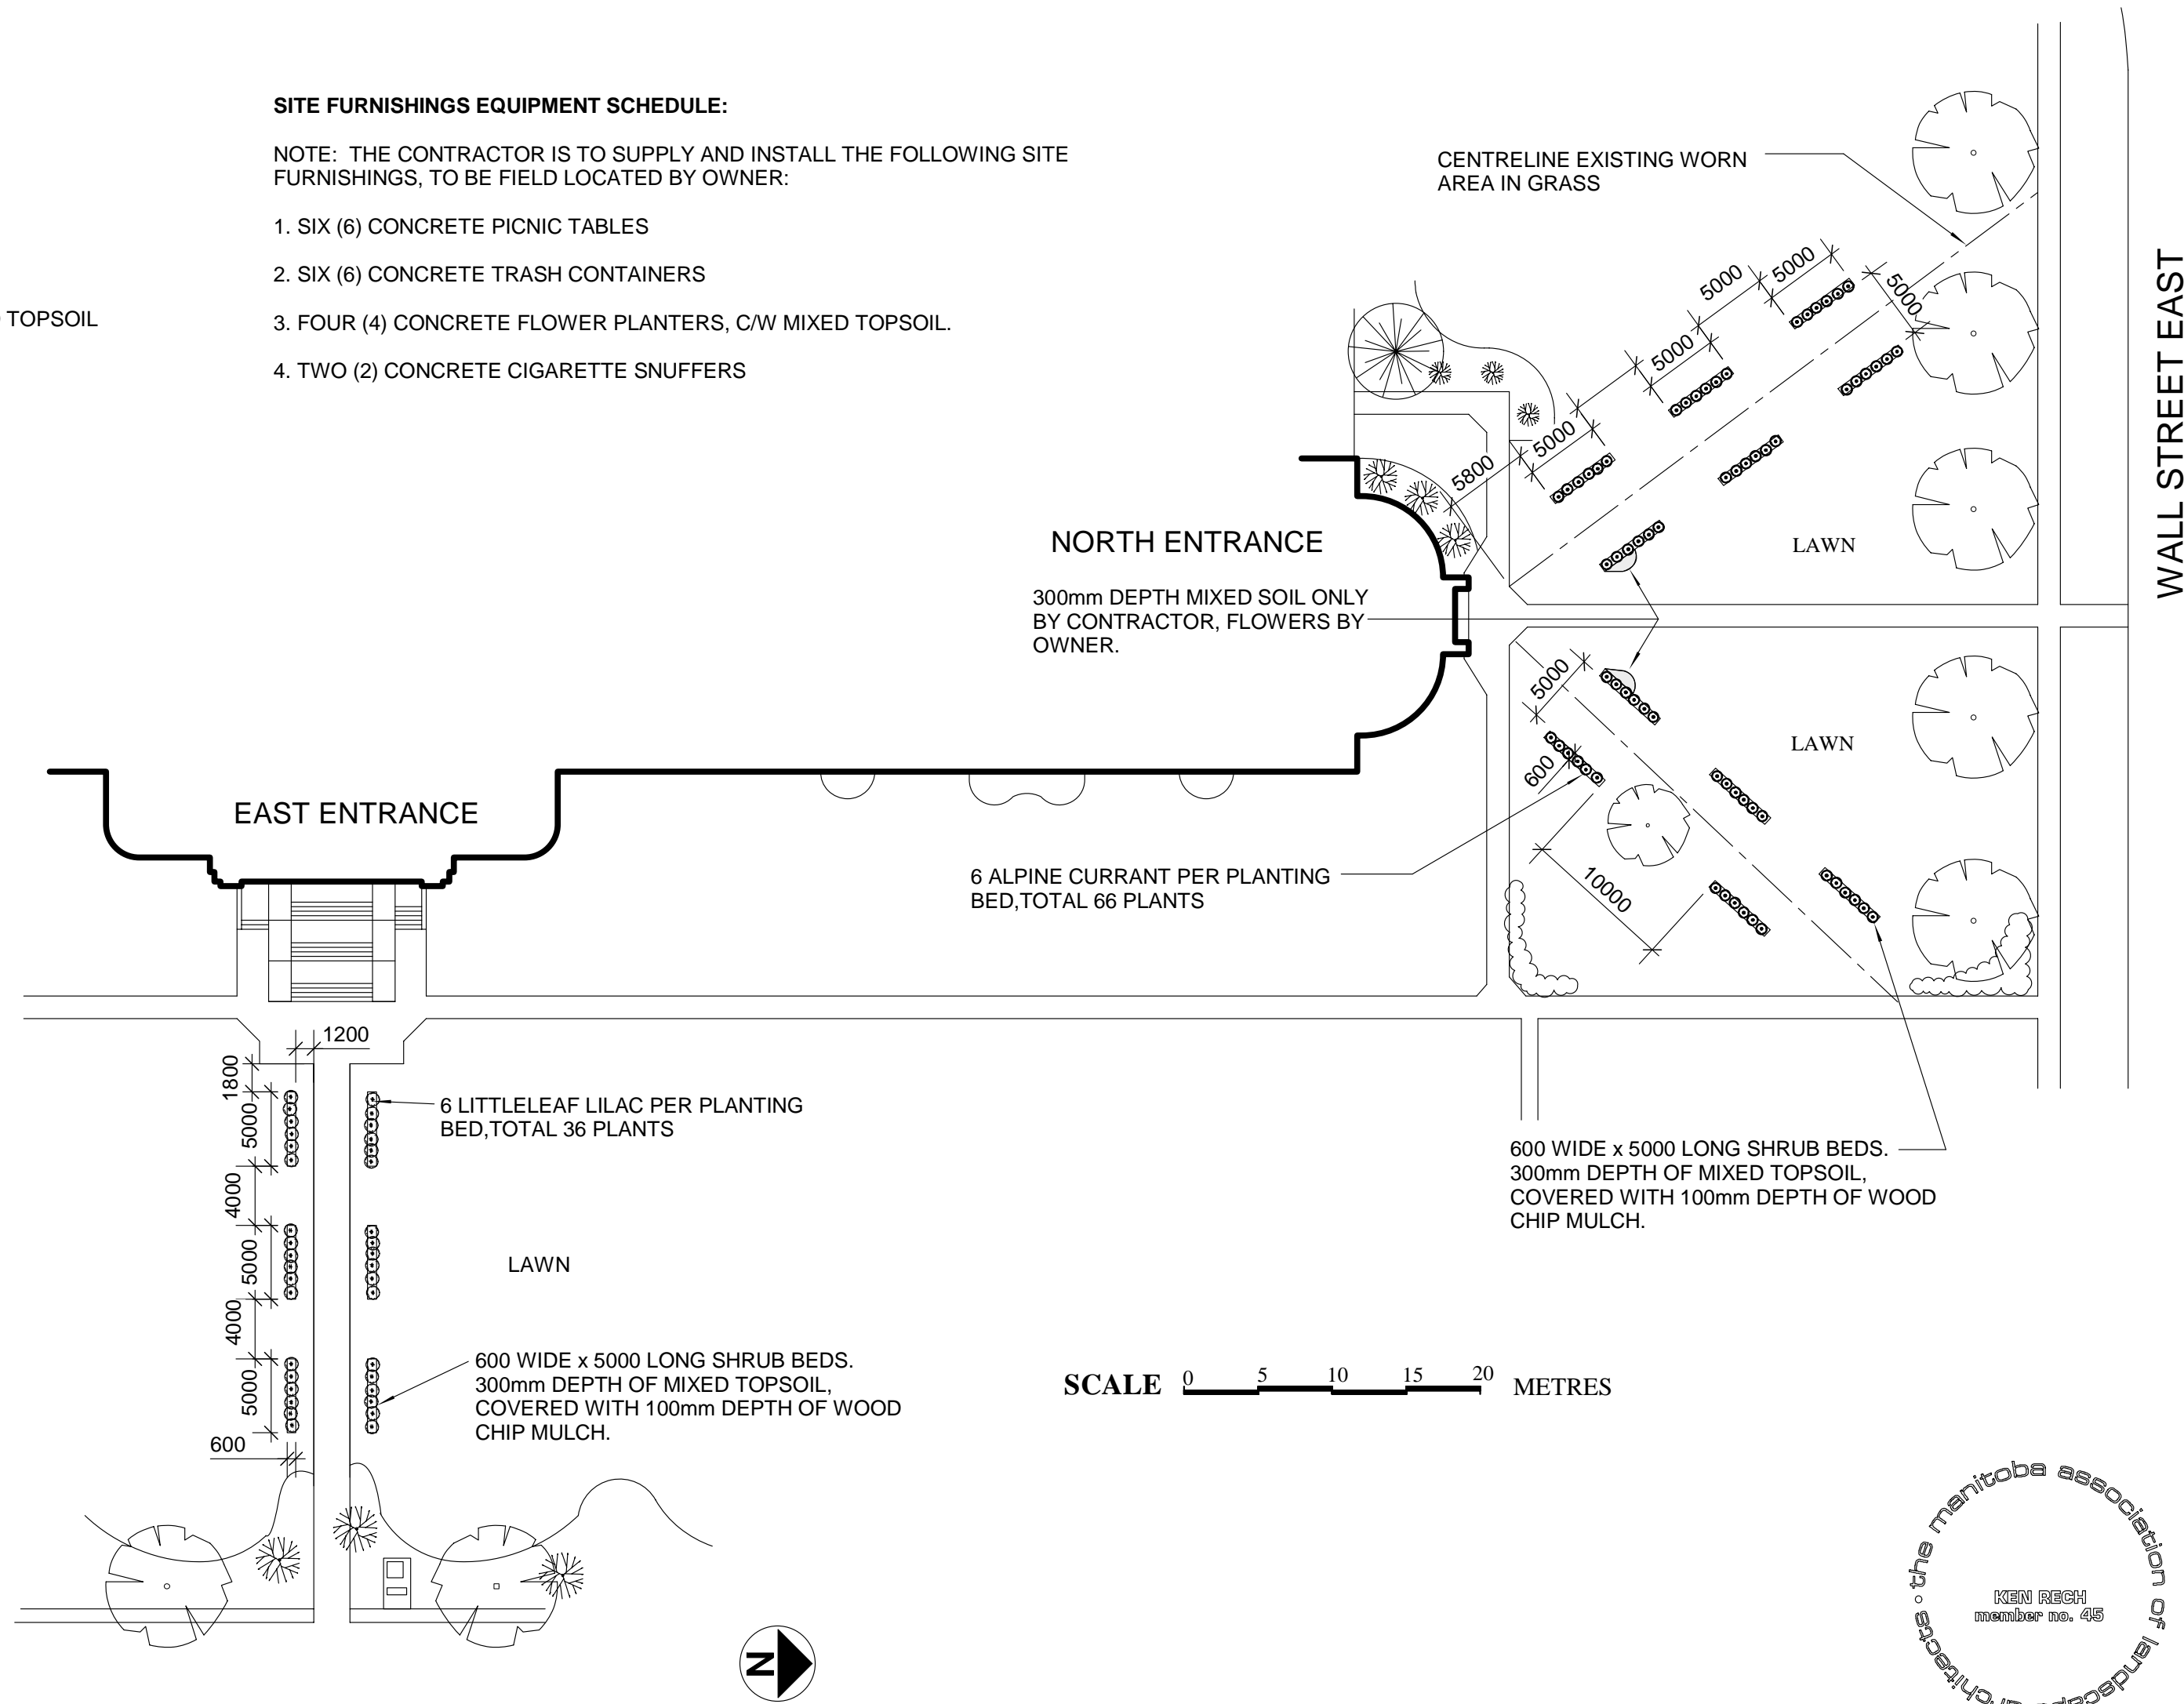

1 LANDSCAPE PLAN  
L6 Scale: 1:400

SCALE 0 5 10 15 20 METRES



<b>PROJECT TITLE</b> TEC VOC SCHOOL	<b>DRAWING TITLE</b> SITE PLAN	<b>SCALE</b> AS NOTED	<b>DRAWN BY</b> K. RECH	<b>SHEET NO.</b> L-6
<b>KEN RECH LANDSCAPE ARCHITECTS INC</b> 1480 Wellington Crescent Winnipeg Manitoba Fax 489-6852 R3N 0B3 Tel(204) 489-6616		<b>DATE</b> APRIL 19/04	<b>FILE NO.</b> 04-01-1	