




**THE CITY OF WINNIPEG
PUBLIC WORKS DEPARTMENT
ENGINEERING DIVISION**

**SAND and SALT STORAGE FACILITY
at 1539 WAVERLEY STREET
YARD WORKS
BID OPPORTUNITY No. 187-2004**

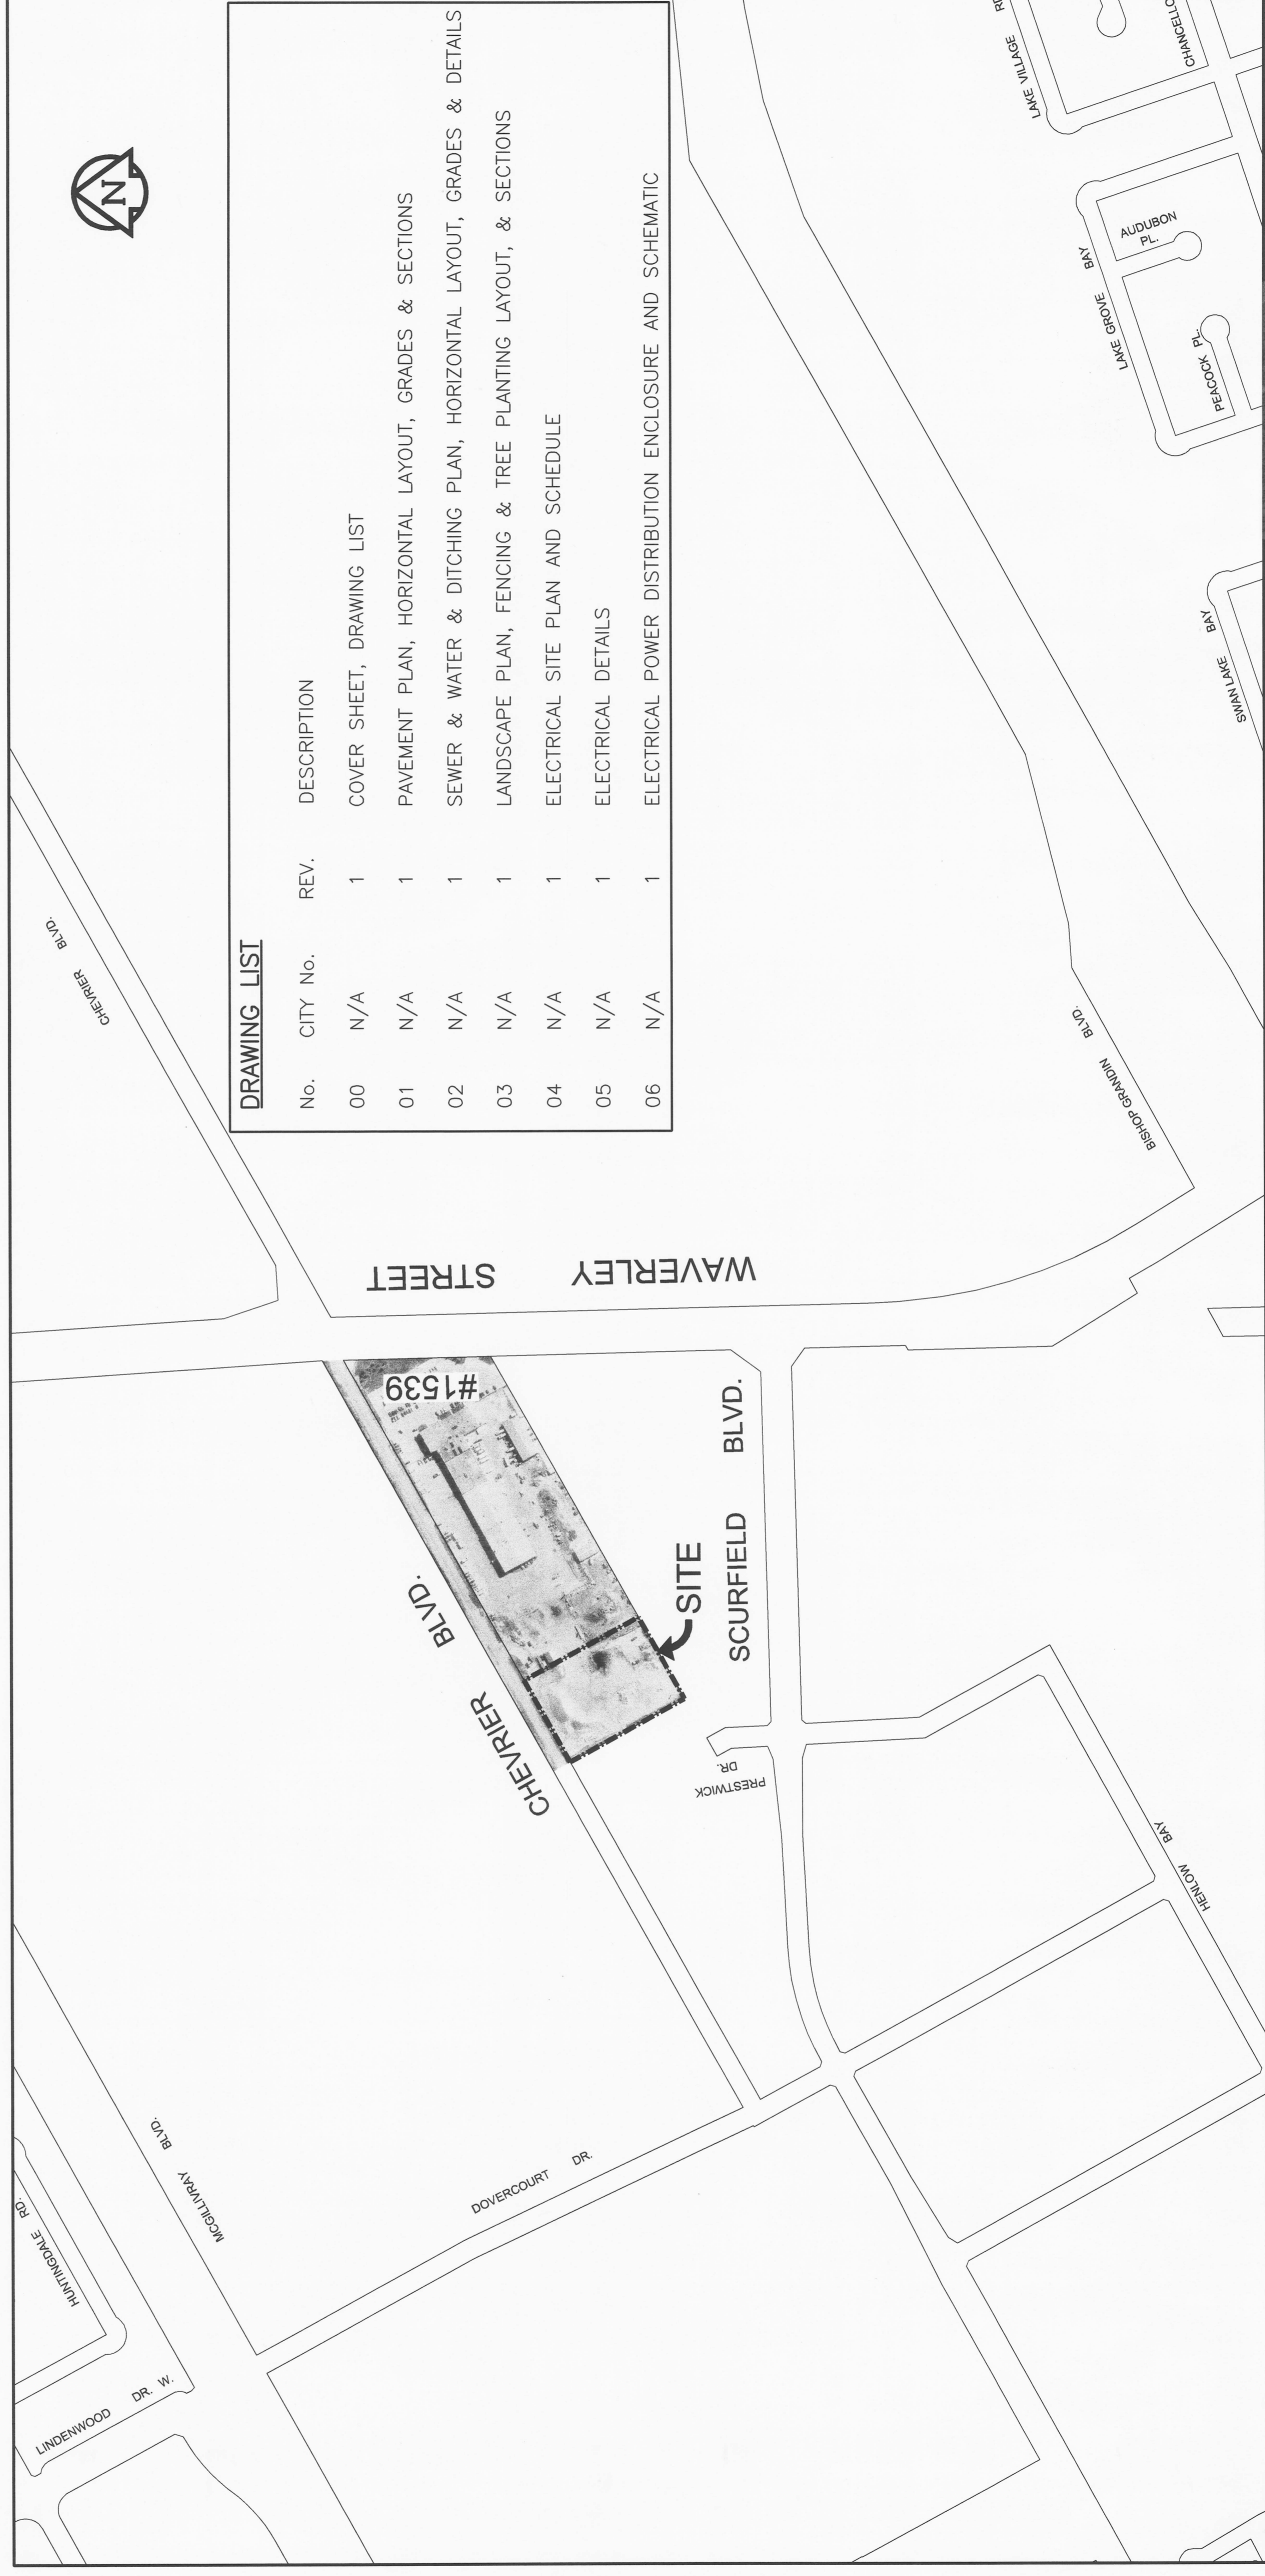

DRAWING LIST

No.	CITY No.	REV.	DESCRIPTION
00	N/A	1	COVER SHEET, DRAWING LIST
01	N/A	1	PAVEMENT PLAN, HORIZONTAL LAYOUT, GRADES & SECTIONS
02	N/A	1	SEWER & WATER & DITCHING PLAN, HORIZONTAL LAYOUT, GRADES & DETAILS
03	N/A	1	LANDSCAPE PLAN, FENCING & TREE PLANTING LAYOUT, & SECTIONS
04	N/A	1	ELECTRICAL SITE PLAN AND SCHEDULE
05	N/A	1	ELECTRICAL DETAILS
06	N/A	1	ELECTRICAL POWER DISTRIBUTION ENCLOSURE AND SCHEMATIC

UMA Engineering Ltd.
• Consulting • Engineering • Construction • Management Services

RELEASED FOR CONSTRUCTION BY:
Stacy Bedard
STREETS PROJECT ENGINEER

April 22, 2004
DATE

**NOT IN CONTRACT
FOR REFERENCE
PURPOSES ONLY**

PEGM
Certificate of Authorization
UMA Engineering Ltd.
No. 256 Expiry: April 30, 2004

COVER SHEET
AND LOCATION PLAN
CITY DRAWING NUMBER
N/A
CONSULTANT NO.
41-0103-0265-366-00