



1466 WILLIAM AVE.


### CODE

- 1. PENTHOUSE
- 2. CHIMNEY
- 3. AIR COND. UNITS
- 4. SIGN SUPPORT
- 5. VENTILATOR
- 6. VENT PIPE
- 7. DRAIN
- 8. SKYLIGHT
- 9. EAVESTROUGH
- 10. FIRE WALL
- 11. TANK
- 12. STUB COLUMN
- 13. GRAVEL STOP
- 14. HATCH
- 15. SCUPPER
- 16. PITCH BOXES
- 17. ANTENNA
- 18. GUYWIRE
- 19.
- 20.

PARAPET



AREA OF WORK "C"

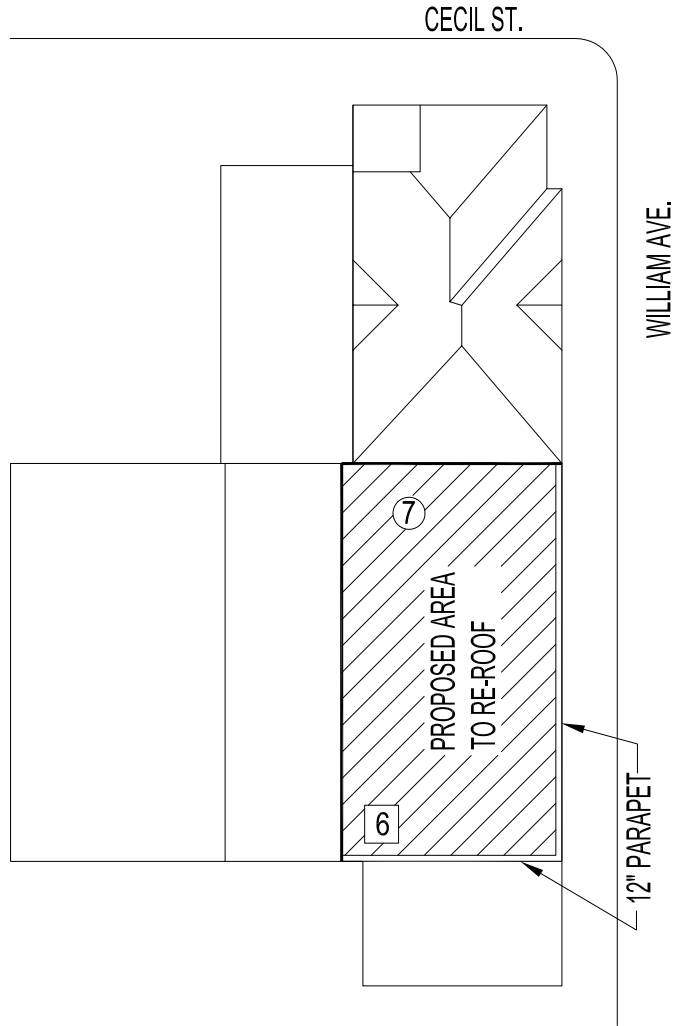

CITY OF WINNIPEG  
 PLANNING, PROPERTY &  
 DEVELOPMENT DEPARTMENT  
 CIVIC ACCOMMODATIONS DIVISION  
 300 - 65 GARRY ST. R3C 4K4

PROJECT

SHEET TITLE **ROOF PLAN**

DRAWN BY

CHECKED BY

APPROVED BY

DATE

SCALE

PROJECT/SHEET NO.

**DNJ**

**LOR**

**2004.08.18**

**1/32"=1'-0"**

**2004-155/A-1**