




NOTES:

- SITE LOCATED OFF HEATHERDALE ROAD APPROXIMATELY 1.0km NORTH OF PR 213 (GARVEN ROAD)
- EXACT LOCATION OF EXISTING CABLE IS UNKNOWN
- ALARM SERVICE LINE TO BE SUPPLIED, INSTALLED AND CONNECTED (COMPUSCAN)
- ASSUMED TOTAL LOAD AT SCALE HOUSE OF 30 AMP AT 120/240 VAC.
- ONE 30 AMP, 2-POLE CIRCUIT BREAKER FEEDING POWER CABLE TO BE INSTALLED AT OFFICE BLDG.
- 100BASE-TX/FX TO FIBER MEDIA CONVERTERS TO BE INSTALLED AT BOTH ENDS OF FIBER CABLE.
- 100BASE-TX/FX TO FIBER MEDIA CONVERTERS TO BE INSTALLED IN ITS OWN ENCLOSURES.

HEATHERDALE ROAD
GOVERNMENT ROAD ALLOWANCE 30.175

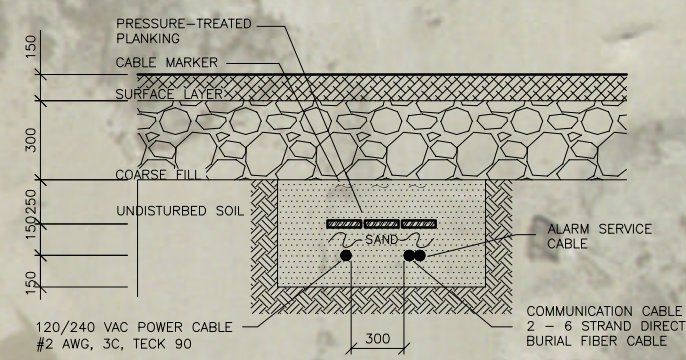

1 DIRECT-BURIED CABLES TRENCH DETAIL
NTS

**PRELIMINARY
DRAWING ONLY**
NOT TO BE USED FOR CONSTRUCTION
(REMOVE WHEN DRAWING IS FINAL)



B.M. ELEV.			
A	ISSUED FOR BIDDING	04.09.13	SAM
NO.	REVISIONS	DATE	BY

WARDROP Engineering Inc.	
DESIGNED BY bgd	CHECKED BY
DRAWN BY bgd	APPROVED BY
HOR. SCALE: AS NOTED	RELEASED FOR CONSTRUCTION
VERTICAL:	DATE
	04.07.14

CONSULTANT DRAWING NO. 0429020100

THE CITY OF WINNIPEG GLACIAL SAND AND GRAVEL	CITY DRAWING NUMBER
	SHEET 1 OF 1
SITE PLAN	C0101