




1 CENTRE PLAZA ENCLOSURE - REFLECTED CEILING PLAN
1 : 100

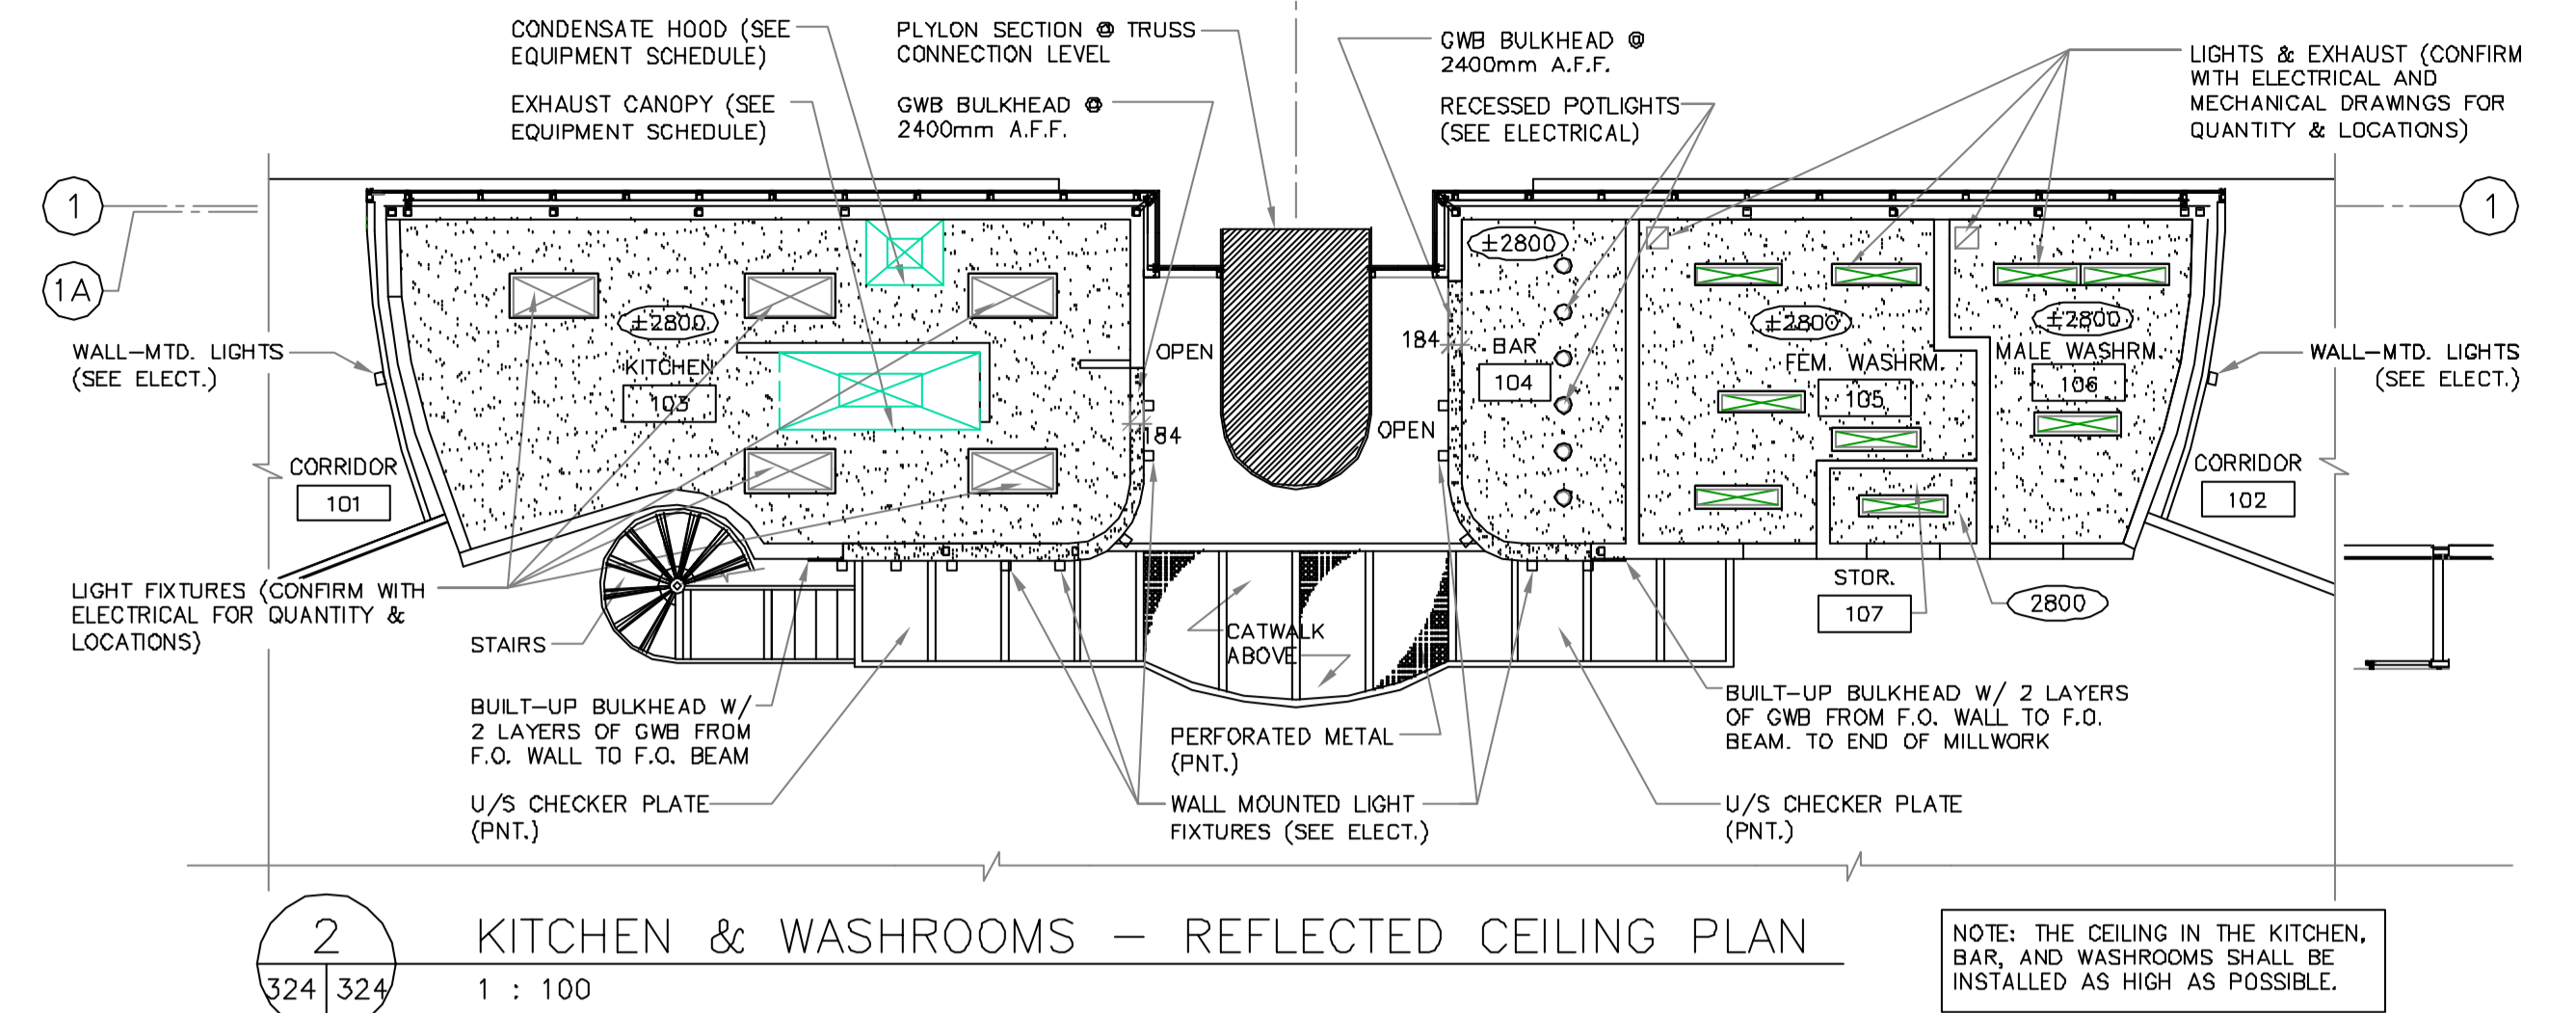


2 KITCHEN & WASHROOMS - REFLECTED CEILING PLAN
1 : 100

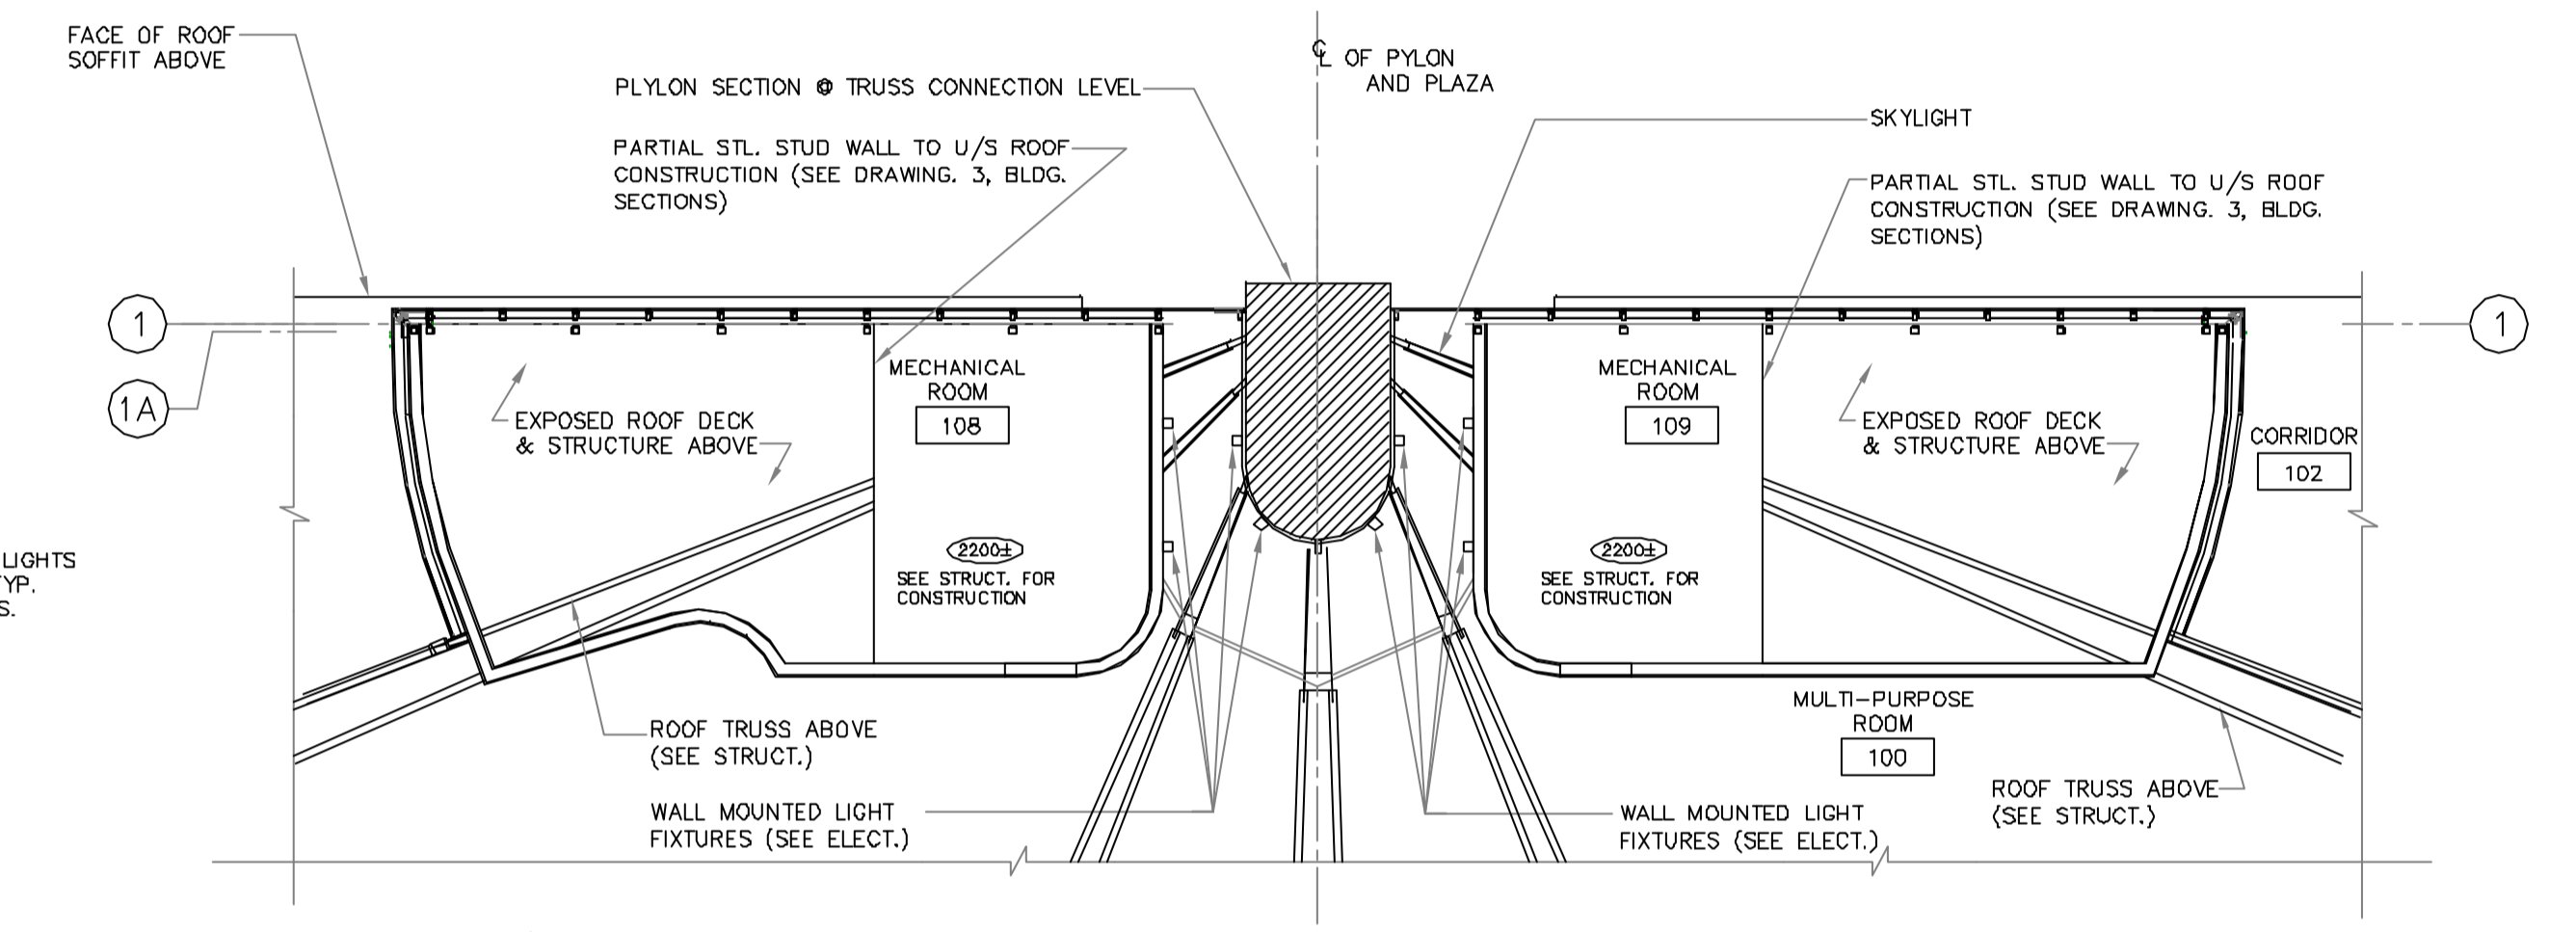


3 MECHANICAL ROOMS - REFLECTED CEILING PLAN
1 : 100

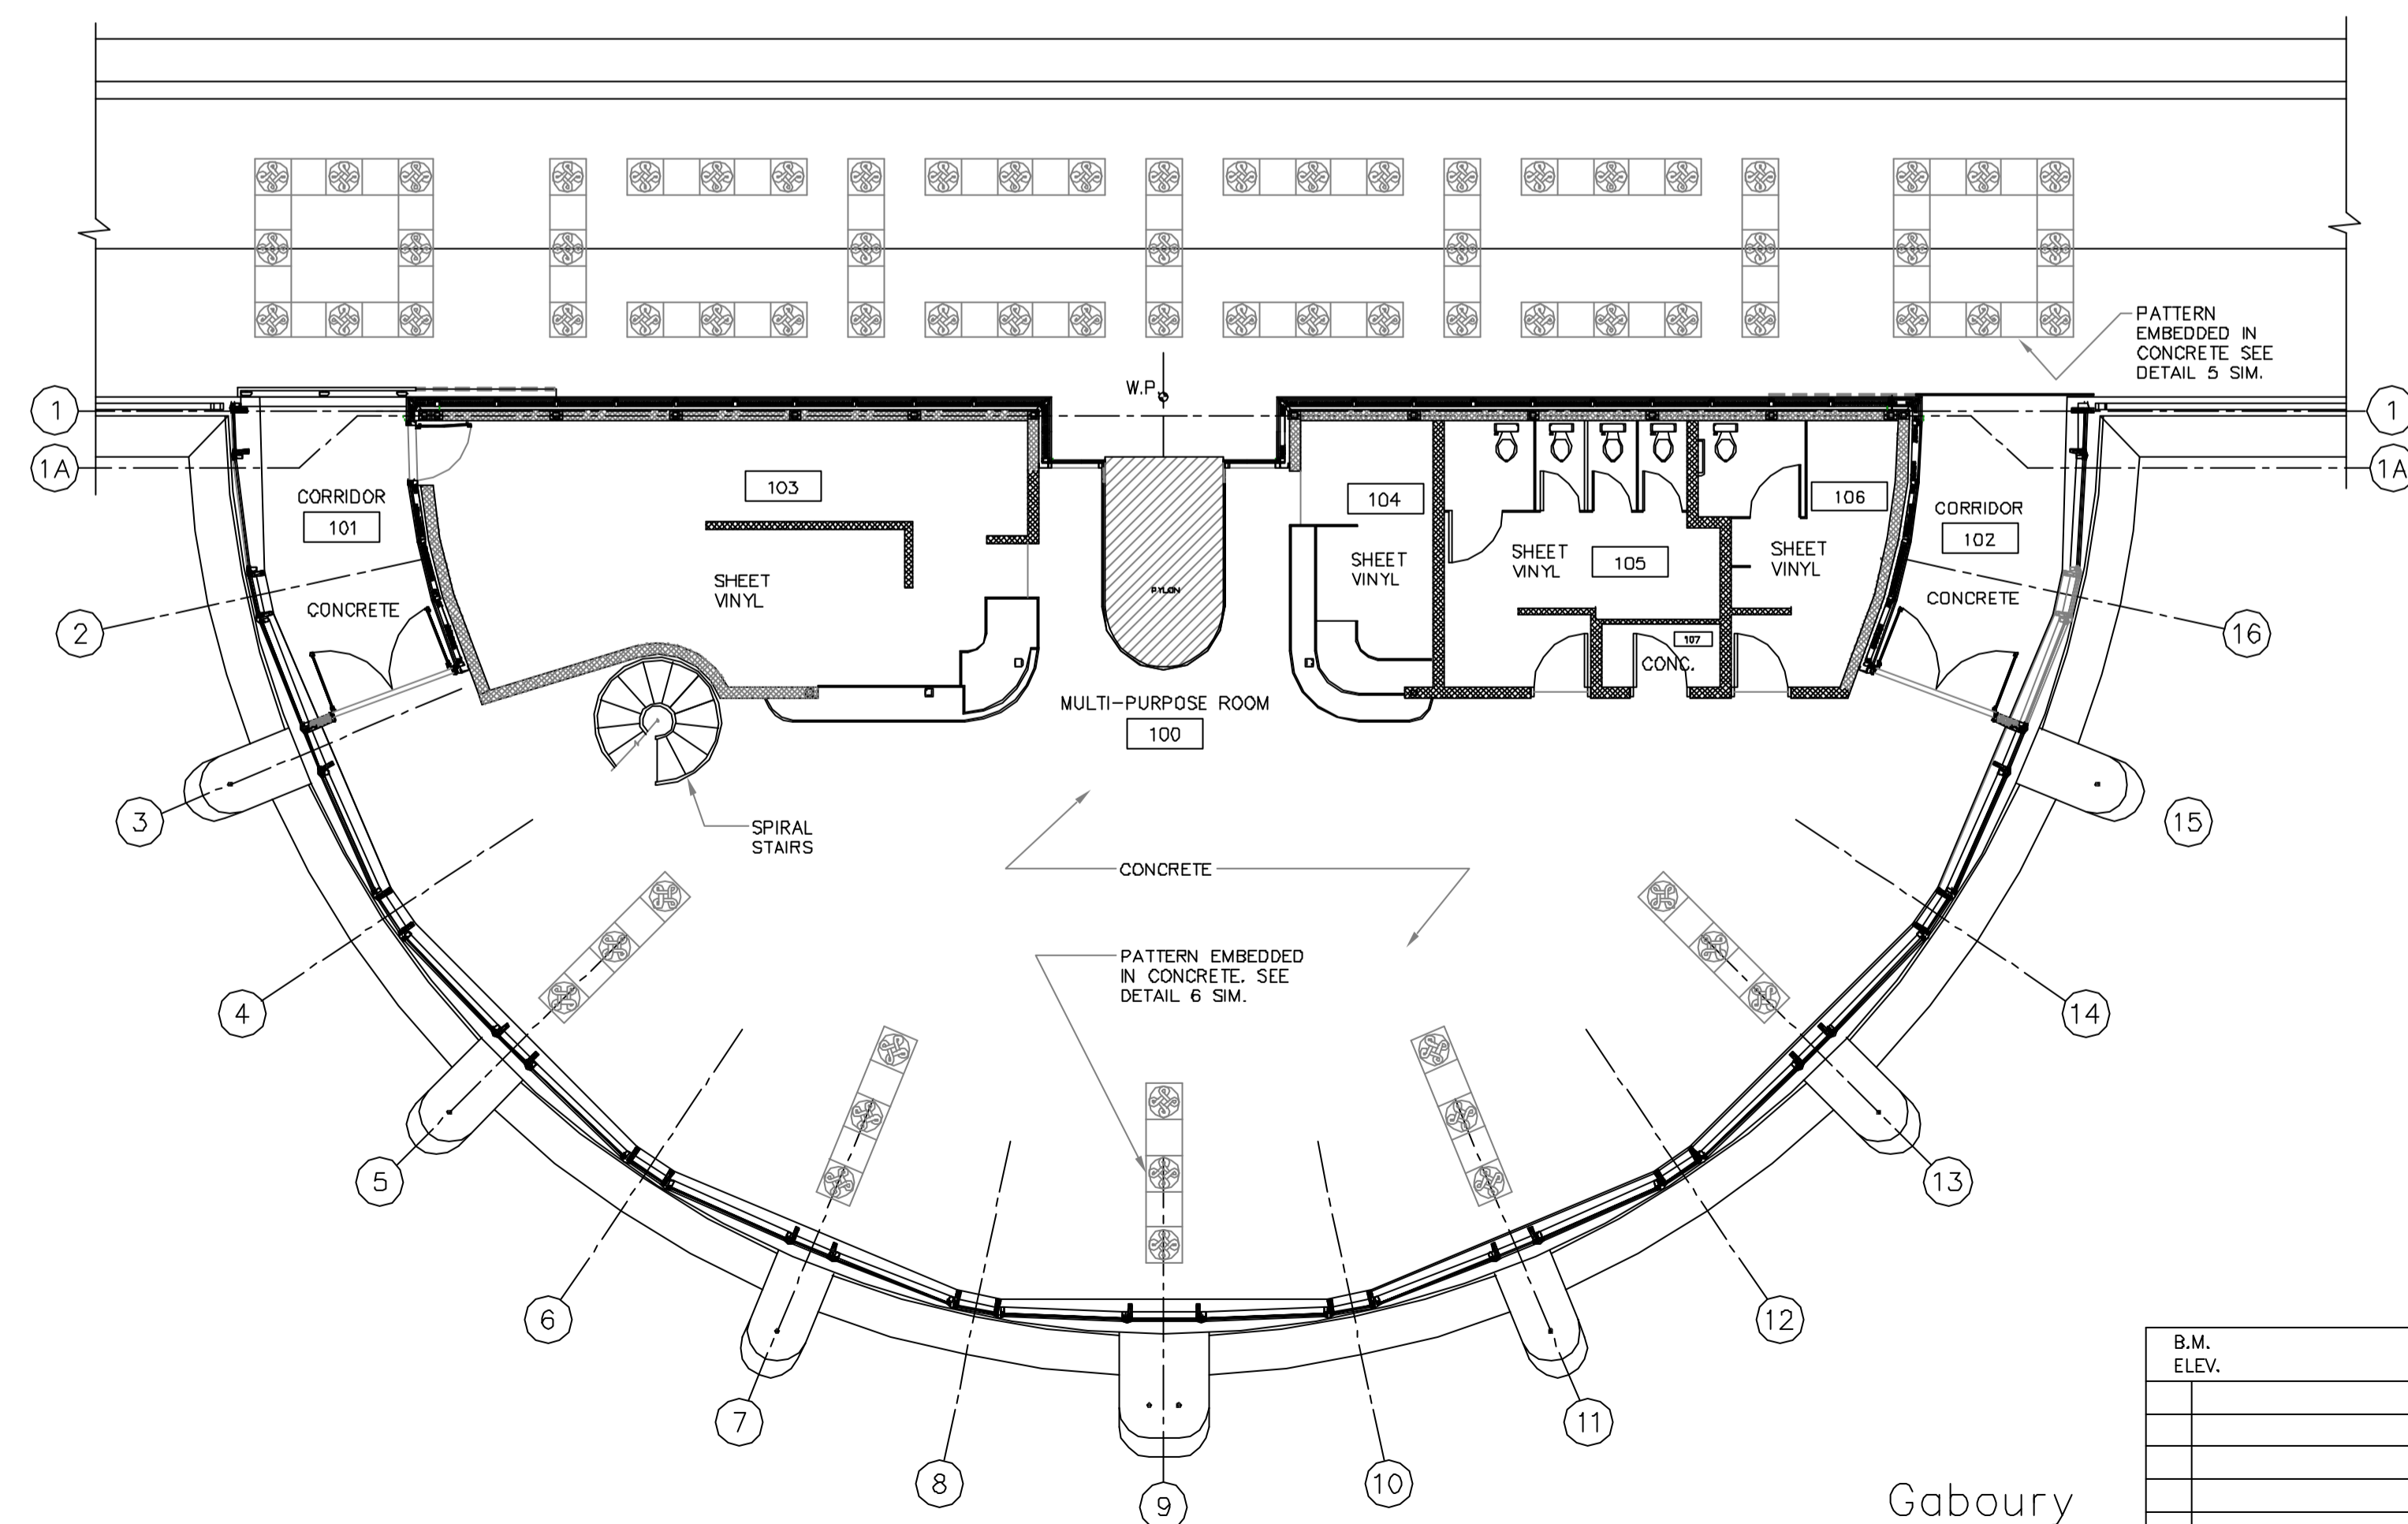

4 CENTRE PLAZA ENCLOSURE - FLOOR FINISH PLAN
1 : 100

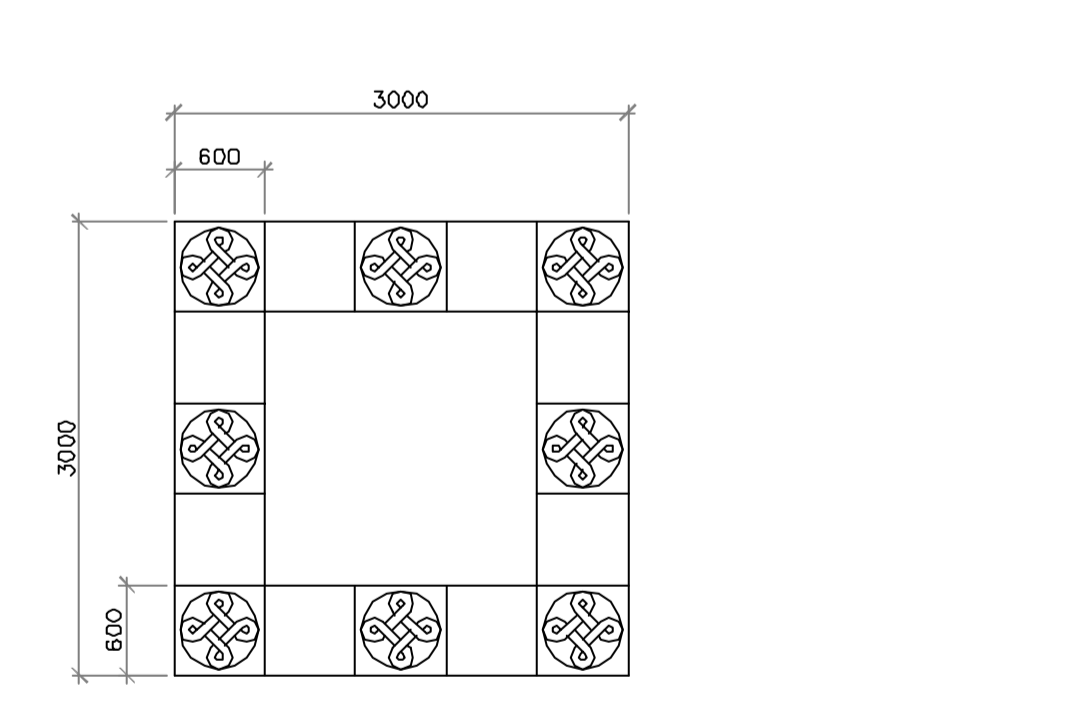

5 EXAMPLE OF CONCRETE MEDALLION
1 : 50

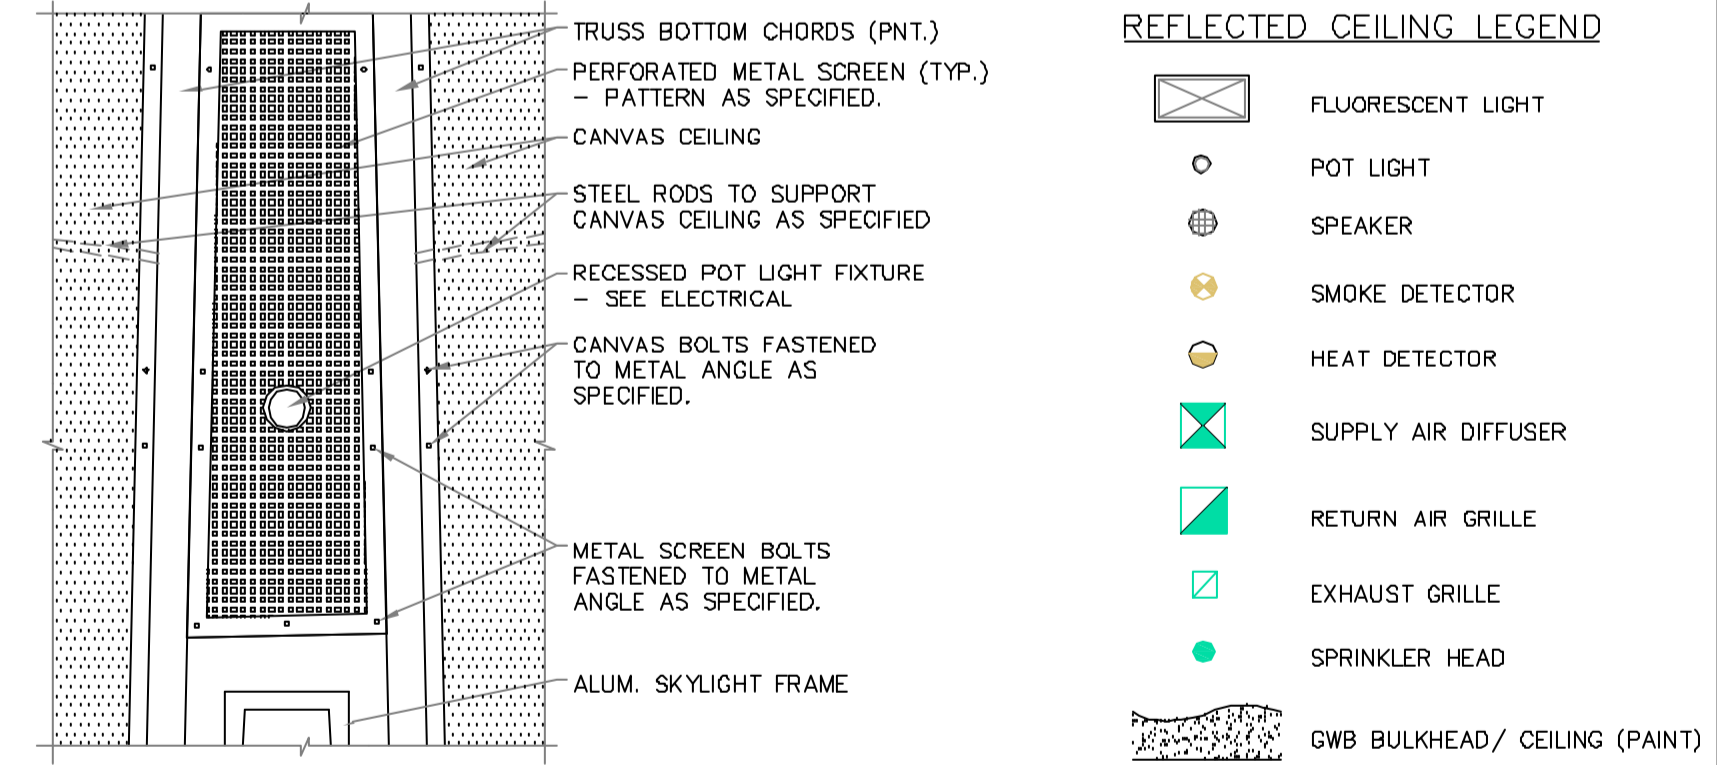

6 UNDER TRUSS DETAIL
1 : 20

- REFLECTED CEILING LEGEND**
- FLUORESCENT LIGHT
 - POT LIGHT
 - SPEAKER
 - SMOKE DETECTOR
 - HEAT DETECTOR
 - SUPPLY AIR DIFFUSER
 - RETURN AIR GRILLE
 - EXHAUST GRILLE
 - SPRINKLER HEAD
 - GWB BULKHEAD/ CEILING (PAINT)
 - 2800 HEIGHT, A.F.F. TO U/S CEILING
 - CANVAS CEILING
 - PERFORATED METAL SCREEN
 - ALUMINUM BUG SCREEN

ISSUED FOR INFORMATION ONLY
NOT TO BE USED FOR CONSTRUCTION

Gaboury
Préfontaine
Perry
architect.e.s

B.M. ELEV.	F.B.	WARDROP Engineering Inc.		THE CITY OF WINNIPEG PUBLIC WORKS DEPARTMENT ENGINEERING DIVISION	
		DESIGNED BY E.J.G. Y.L.	CHECKED BY E.J.G.	PROVENCHER PAIRED BRIDGES PROJECT	
		DRAWN BY C.B. H.V. Y.L.	APPROVED BY R.V.G.	PEDESTRIAN BRIDGE	
1 ISSUED FOR CONSTRUCTION	03.08.11	HOR. SCALE: AS NOTED		CONSULTANT DRAWING NO. 010007-13-01	CITY DRAWING NUMBER
0 ISSUED FOR PCN 25	03.07.24	VERTICAL: AS NOTED			SHEET OF
NO. REVISIONS	DATE	DATE	ACCEPTED BY		324
			B. BRENSPANGER P. ENG. BRIDGE DESIGN AND PROJECTS ENGINEER		

CENTRE PLAZA ENCLOSURE
REFLECTED CEILING PLANS
AND FLOOR FINISH PLAN