



**MAIN FLOOR FRAMING PLAN**  
1:100  
ISSUED FOR FLOOR PENETRATION INFO ONLY

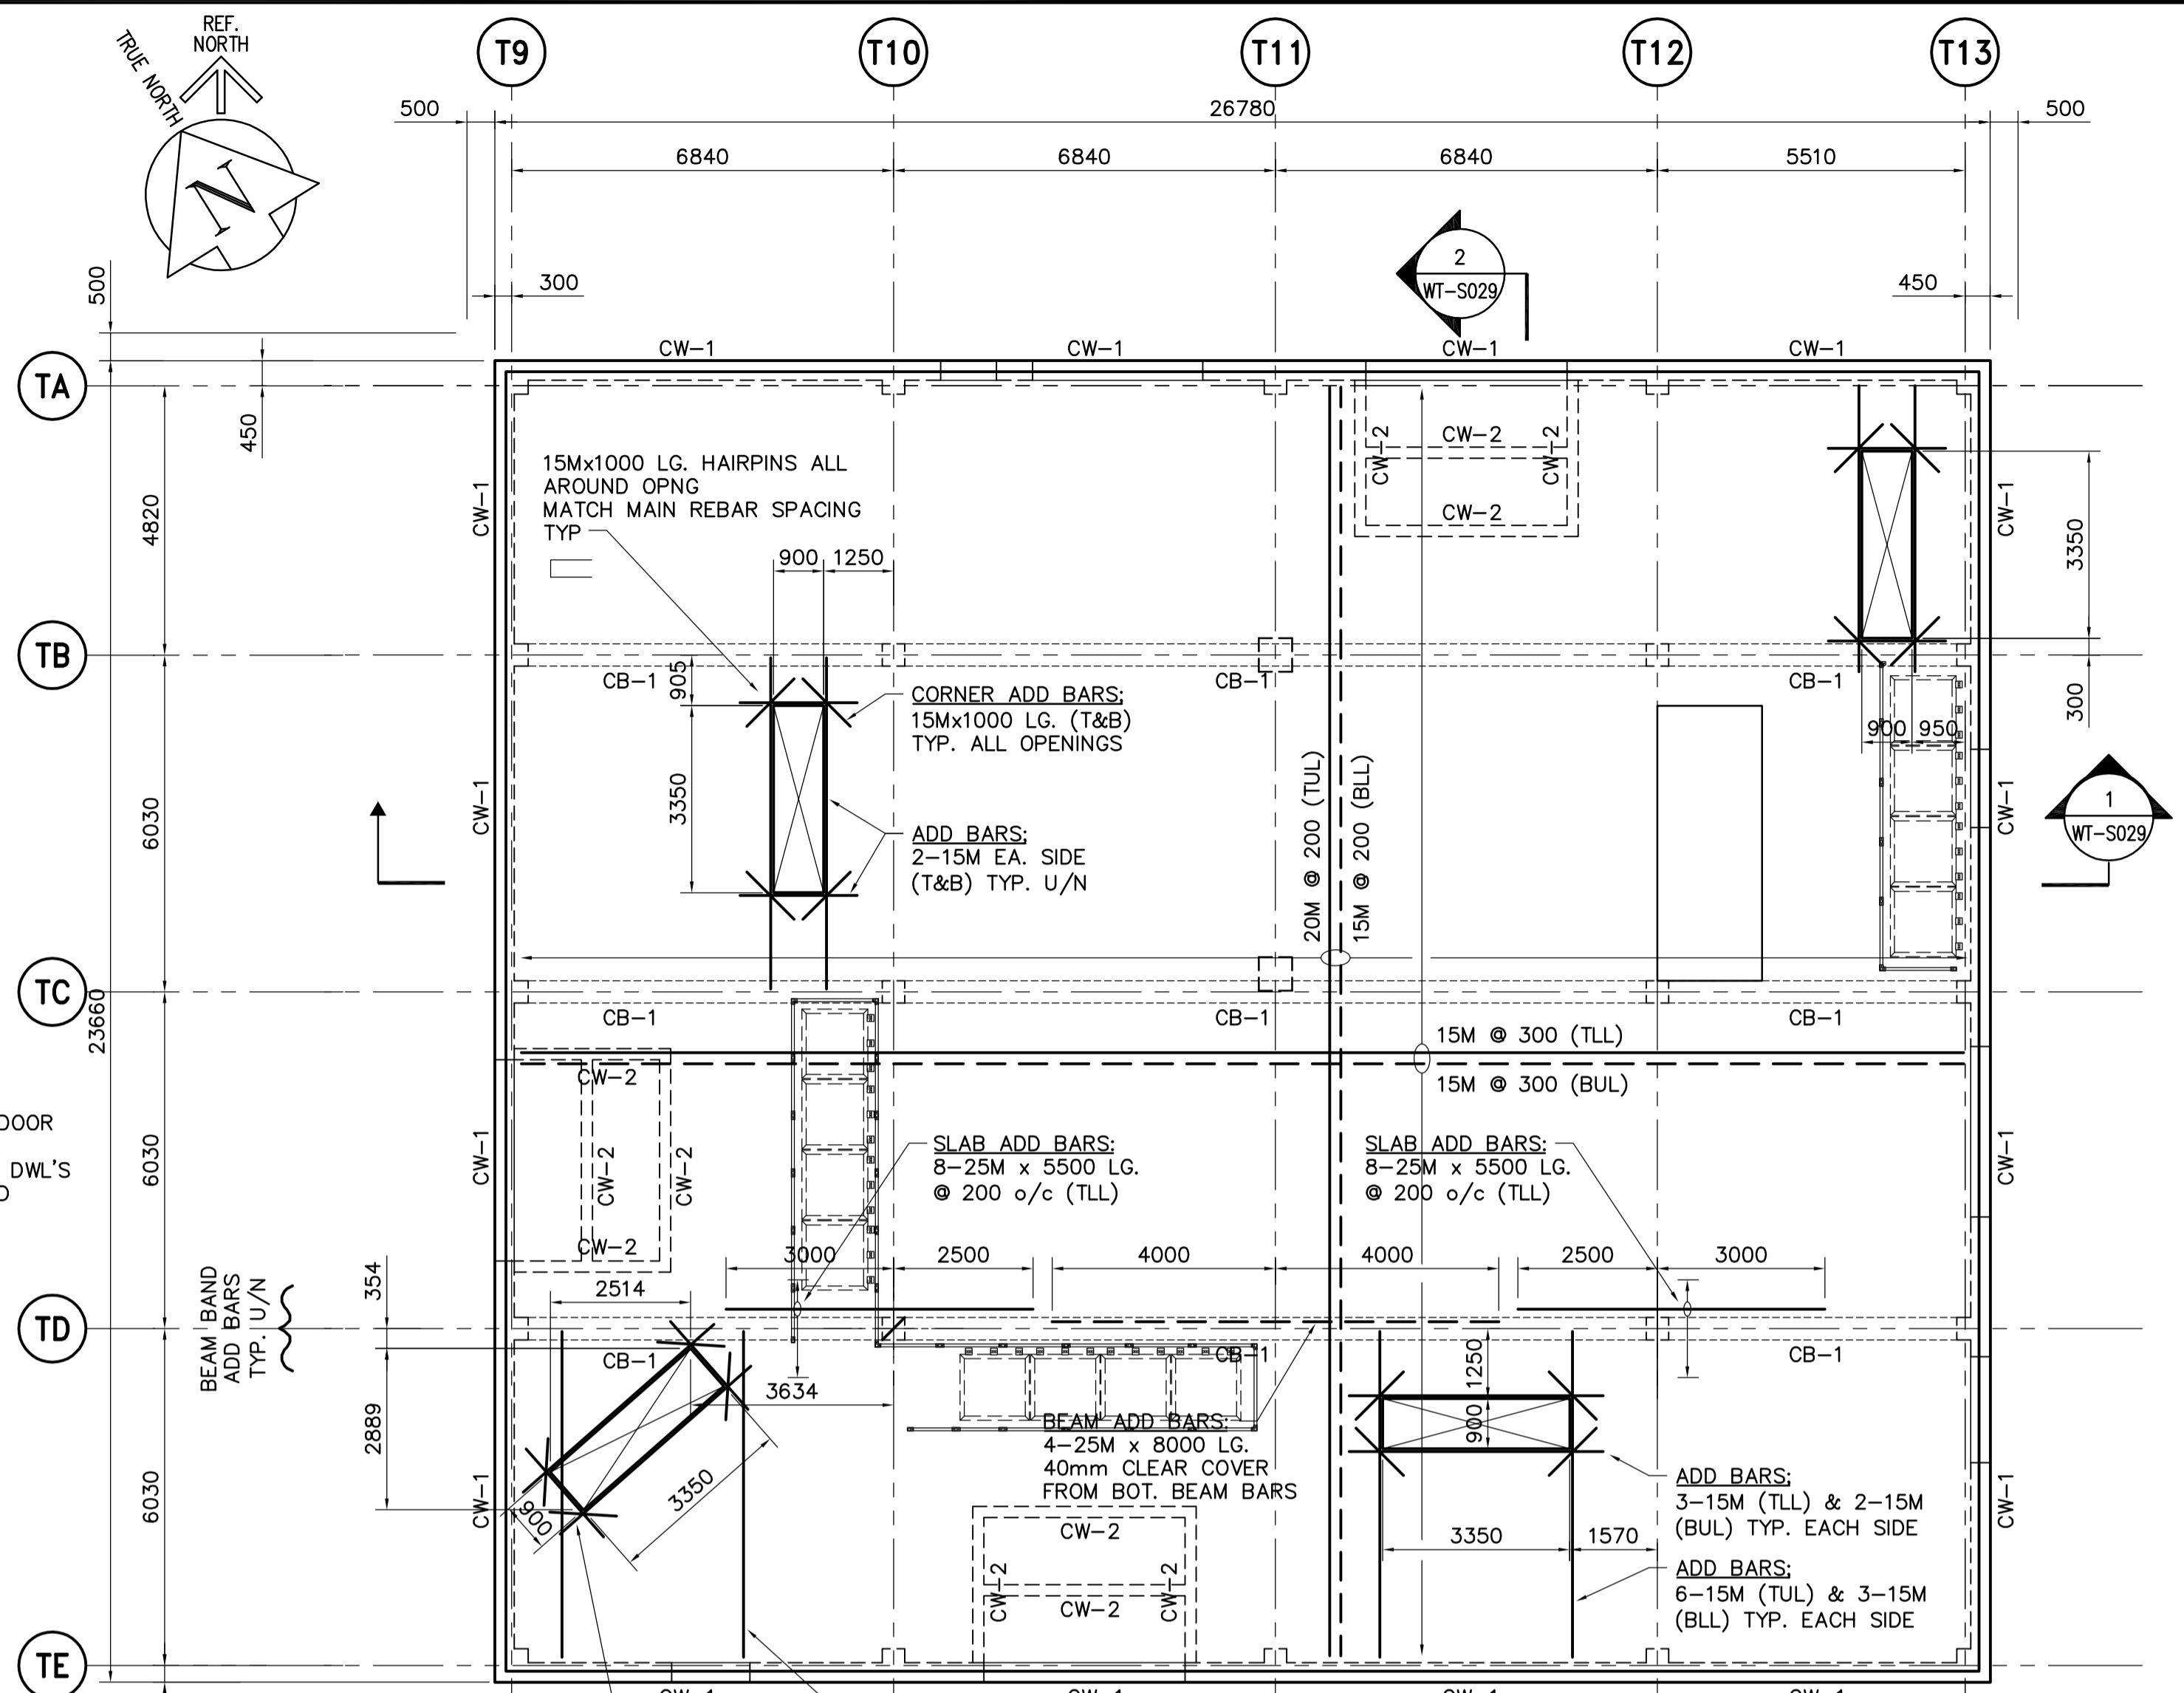

**ROOF FRAMING PLAN**  
1:100

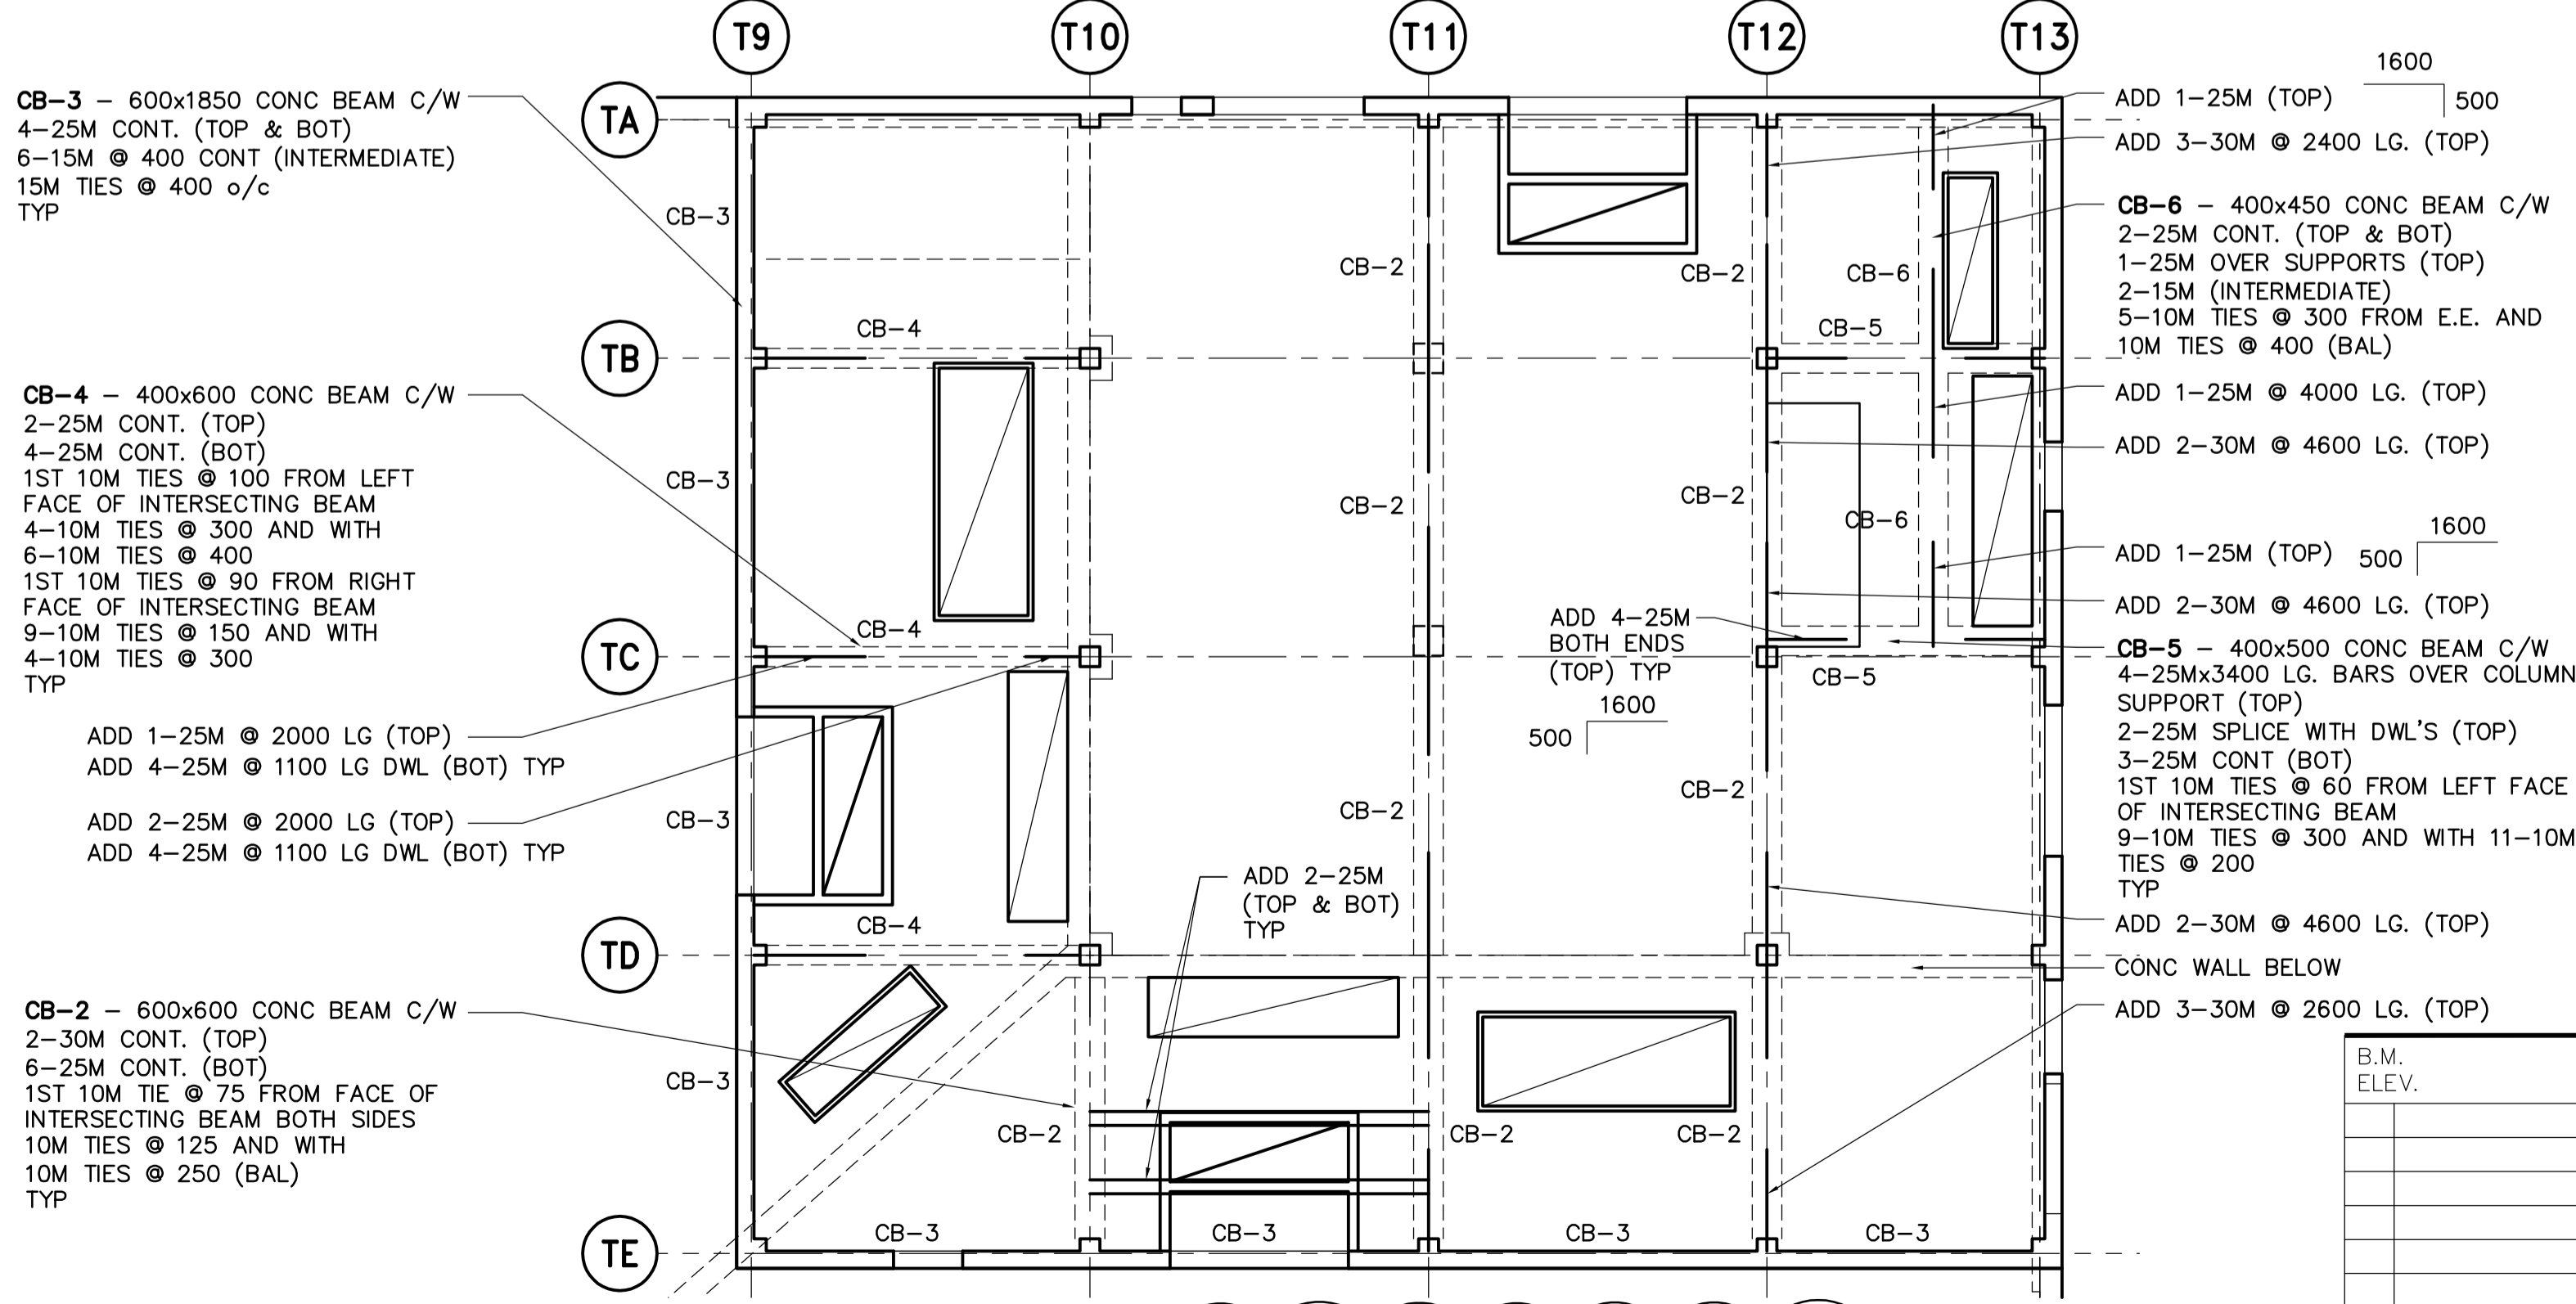

**MAIN FLOOR BEAM REINFORCING PLAN**  
N.T.S.  
ISSUED FOR STRUC SLAB REINF INFO ONLY

DRAWING NOTES:  
1. REFER TO DRAWING WT-S001 FOR GENERAL NOTES.

**FOR INFORMATION ONLY - NOT IN CONTRACT**  
(EXCEPT AS NOTED)

**APEGN**  
Certificate of Authorization  
Earth Tech Canada Inc.  
No. 730 Expiry: April 30, 2005

<b>CH2MHILL</b> Frederickson Cooper ARCHITECTS		<b>EarthTech</b> A Total International Ltd. Company		ENGINEER'S SEAL ORIGINAL SIGNED BY R.B. ERIC 2005/04/17		<b>THE CITY OF WINNIPEG</b> WATER AND WASTE DEPARTMENT ENGINEERING DIVISION WATER TREATMENT PLANT CLEARWELL CONSTRUCTION		CITY FILE NUMBER SHEET OF CITY DRAWING NUMBER 1-0601T-A-S0027-001-00D	
DESIGNED BY	FK	CHECKED BY	MK	CONSULTANT DRAWING NO.		WT-S027			
DRAWN BY	CMS	APPROVED BY	AHL	DATE		2005-03/09			
HOR. SCALE: AS NOTED		RELEASED FOR CONSTRUCTION BY:		DATE		2005-04-17			
VERTICAL SCALE:		R. SOROKOWSKI		DATE		2005-03/09			
NO.	REVISIONS	DATE	BY	DATE	BY				
00	ISSUED FOR TENDER	05/04/17	C.T.						