



ROOF DRAINAGE PLAN
1:200

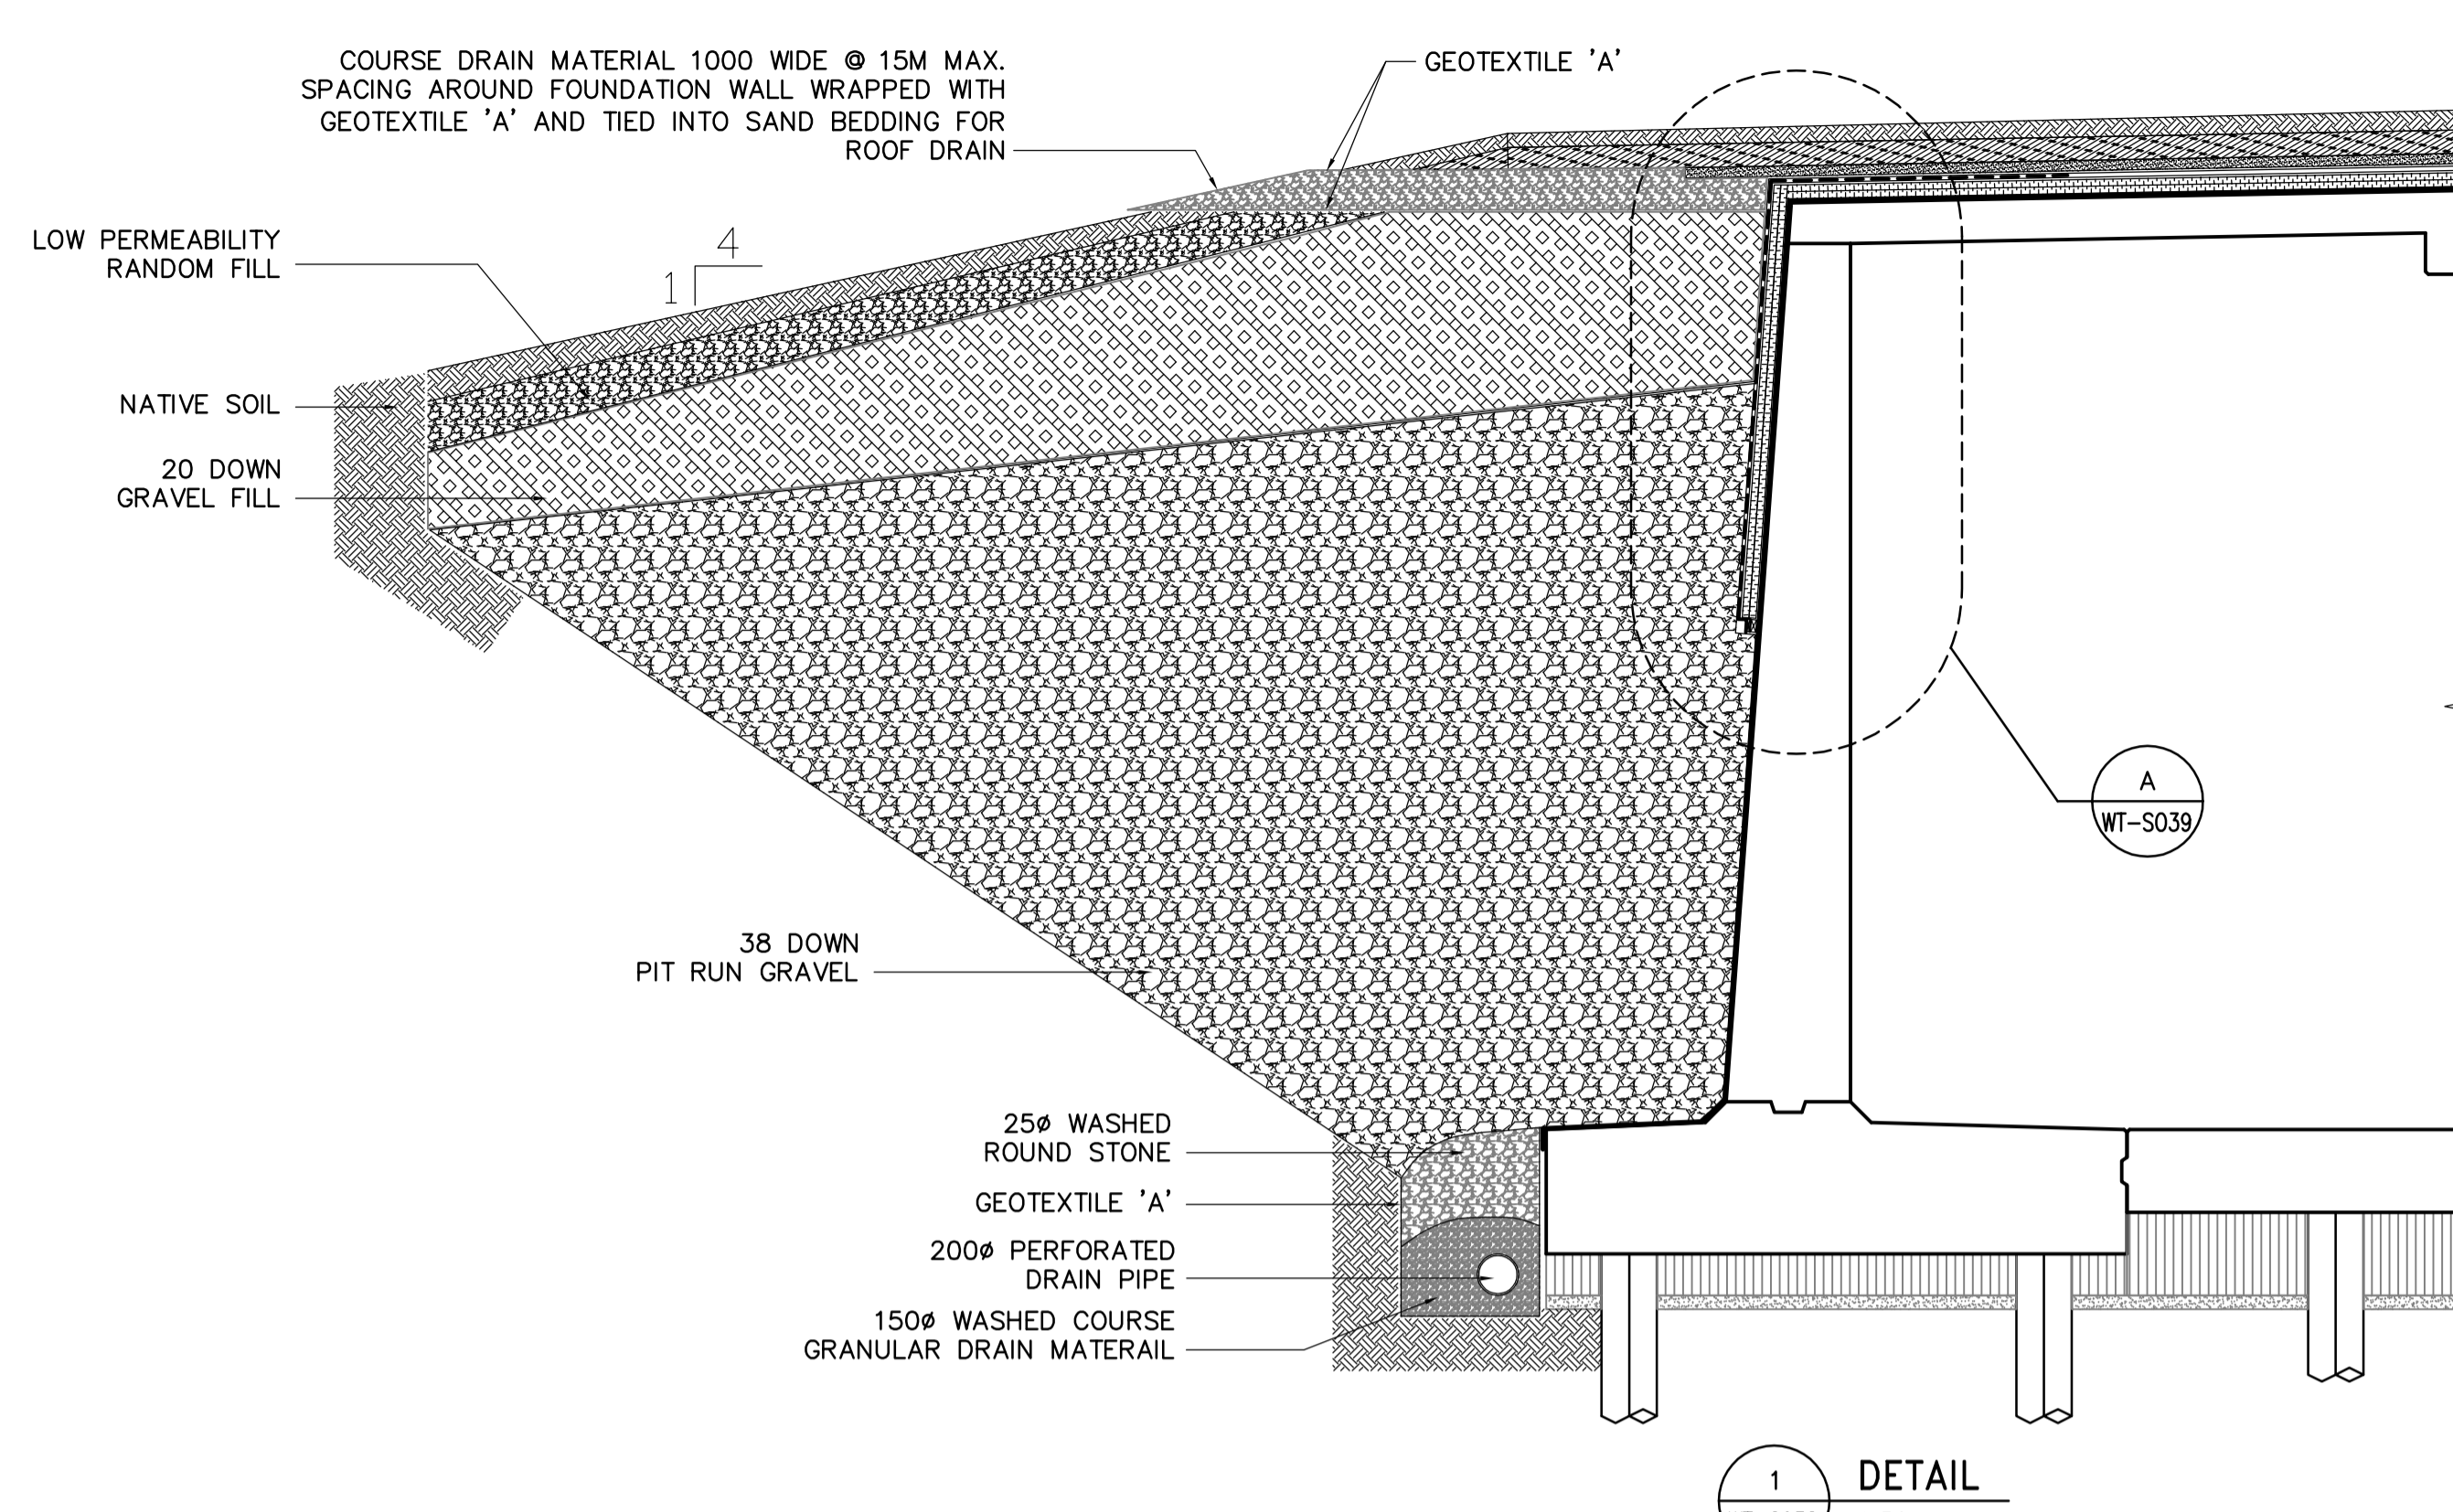

1 DETAIL
1:50

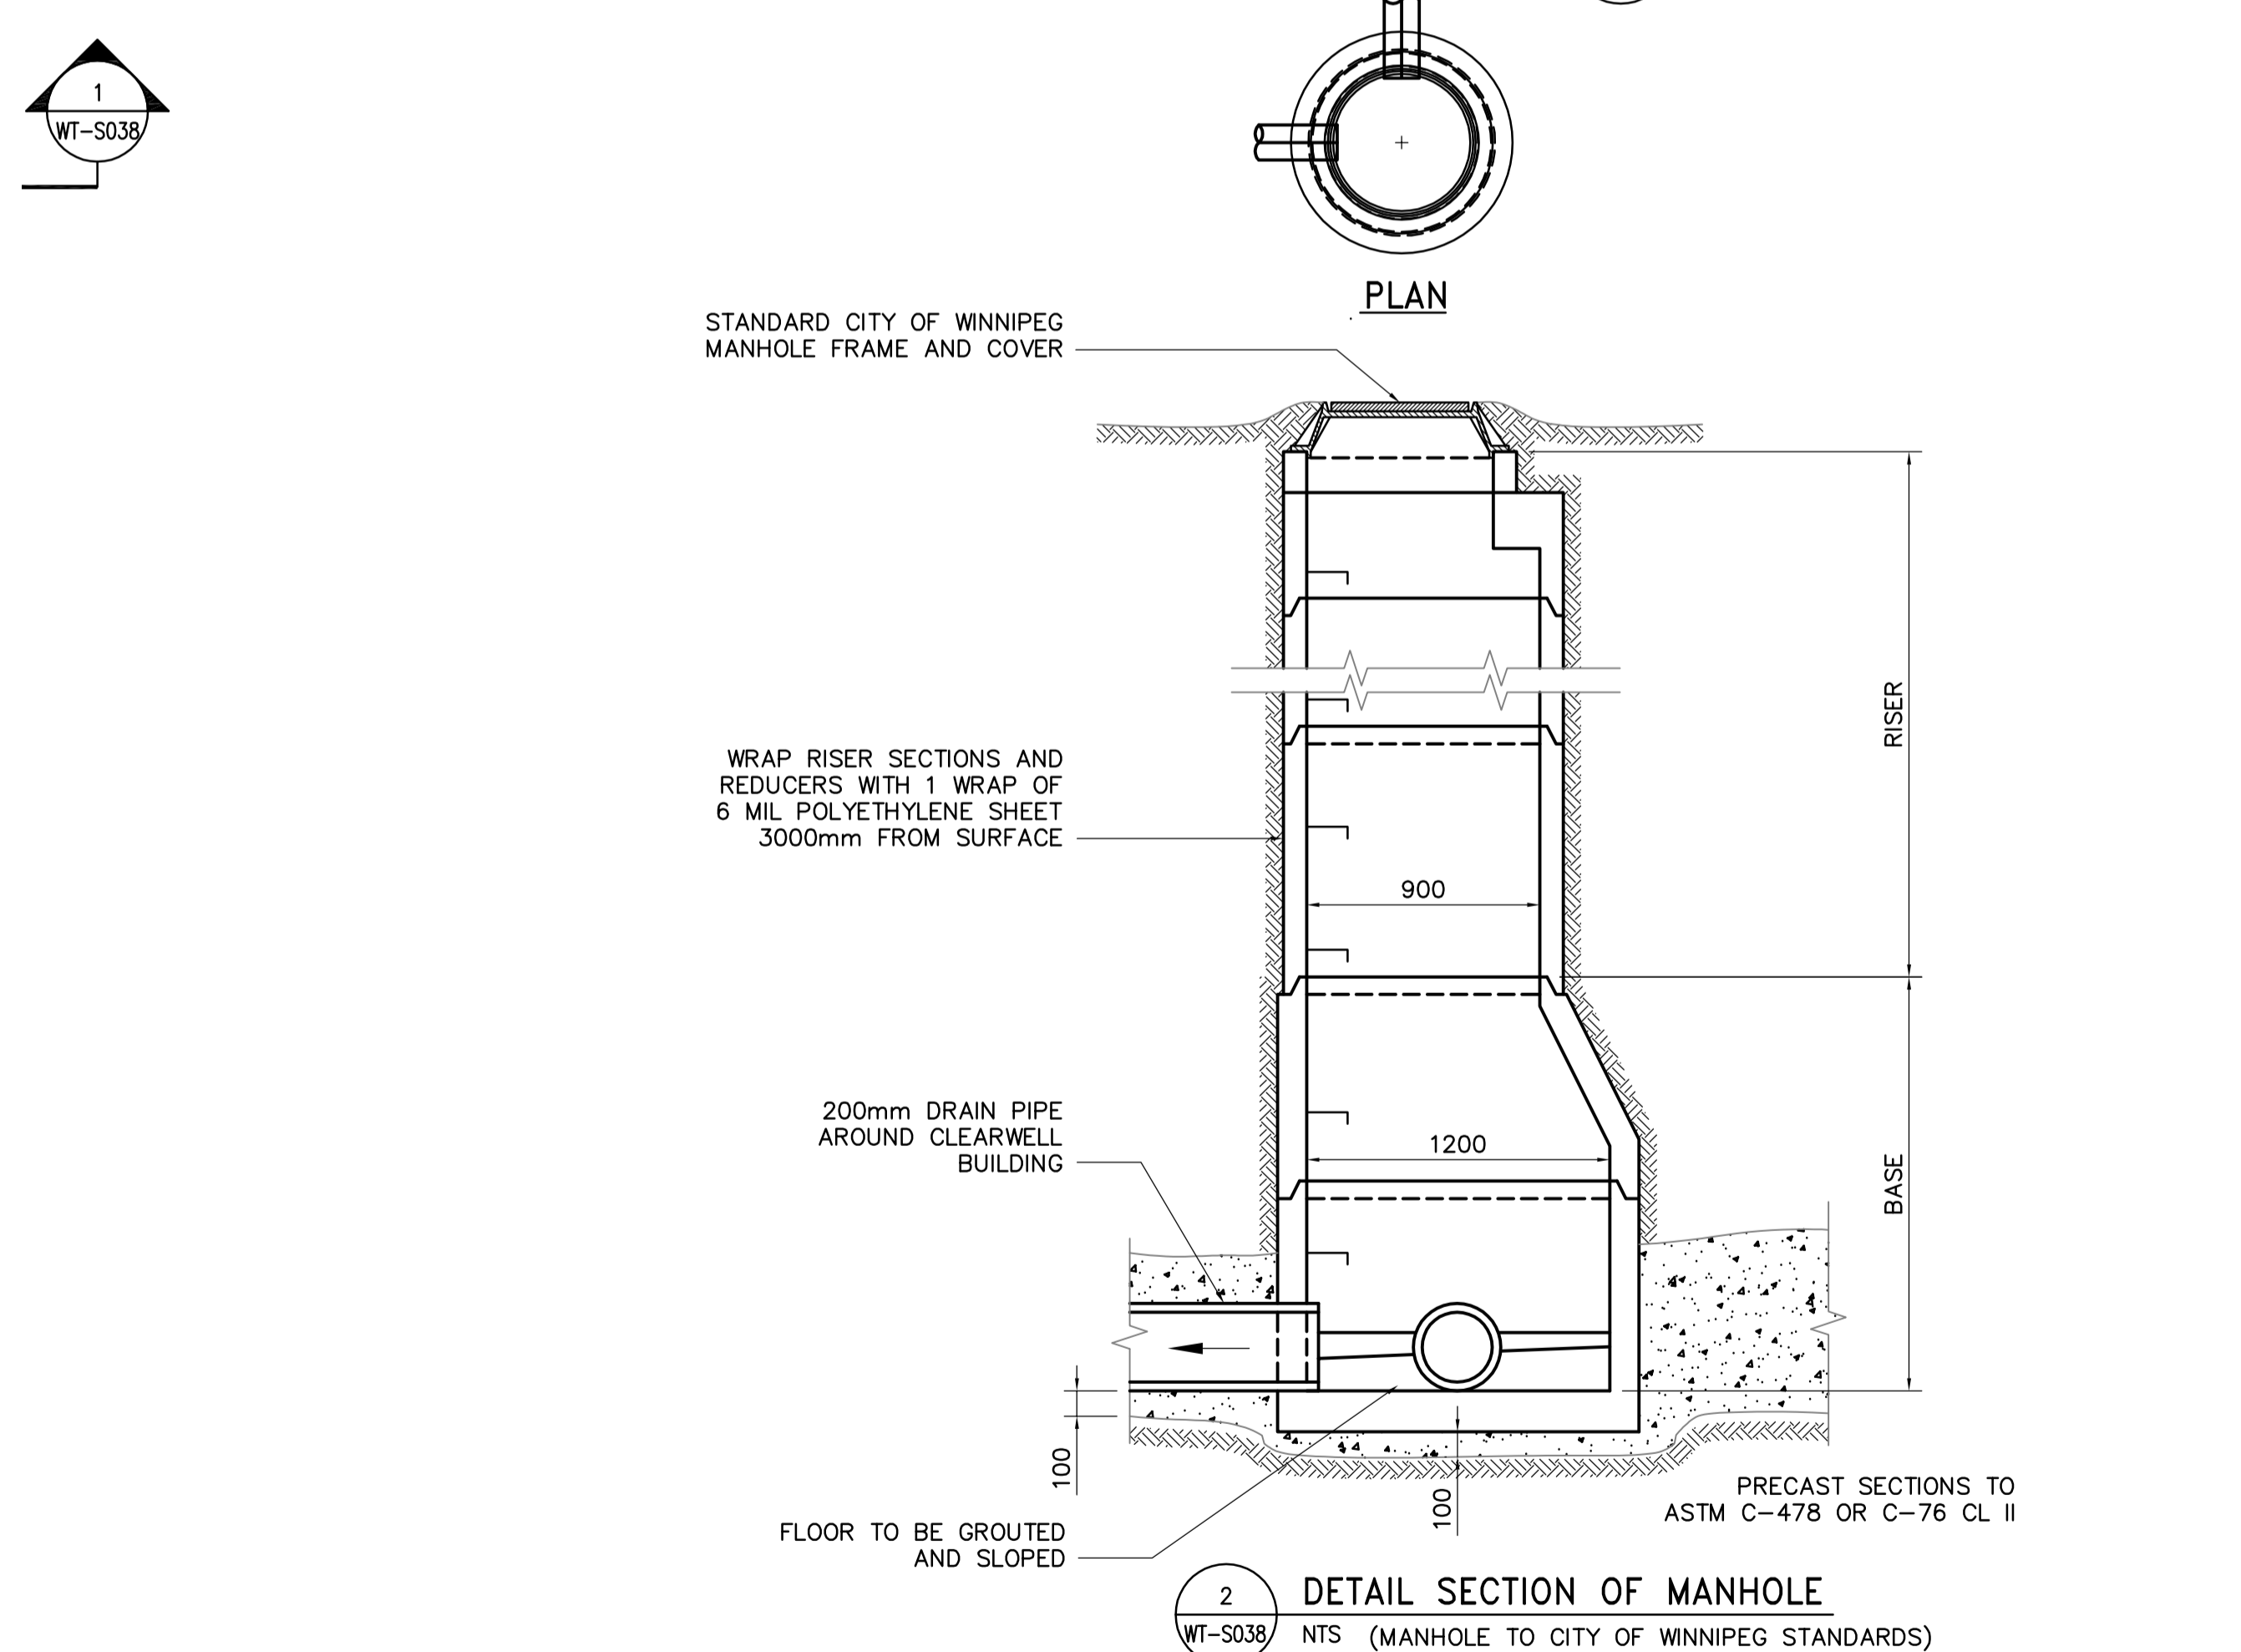

2 DETAIL SECTION OF MANHOLE
NTS (MANHOLE TO CITY OF WINNIPEG STANDARDS)

APEGM
Certificate of Authorization
Earth Tech Canada Inc.
No. 730 Expiry: April 30, 2005

B.M. ELEV.					
00	ISSUED FOR TENDER	05/04/17	C.T.		
	NO. REVISIONS	DATE	BY	DATE	

CH2M HILL
Frederickson Cooper ARCHITECTS

DESIGNED BY: FK
DRAWN BY: C.T. / WDB

CHECKED BY: MK
APPROVED BY: AHL

HOR. SCALE: AS NOTED
VERTICAL SCALE:

RELEASED FOR CONSTRUCTION BY:
R. SOROKOWSKI

DATE: 2005/03/09
DATE: 2005-04-17

ENGINEER'S SEAL

ORIGINAL SIGNED BY:
F.A. KEMP

2005/04/17

CONSULTANT DRAWING NO.
WT-S038

THE CITY OF WINNIPEG
WATER AND WASTE DEPARTMENT
ENGINEERING DIVISION

WATER TREATMENT PLANT CLEARWELL CONSTRUCTION

STRUCTURAL
ROOF DRAINAGE PLAN
DETAIL SECTION OF MANHOLE

CITY FILE NUMBER
SHEET OF
CITY DRAWING NUMBER
1-0601T-A-S0038-001-00D