




NORTH ELEVATION  
1:100

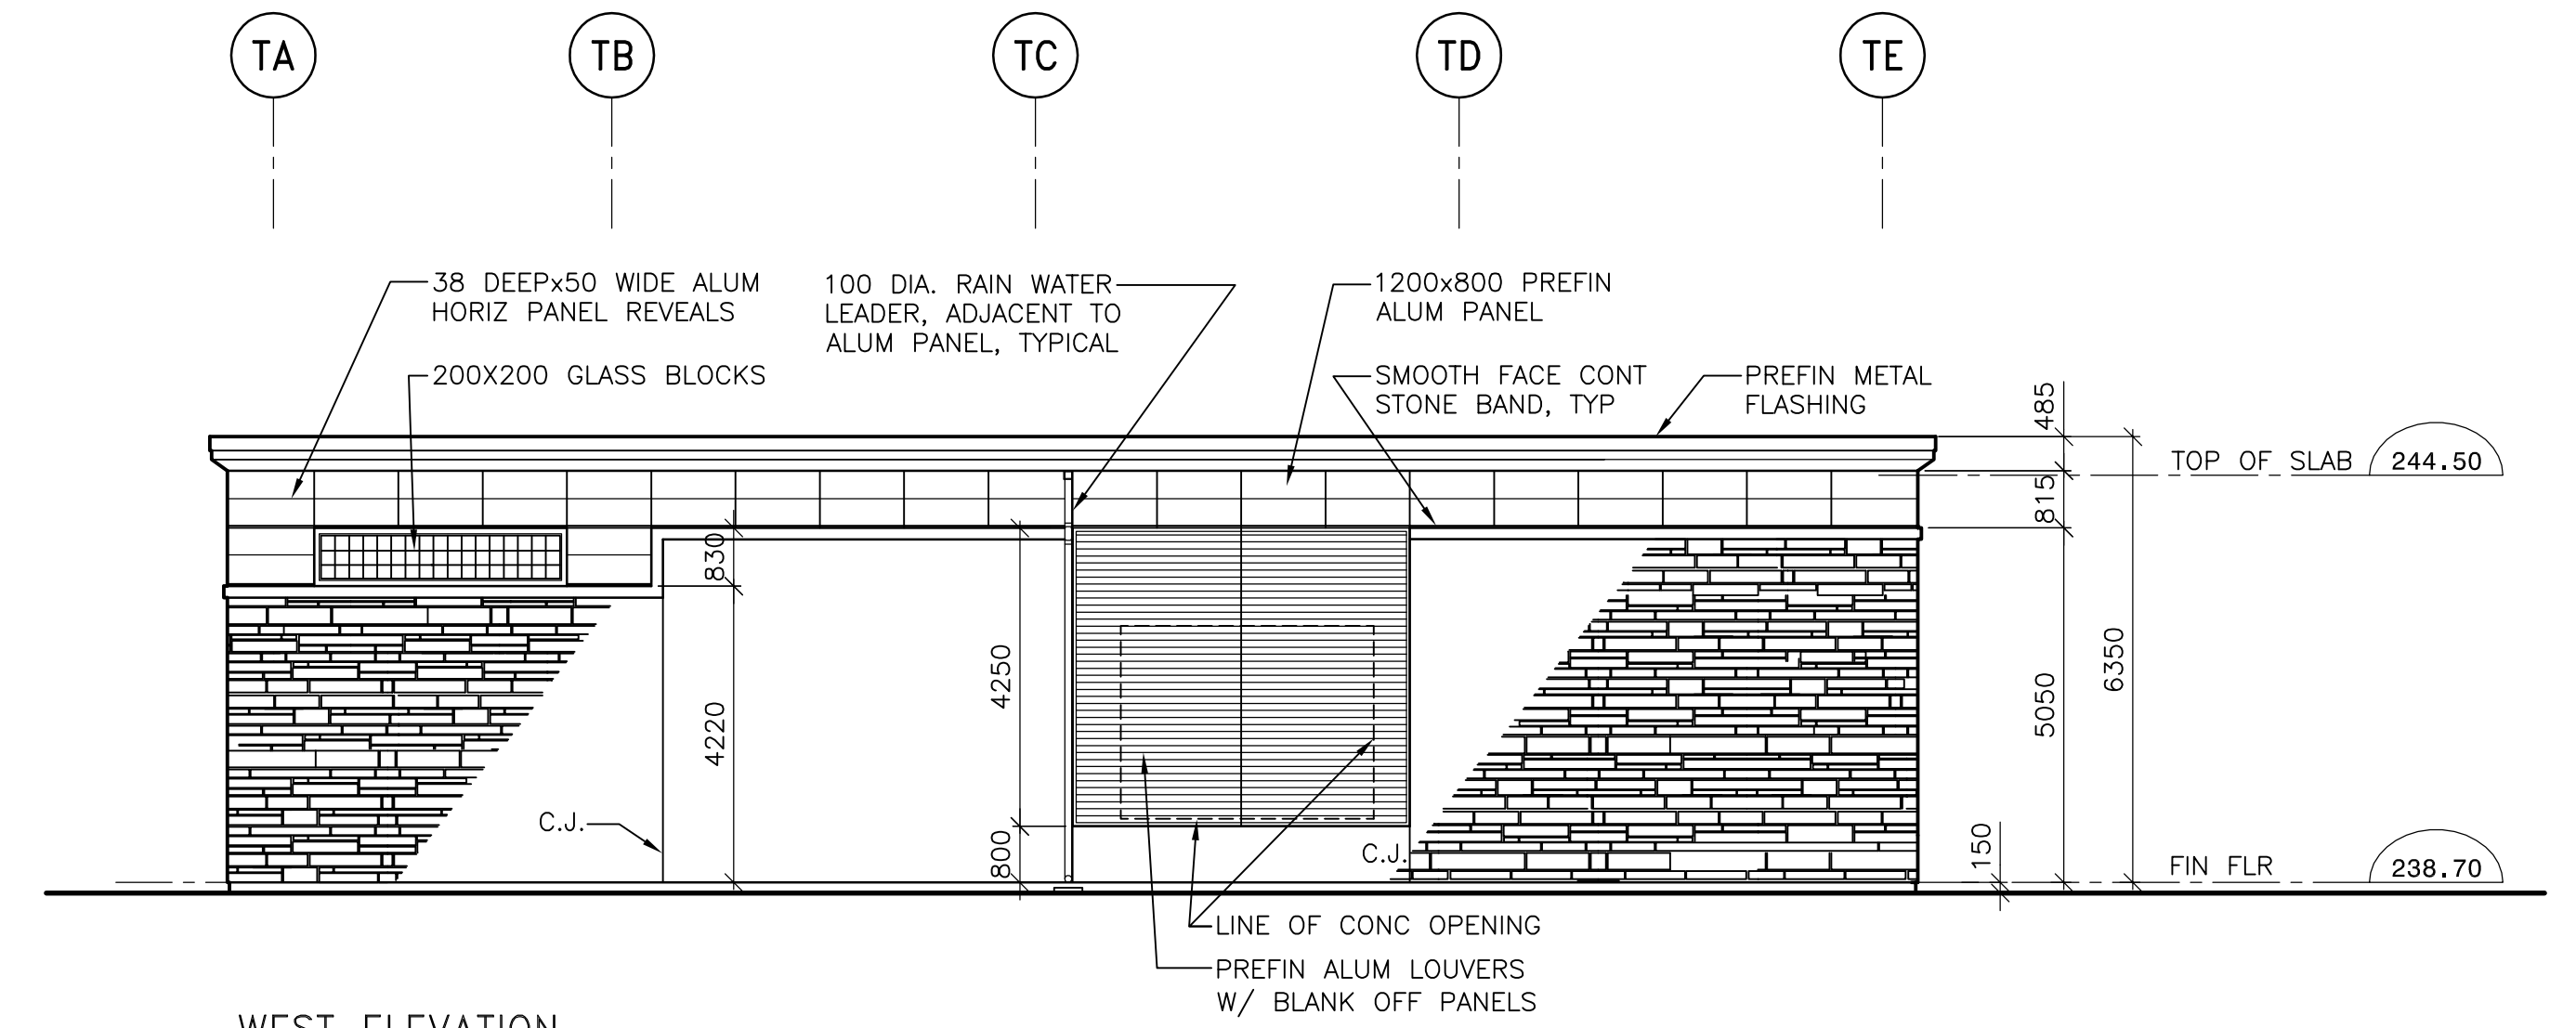

WEST ELEVATION  
1:100

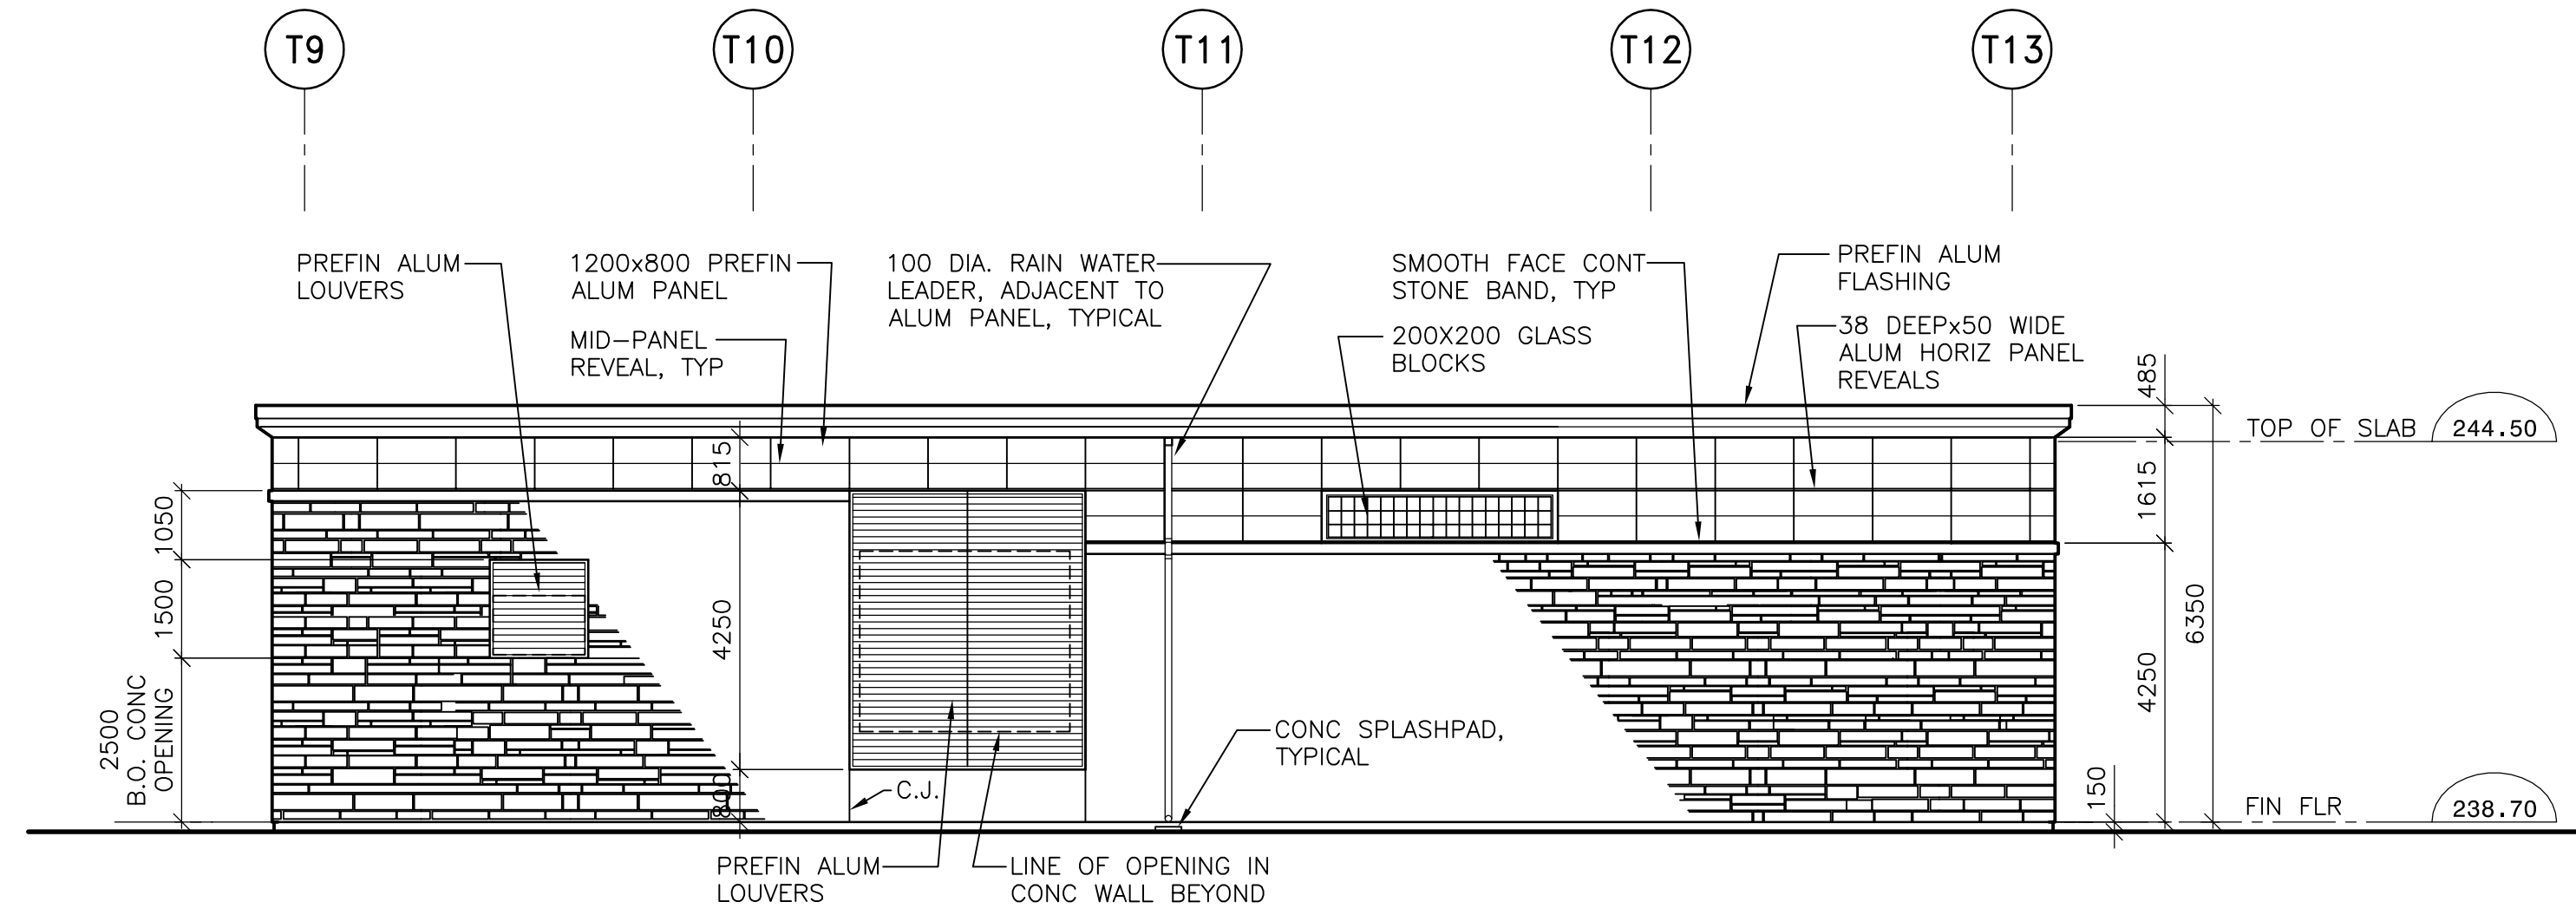

SOUTH ELEVATION  
1:100

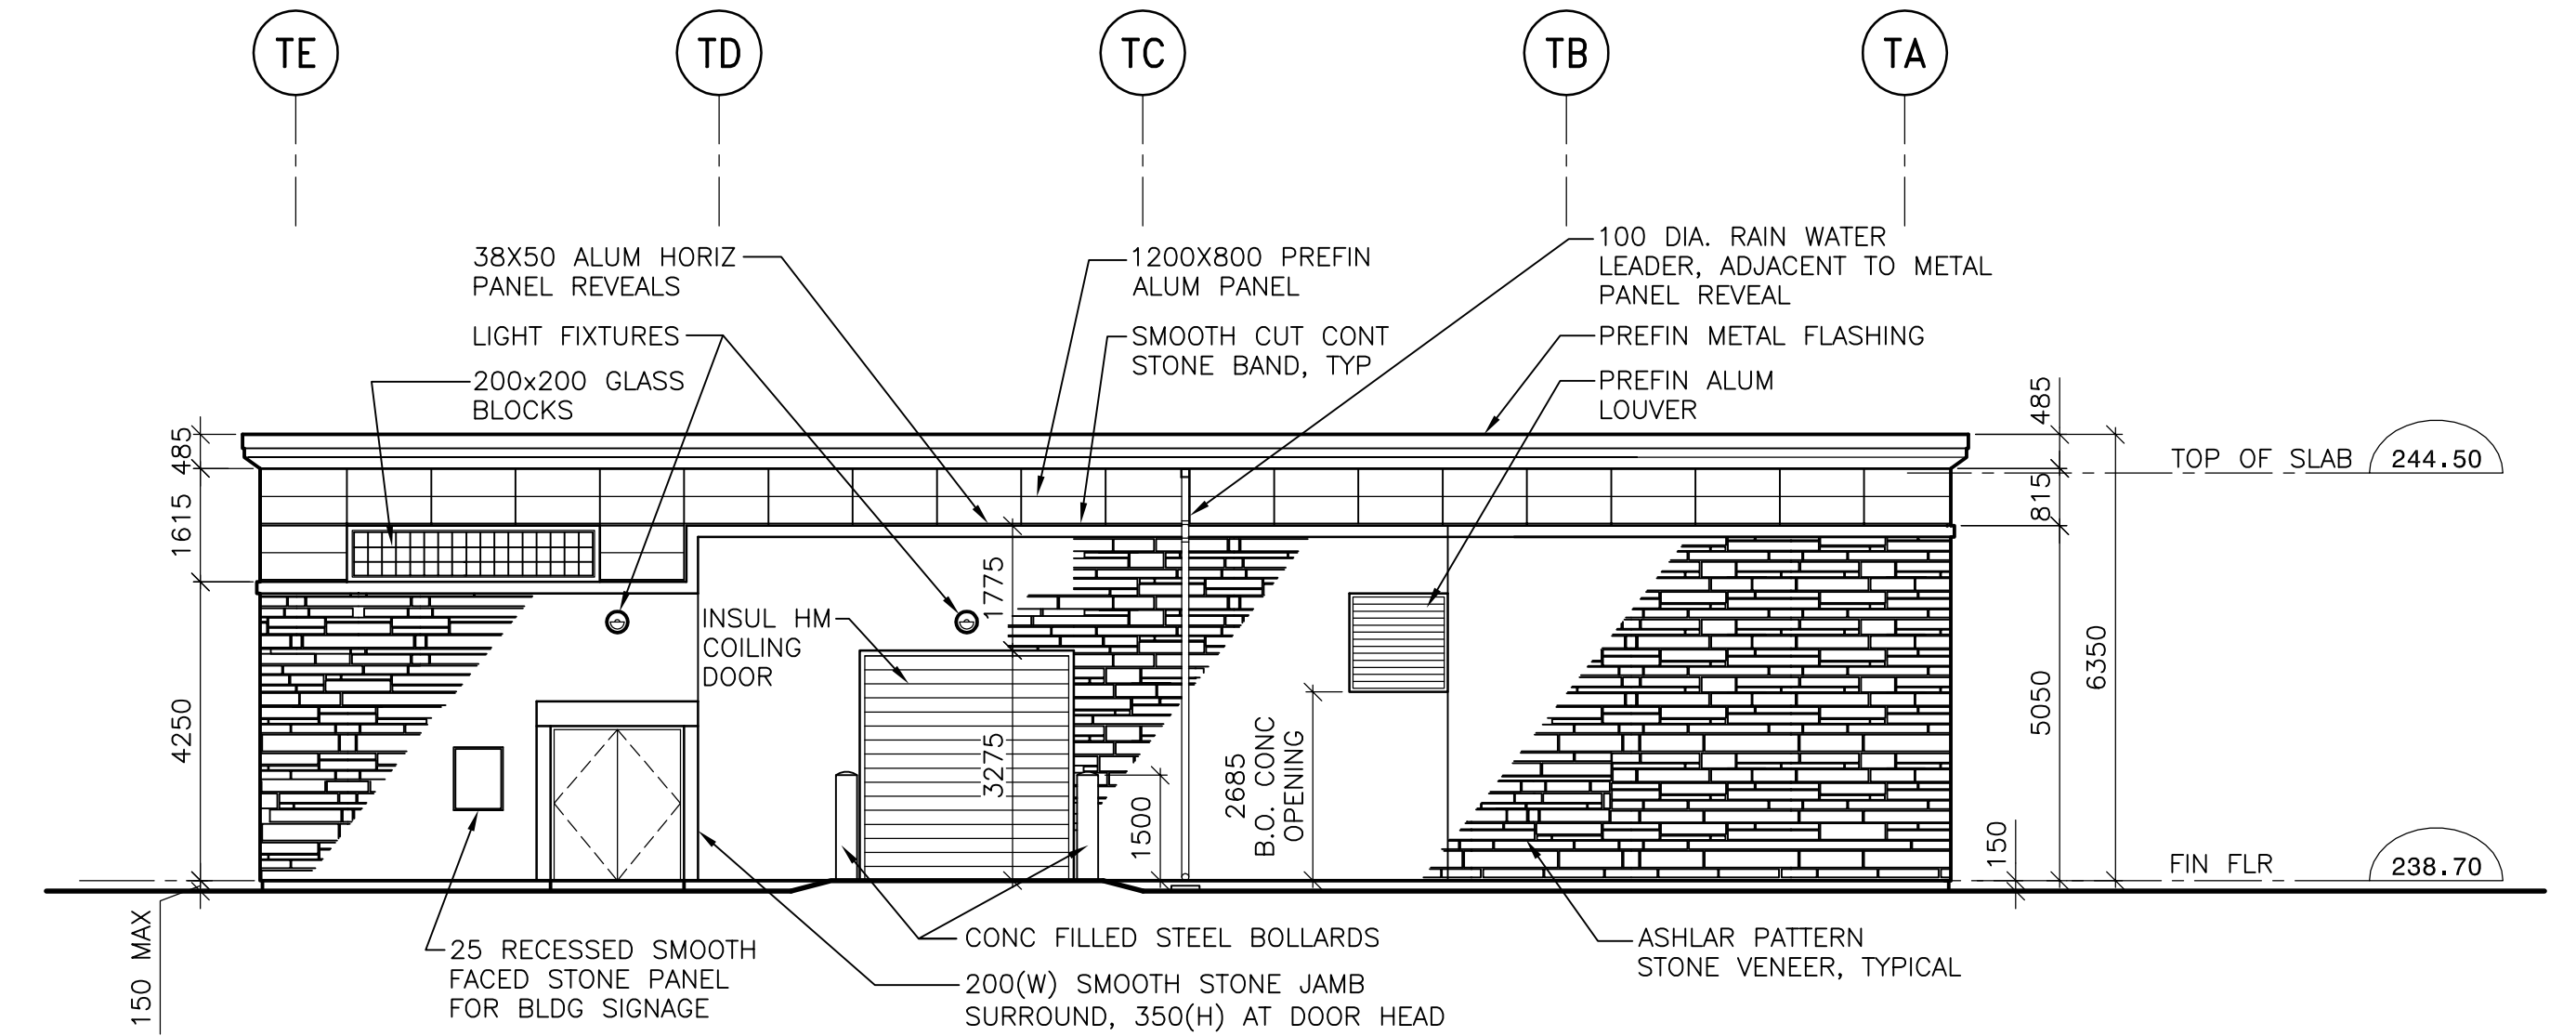

EAST ELEVATION  
1:100

FOR INFORMATION ONLY - NOT IN CONTRACT

B.M. ELEV.				ENGINEER'S SEAL		<b>THE CITY OF WINNIPEG</b> WATER AND WASTE DEPARTMENT ENGINEERING DIVISION	
		<b>Frederickson Cooper</b> ARCHITECTS				<b>WATER TREATMENT PLANT</b> <b>CLEARWELL CONSTRUCTION</b>	
		DESIGNED BY: BS	CHECKED BY:			CITY FILE NUMBER	
		DRAWN BY: WC	APPROVED BY:			SHEET OF	
		HOR. SCALE: AS NOTED		RELEASED FOR CONSTRUCTION BY:		CITY DRAWING NUMBER	
		VERT. SCALE: AS NOTED					
00	ISSUED FOR TENDER (N.I.C.)	05/04/17	WC			CONSULTANT DRAWING NO. WT-A004	
NO.	REVISIONS	DATE	BY	DATE	05/04/04		