




CODE

- 1. PENTHOUSE
- 2. CHIMNEY
- 3. AIR COND. UNITS
- 4. SIGN SUPPORT
- 5. VENTILATOR
- 6. VENT PIPE
- 7. DRAIN
- 8. SKYLIGHT
- 9. EAVESTROUGH
- 10. FIRE WALL
- 11. TANK
- 12. STUB COLUMN
- 13. GRAVEL STOP
- 14. HATCH
- 15. SCUPPER
- 16. PITCH BOXES
- 17. ANTENNA
- 18. GUYWIRE
- 19.
- 20.

==== PARAPET

AREA "A"

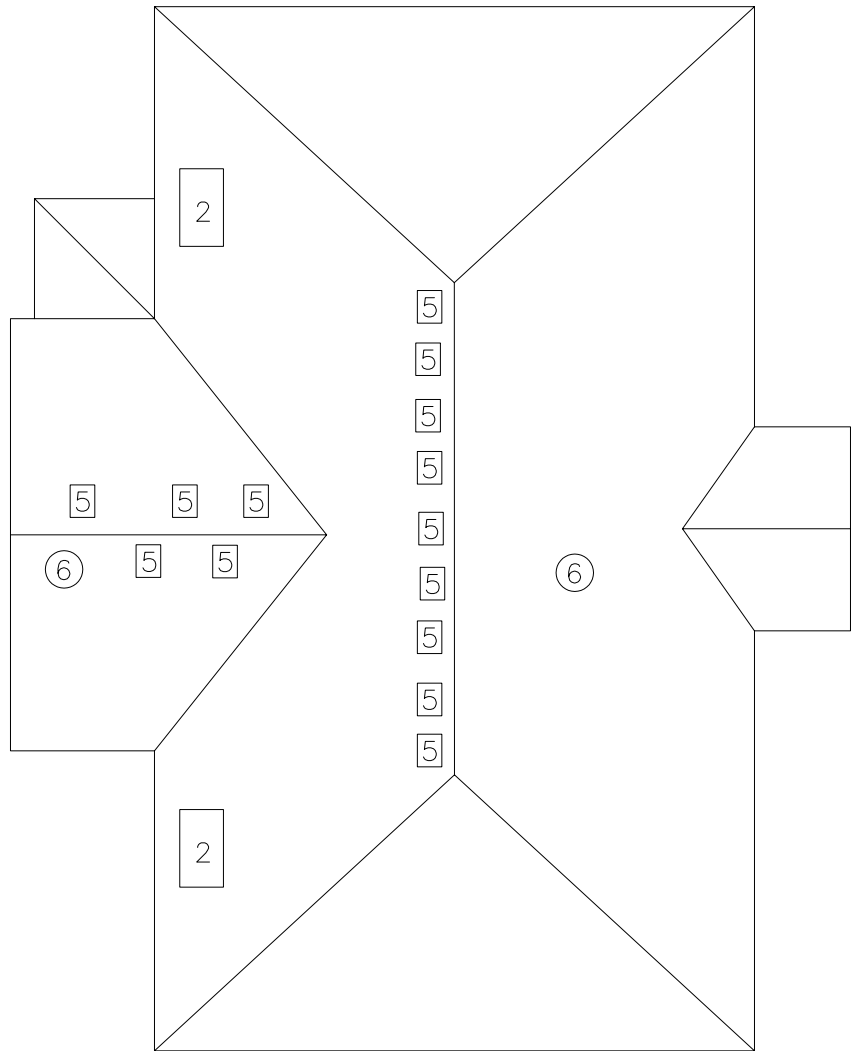

CITY OF WINNIPEG PLANNING, PROPERTY & DEVELOPMENT DEPARTMENT CIVIC ACCOMMODATIONS DIVISION 300-65 GARRY STREET R3C 4K4		PROJECT <b>CORNISH LIBRARY</b> <b>ROOF REPLACEMENT &amp; RELATED REPAIRS</b> 20 WEST GATE		SHEET TITLE <b>ROOF PLAN</b>	
DRAWN BY	CHECKED BY	APPROVED BY	DATE	SCALE	SHEET NO.
DNJ	LOR	LOR	2005.05.24 eFILE 2005052V0.dwg/A1	1/16"=1'-0" PROJECT NO. 2005-052	<b>A-1</b>