 



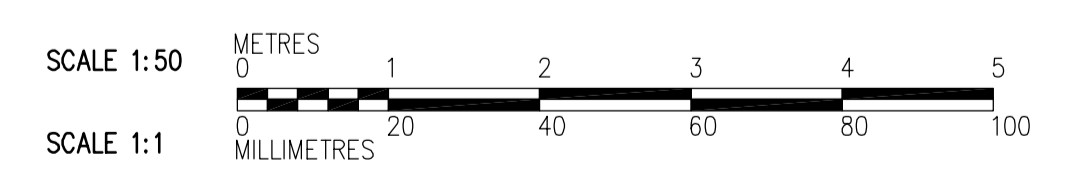
NOTES:





- SEE DWGS WM-S0111 TO WM-S0146 FOR SLAB REINFORCING, UNO.
- SEE DWG WM-S0515 FOR BEAM AND COLUMN SCHEDULES.
- FOR TYPICAL WALL CORNER REINF SEE  WB-S0452

LEGEND:

 NOT IN CONTRACT

C SECTION
WM-S0111 1:50
WM-S0146
WM-F0105



 APEGH Certificate of Authorization CH2M HILL Canada Ltd. No. 1441 Expiry: April 30, 2006	B.M. ELEV. <table border="1"> <tr><td> </td><td> </td><td> </td><td> </td></tr> <tr><td> </td><td> </td><td> </td><td> </td></tr> <tr><td> </td><td> </td><td> </td><td> </td></tr> <tr><td> </td><td> </td><td> </td><td> </td></tr> <tr><td> </td><td> </td><td> </td><td> </td></tr> </table>																					 Frederickson Cooper ARCHITECTS	 A Terra International Ltd. Company	ENGINEER'S SEAL ORIGINAL SIGNED BY D. KRUGER 2006/02/06	 THE CITY OF WINNIPEG WATER AND WASTE DEPARTMENT ENGINEERING DIVISION WATER TREATMENT PLANT GENERAL PLANT SERVICES/MISCELLANEOUS FOUNDATIONS AND CONCRETE STRUCTURES	CITY FILE NUMBER SHEET OF
DESIGNED BY MH CHECKED BY AP DRAWN BY RL APPROVED BY DJT SCALE: 1:50 RELEASED FOR CONSTRUCTION BY: R. SOROKOWSKI 2005/09/16 2006/02/08	CONSULTANT DRAWING NO. WM-S0203	STRUCTURAL ELECTRICAL ROOM SECTION CITY DRAWING NUMBER 1-060M-A-80203-001-01D																								