



- NOTES:**
- DESIGN SNOW LOAD AS NOTED.
 - SUPERIMPOSED DEAD LOAD IS 1.0 kPa.
 - PARAPET WALLS TO BE PROVIDED IN SEPARATE CONTRACT ALONG ALL EXTERIOR WALLS AND ALONG ALL EXPANSION JOINTS. FOR DOWEL DETAIL SEE (4) WB-S0464
 - CONNECTIONS BETWEEN TEES TO BE SPACED BY PRECAST SUPPLIER AS PER LOADS. SEE (6) WB-S0464
 - CAST-IN PLACE ANGLE IN UPSTAND BEAM DESIGNED AND SUPPLIED BY PRECAST SUPPLIER, AND INSTALLED BY GENERAL CONTRACTOR, SEE (6) WB-S0464
 - NOTE THAT (5) WB-S0464 MAY BE USED TO SUPPORT LIGHT FIXTURES INSTALLED UNDER SEPARATE CONTRACT. COORDINATE NUMBER AND LOCATION.
 - PROVIDE 20mm ϕ SLEEVES IN ALL DOUBLE TEE STEMS 1200mm C/C.
 - REFER TO "GENERAL NOTES" ON DRAWING WM-S9002 FOR OPENINGS AND BLOCK OUTS NOT IDENTIFIED ON THIS DRAWING.

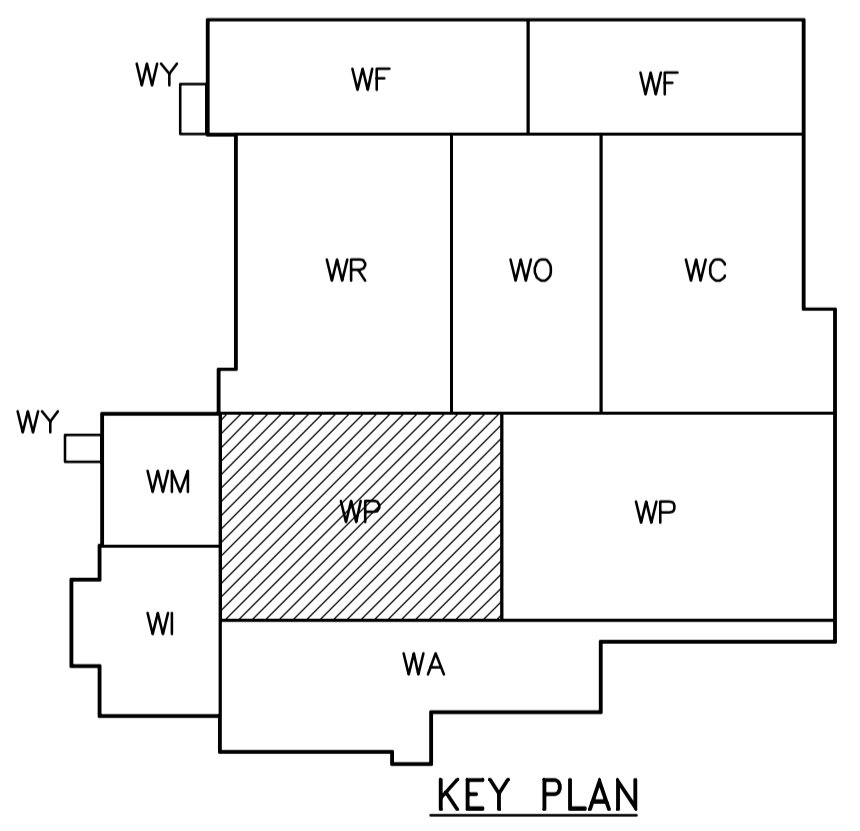

ROOF PLAN
1:100

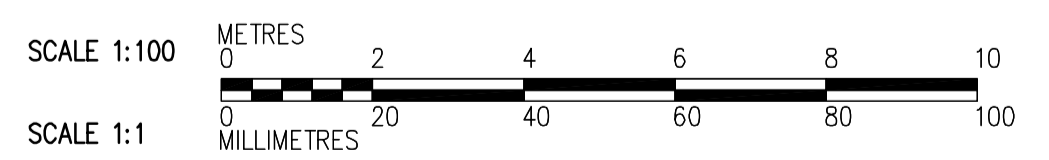

<p>APEGN Certificate of Authorization CH2M HILL Canada Ltd. No. 1441 Expiry: April 30, 2006</p>	<p>Frederickson Cooper ARCHITECTS</p>		<p>EarthTech A Tyco International Ltd. Company</p>		ENGINEER'S SEAL ORIGINAL SIGNED BY D. KRUGER 2006/02/06	<p>THE CITY OF WINNIPEG WATER AND WASTE DEPARTMENT ENGINEERING DIVISION</p> <p>WATER TREATMENT PLANT FLOCCULATION AND DAF FOUNDATIONS AND CONCRETE STRUCTURES</p> <p>STRUCTURAL FLOC/DAF AREA 1 ROOF PLAN</p>	CITY FILE NUMBER SHEET OF
	DESIGNED BY: DK CHECKED BY: AP		DRAWN BY: RL APPROVED BY: DJT		CONSULTANT DRAWING NO. WP-S0146		CITY DRAWING NUMBER 1-060P-A-8046-001-0D
	SCALE: 1:100		RELEASED FOR CONSTRUCTION BY: R. SOROKOWSKI				
	NO. REVISIONS: 01 583-2005 ADDENDUM 3 06/03/10 DK 00 ISSUED FOR TENDER 2006/02/03 DK		DATE: 2005/08/28 DATE: 2006/02/08				