


- NOTES:**
- SEE DWGS WP-S0111 TO WP-S0132 FOR SLAB REINFORCING AND WALL ADDITIONAL REBARS, UNO.
 - SEE DWG WP-S0515 FOR BEAM AND COLUMN SCHEDULES.
 - FOR WALL AND FTG REINF SEE SECTION D, TYP WP-S0205

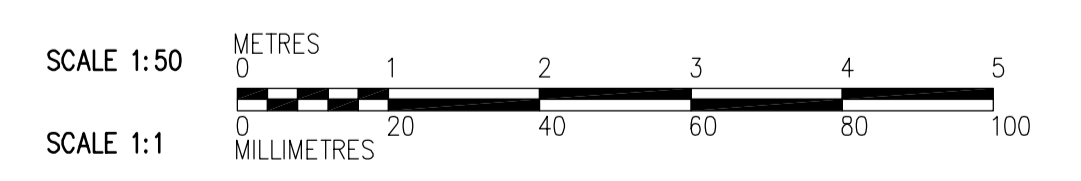

<p>Certificate of Authorization CH2M HILL Canada Ltd. No. 1441 Expiry: April 30, 2006</p>	B.M. ELEV.	<p>Frederickson Cooper ARCHITECTS</p>	<p>A Yoo International Ltd. Company</p>	ENGINEER'S SEAL	<p>THE CITY OF WINNIPEG WATER AND WASTE DEPARTMENT ENGINEERING DIVISION</p>	
				DESIGNED BY RZ		CHECKED BY AP
		DRAWN BY CA	APPROVED BY DJT	2006/02/06		WATER TREATMENT PLANT FLOCCULATION AND DAF FOUNDATIONS AND CONCRETE STRUCTURES
		SCALE: 1:50	RELEASED FOR CONSTRUCTION BY: R. SOROKOWSKI	CONSULTANT DRAWING NO. WP-S0203		CITY FILE NUMBER SHEET OF CITY DRAWING NUMBER 1-060P-A-50203-001-0D
	NO. REVISIONS	DATE BY	DATE 2005/11/01	DATE 2006/02/08	STRUCTURAL FLOC/DAF AREA 1 SECTION	