


FIRST FLOOR PLAN
1:300

FOUNDATIONS AND CONCRETE
STRUCTURES CONTRACT 583-2005

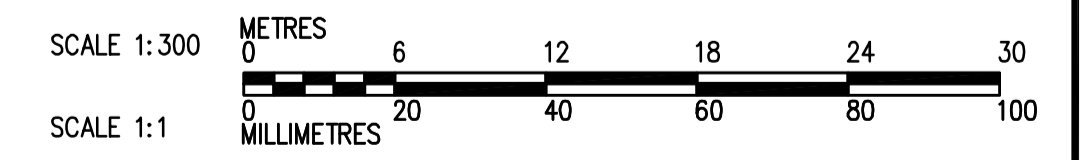

 Certificate of Authorization CH2M HILL Canada Ltd. No. 1441 Expiry: April 30, 2006	 Frederickson Cooper ARCHITECTS	 A Geo International Ltd. Company	ENGINEER'S SEAL		 THE CITY OF WINNIPEG WATER AND WASTE DEPARTMENT ENGINEERING DIVISION	WATER TREATMENT PLANT MAIN BUILDING FOUNDATIONS AND CONCRETE STRUCTURES	PLUMBING PIPE EMBEDS OVERALL FIRST FLOOR PLAN	ORIGINAL SIGNED BY D.K. CUDDINGTON	CITY FILE NUMBER
			2006/02/06	SHEET OF					
			CONSULTANT DRAWING NO. WB-H9111	CITY DRAWING NUMBER 1-0601B-A-H9111-001-000					
			RELEASED FOR CONSTRUCTION BY: R. SOROKOWSKI						
DESIGNED BY JZ/SW CHECKED BY DL DRAWN BY JMcP APPROVED BY DJT		SCALE: 1:300 RELEASED FOR CONSTRUCTION BY: R. SOROKOWSKI		DATE 2005/07/15 DATE 2006/02/08					
B.M. ELEV.									
00 ISSUED FOR TENDER 2006/02/03 SW									
NO. REVISIONS DATE BY									