


WP	NORTHING	EASTING
B1	5524106.095	647902.820
B2	5524055.454	647984.054
B3	5523969.679	647936.880
B4	5524020.193	647826.745

NOTE:  
FOR SURVEY DATA SEE DRAWING NO. WM-C0165.  
"FOR INFORMATION ONLY, NOT IN CONTRACT"

**THIRD FLOOR PLAN**  
1:300

FOUNDATIONS AND CONCRETE STRUCTURES CONTRACT 583-2005

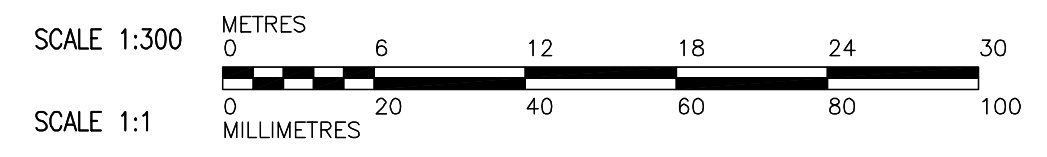

 <b>Certificate of Authorization</b> CH2M HILL Canada Ltd. No. 1441 Expiry: April 30, 2006	B.M. ELEV.	 Frederickson Cooper ARCHITECTS	 A Neo International Ltd. Company	ENGINEER'S SEAL  ORIGINAL SIGNED BY D. KRUGER  2006/02/06	 <b>THE CITY OF WINNIPEG</b> WATER AND WASTE DEPARTMENT ENGINEERING DIVISION
	DESIGNED BY: JC DRAWN BY: MS SCALE: 1:300	CHECKED BY: AP APPROVED BY: DJT RELEASED FOR CONSTRUCTION BY: R. SOROKOWSKI	CONSULTANT DRAWING NO. WB-S0130	WATER TREATMENT PLANT MAIN BUILDING FOUNDATIONS AND CONCRETE STRUCTURES STRUCTURAL THIRD FLOOR KEY PLAN	CITY FILE NUMBER SHEET OF CITY DRAWING NUMBER <b>1-060B-A-50130-001-00D</b>
00 ISSUED FOR TENDER 2006/02/03 JC NO. REVISIONS DATE BY	DATE 2005/09/21 DATE 2006/02/08				