



1
-
1:50
DETAIL

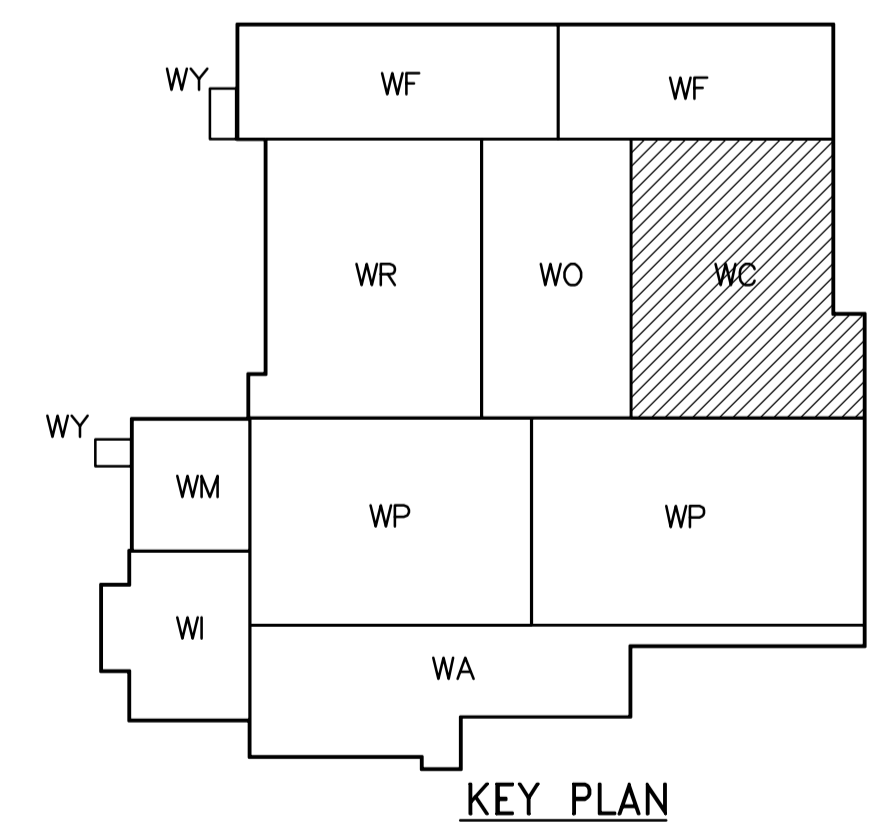

THIRD FLOOR PLAN
1:100

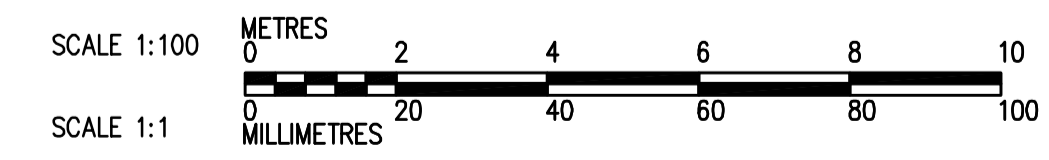

 Certificate of Authorization CH2M HILL Canada Ltd. No. 1441 Expiry: April 30, 2006	B.M. ELEV.	 Frederickson Cooper ARCHITECTS	 A Veolia International Ltd. Company	ENGINEER'S SEAL ORIGINAL SIGNED BY D.K. CUDDINGTON 2006/02/06	 THE CITY OF WINNIPEG WATER AND WASTE DEPARTMENT ENGINEERING DIVISION WATER TREATMENT PLANT CHEMICAL FEED SYSTEMS FOUNDATIONS AND CONCRETE STRUCTURES PLUMBING PIPE EMBEDS CHEMICAL AREA THIRD FLOOR PLAN	CITY FILE NUMBER
	00 ISSUED FOR TENDER 2006/02/03 SW NO. REVISIONS DATE BY DATE 2005/08/02 DATE 2006/02/08	DESIGNED BY JZ/SW CHECKED BY DL DRAWN BY JMcP APPROVED BY DJT SCALE: 1:100 RELEASED FOR CONSTRUCTION BY: R. SOROKOWSKI	CONSULTANT DRAWING NO. WC-H9132	SHEET OF CITY DRAWING NUMBER 1-0601C-A-H9132-001-00D		