


2 DETAIL
WC-M9111 1:50

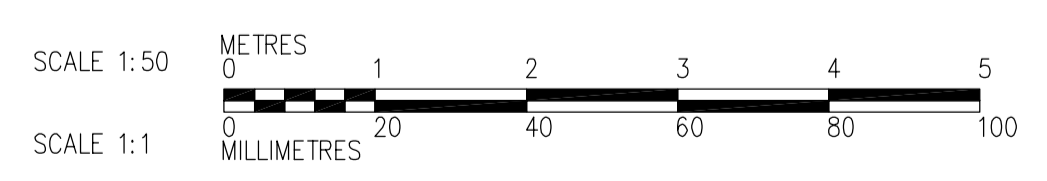

 Certificate of Authorization CH2M HILL Canada Ltd. No. 1441 Expiry: April 30, 2006	<table border="1"> <tr> <th>B.M.</th> <th>ELEV.</th> <th>DATE</th> <th>BY</th> </tr> <tr> <td> </td> <td> </td> <td> </td> <td> </td> </tr> </table>	B.M.	ELEV.	DATE	BY					 Frederickson Cooper ARCHITECTS	 A Veolia International Ltd. Company	ENGINEER'S SEAL	 THE CITY OF WINNIPEG WATER AND WASTE DEPARTMENT ENGINEERING DIVISION
		B.M.	ELEV.	DATE	BY								
DESIGNED BY: KS DRAWN BY: YFS SCALE: 1:50	CHECKED BY: NW APPROVED BY: DJT RELEASED FOR CONSTRUCTION BY: R. SOROKOWSKI DATE: 2006/02/08	ORIGINAL SIGNED BY: J.W. SINCLAIR DATE: 2006/02/06 CONSULTANT DRAWING NO.: WC-M9402	WATER TREATMENT PLANT CHEMICAL FEED SYSTEMS FOUNDATIONS AND CONCRETE STRUCTURES PROCESS MECHANICAL PIPE EMBEDS POLYMER AREA SECOND FLOOR PLAN DETAIL	CITY FILE NUMBER SHEET OF CITY DRAWING NUMBER 1-0601C-A-M9402-001-00D									