
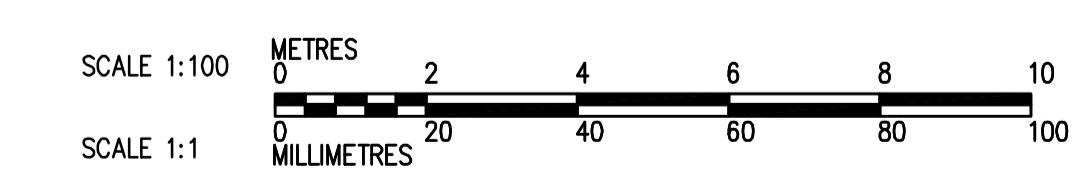


PARTIAL FIRST FLOOR PLAN
1:100

LOWER LEVEL PLAN
1:100

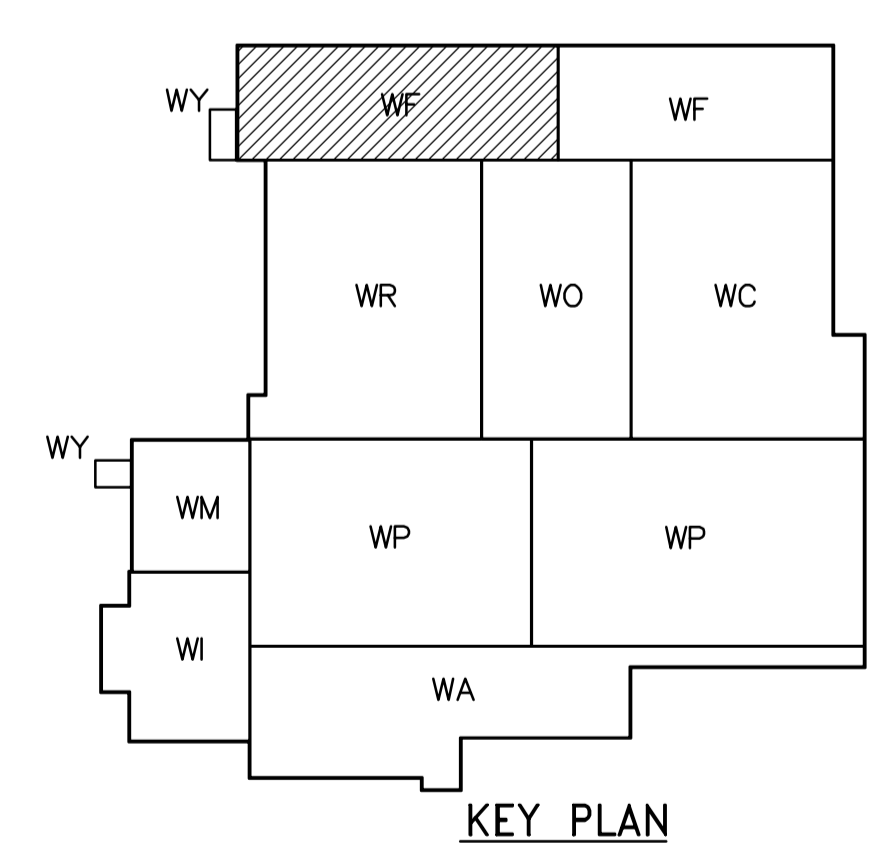

 Certificate of Authorization CH2M HILL Canada Ltd. No. 1441 Expiry: April 30, 2006	B.M. ELEV.	 Frederickson Cooper ARCHITECTS	 A Veolia International Ltd. Company	ENGINEER'S SEAL ORIGINAL SIGNED BY D.K. CUDDINGTON 2006/02/06	 THE CITY OF WINNIPEG WATER AND WASTE DEPARTMENT ENGINEERING DIVISION WATER TREATMENT PLANT FILTRATION FOUNDATIONS AND CONCRETE STRUCTURES PLUMBING PIPE EMBEDS FILTRATION AREA 1 LOWER LEVEL PLAN	CITY FILE NUMBER
	00 ISSUED FOR TENDER 2006/02/03 SW	DESIGNED BY JZ/SW CHECKED BY DL	CONSULTANT DRAWING NO. WF-H9104	SHEET OF		
	NO. REVISIONS DATE BY DATE 2005/08/02 DATE 2006/02/08	DRAWN BY JMcP APPROVED BY DJT	RELEASED FOR CONSTRUCTION BY: R. SOROKOWSKI	CITY DRAWING NUMBER 1-060F-A-H9104-001-00D		
		SCALE: 1:100	R. SOROKOWSKI			