
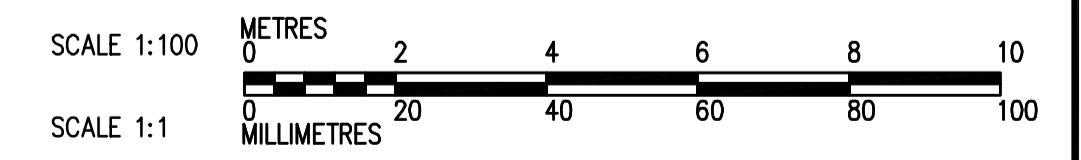


THIRD FLOOR PLAN
1:100

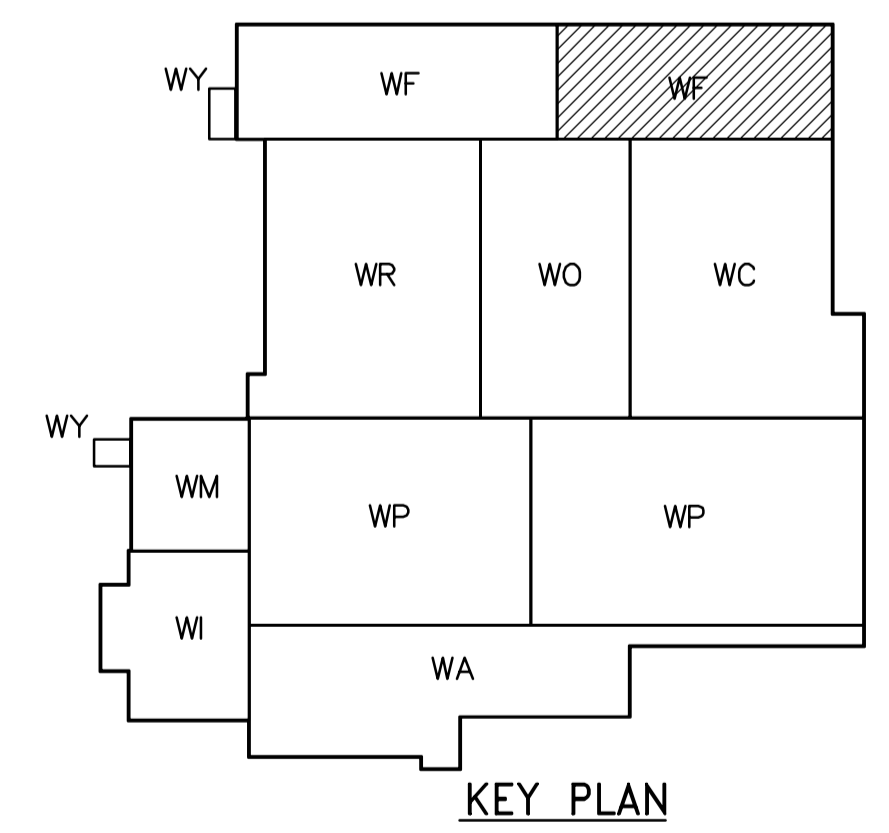

<p>APEGN Certificate of Authorization CH2M HILL Canada Ltd. No. 1441 Expiry: April 30, 2006</p>	<p>Frederickson Cooper ARCHITECTS</p>	<p>EarthTech A Veolia International Ltd. Company</p>	ENGINEER'S SEAL	<p>THE CITY OF WINNIPEG WATER AND WASTE DEPARTMENT ENGINEERING DIVISION</p>	CITY FILE NUMBER
			DESIGNED BY: JZ/SW CHECKED BY: DL DRAWN BY: JMcP APPROVED BY: DJT SCALE: 1:100 RELEASED FOR CONSTRUCTION BY: R. SOROKOWSKI		ORIGINAL SIGNED BY: D.K. CUDDINGTON DATE: 2006/02/06 CONSULTANT DRAWING NO.: WF-H9134
B.M. ELEV.		DESIGNED BY: JZ/SW CHECKED BY: DL DRAWN BY: JMcP APPROVED BY: DJT SCALE: 1:100 RELEASED FOR CONSTRUCTION BY: R. SOROKOWSKI		ORIGINAL SIGNED BY: D.K. CUDDINGTON DATE: 2006/02/06 CONSULTANT DRAWING NO.: WF-H9134	
NO. REVISIONS		DATE BY		DATE BY	
00 ISSUED FOR TENDER 2006/02/03 SW		DATE BY 2005/08/02		DATE BY 2006/02/08	