
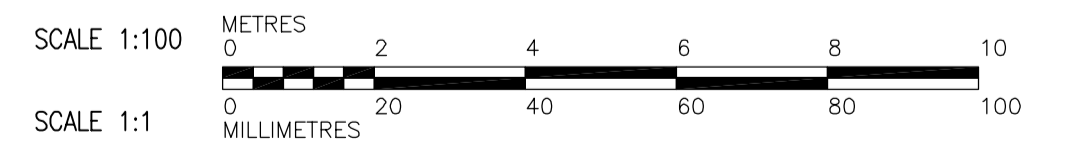


PLAN AT EL 234.400
1:100

NOTES:
1. ALUMINIUM GRATING SHOWN FOR INFORMATION ONLY.

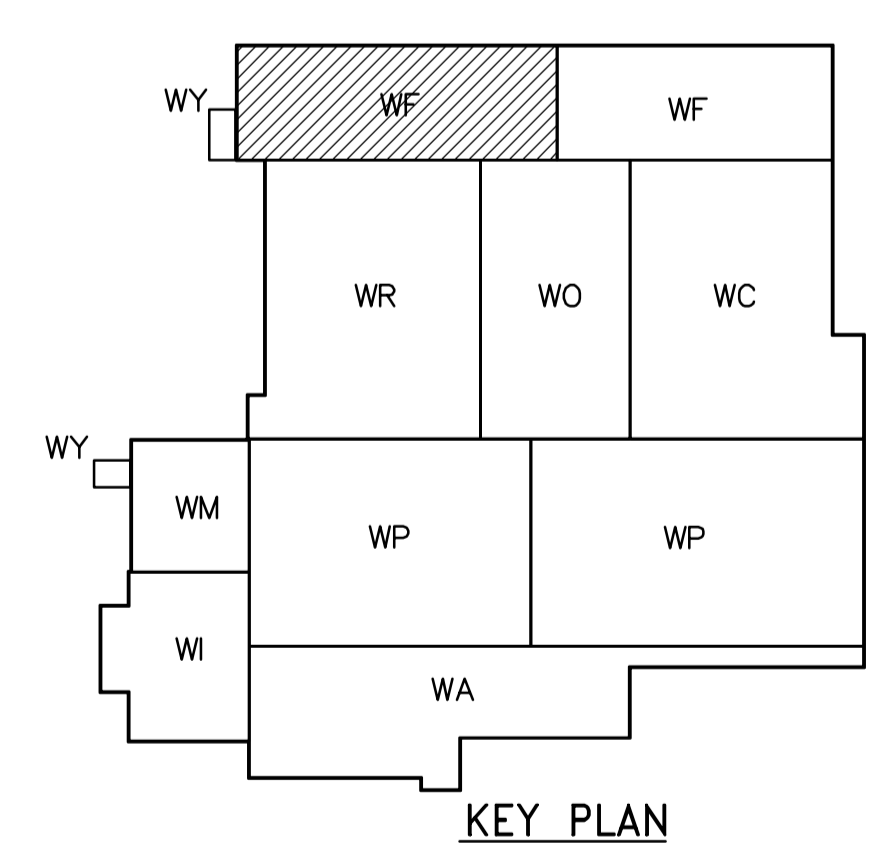

 APEGN Certificate of Authorization CH2M HILL Canada Ltd. No. 1441 Expiry: April 30, 2006	 Frederickson Cooper ARCHITECTS	 A Web International Ltd. Company	ENGINEER'S SEAL	 THE CITY OF WINNIPEG WATER AND WASTE DEPARTMENT ENGINEERING DIVISION	CITY FILE NUMBER	
			DESIGNED BY: KA CHECKED BY: AP DRAWN BY: PM APPROVED BY: DJT SCALE: 1:100 RELEASED FOR CONSTRUCTION BY: R. SOROKOWSKI DATE: 2005/08/10		ORIGINAL SIGNED BY: D. KRUGER DATE: 2006/02/06 CONSULTANT DRAWING NO.: WF-S0111	SHEET OF
00 ISSUED FOR TENDER 2006/02/03 KA NO. REVISIONS DATE BY			WATER TREATMENT PLANT FILTRATION FOUNDATIONS AND CONCRETE STRUCTURES STRUCTURAL FILTRATION AREA 1 FIRST FLOOR PLAN			CITY DRAWING NUMBER 1-060F-A-8011-001-00D