
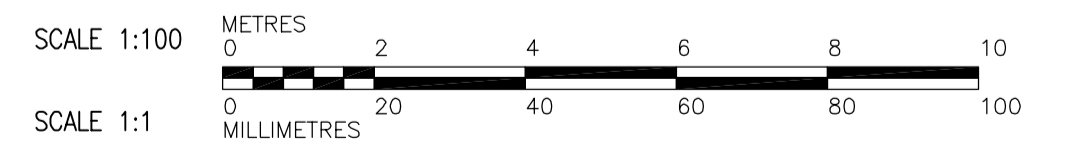


NOTES:
1. ALUMINIUM GRATING SHOWN FOR INFORMATION ONLY.

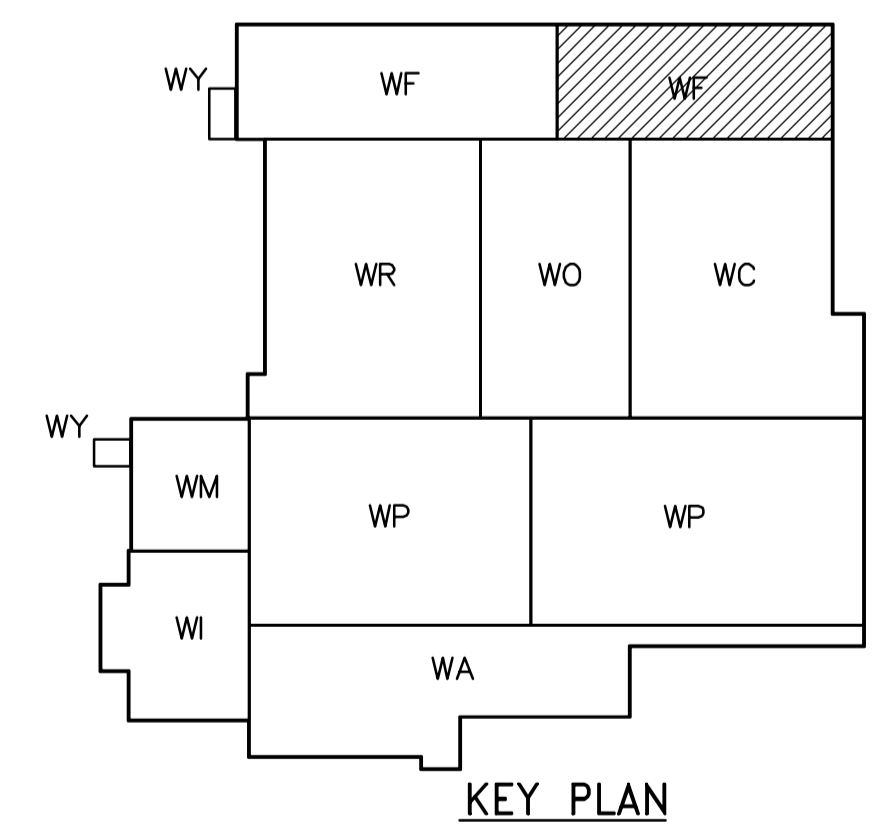

 Certificate of Authorization CH2M HILL Canada Ltd. No. 1441 Expiry: April 30, 2006	B.M. ELEV. <table border="1"> <tr><td> </td><td> </td><td> </td></tr> <tr><td> </td><td> </td><td> </td></tr> <tr><td> </td><td> </td><td> </td></tr> </table>										 Frederickson Cooper ARCHITECTS DESIGNED BY KA DRAWN BY PM SCALE: 1:100	 A Veolia International Ltd. Company CHECKED BY AP APPROVED BY DJT RELEASED FOR CONSTRUCTION BY: R. SOROKOWSKI	ENGINEER'S SEAL ORIGINAL SIGNED BY D. KRUGER 2006/02/06 CONSULTANT DRAWING NO. WF-S0112	 THE CITY OF WINNIPEG WATER AND WASTE DEPARTMENT ENGINEERING DIVISION WATER TREATMENT PLANT FILTRATION FOUNDATIONS AND CONCRETE STRUCTURES STRUCTURAL FILTRATION AREA 2 FIRST FLOOR PLAN	CITY FILE NUMBER SHEET OF CITY DRAWING NUMBER 1-0607-A-8012-001-00D
00 ISSUED FOR TENDER NO. REVISIONS	2006/02/03 DATE BY	KA DATE	2005/08/10 DATE	2006/02/08 DATE											