
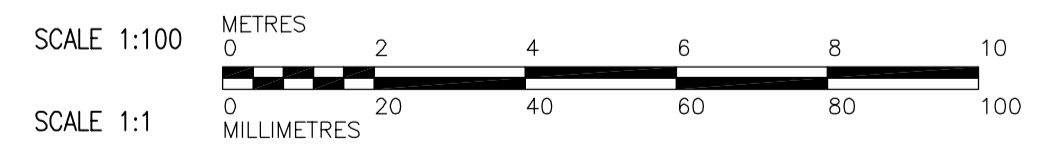


THIRD FLOOR PLAN AT EL 245.000  
1:100

NOTES:  
1. DESIGN LIVE LOAD IS 14.4 kPa

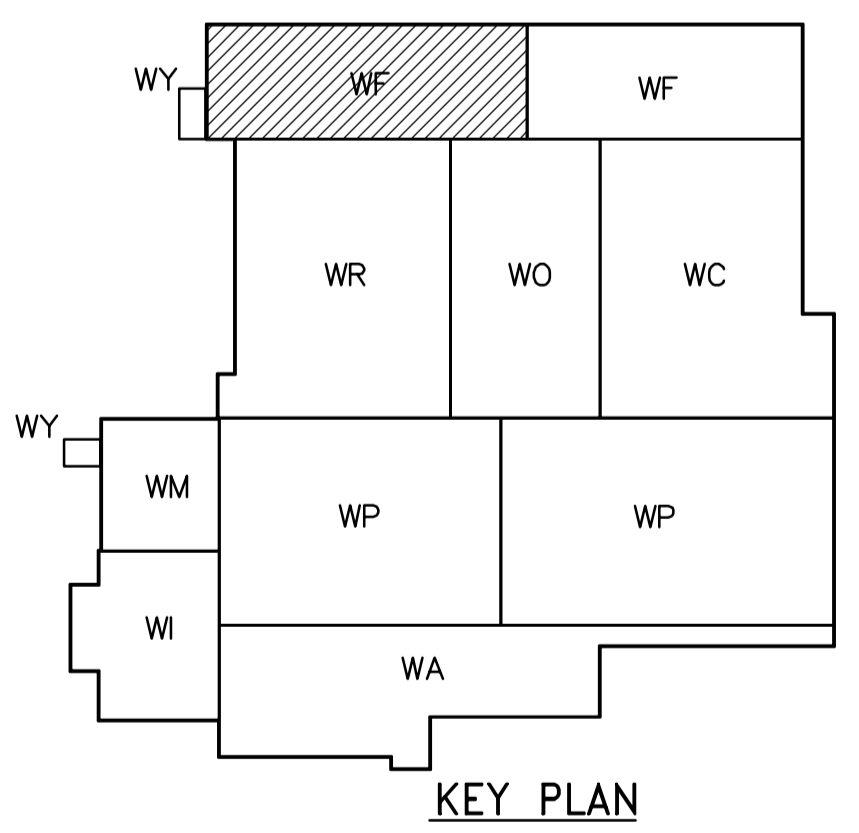

<p><b>APEGN</b> Certificate of Authorization CH2M HILL Canada Ltd. No. 1441 Expiry: April 30, 2006</p>	<p>Frederickson Cooper ARCHITECTS</p>	<p>EarthTech A Geo International Ltd. Company</p>	ENGINEER'S SEAL	<p><b>THE CITY OF WINNIPEG</b> WATER AND WASTE DEPARTMENT ENGINEERING DIVISION</p>		
			DESIGNED BY: KA		CHECKED BY: AP	ORIGINAL SIGNED BY: D. KRUGER
			DRAWN BY: PM		APPROVED BY: DJT	2006/02/06
			SCALE: 1:100		RELEASED FOR CONSTRUCTION BY: R. SOROKOWSKI	CONSULTANT DRAWING NO. WF-S0135
00 ISSUED FOR TENDER	2006/02/03	KA		<p>WATER TREATMENT PLANT FILTRATION FOUNDATIONS AND CONCRETE STRUCTURES</p> <p>STRUCTURAL FILTRATION AREA 1 THIRD FLOOR REINFORCING PLAN</p>		
NO. REVISIONS	DATE	BY	DATE	<p>CITY FILE NUMBER</p> <p>SHEET OF</p> <p>CITY DRAWING NUMBER</p> <p><b>1-0607-A-50135-001-00D</b></p>		