


- NOTES:
- SEE DWGS WM-S0111 TO WM-S0146 FOR SLAB REINFORCING, UNO.
 - FOR BEAM AND COLUMN SCHEDULES REFER TO DWG WM-S0515
 - FOR TYPICAL WALL CORNER REINF SEE 4

A SECTION
 WM-F0105 1:50
 WM-S0111
 WM-S0146
 WM-S0141

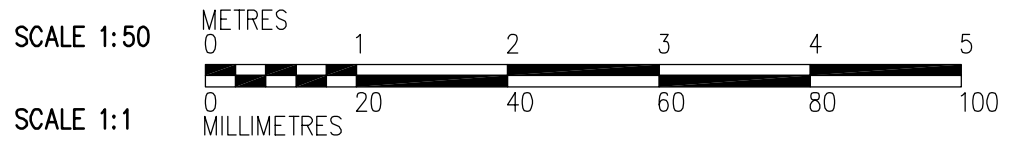

 Certificate of Authorization CH2M HILL Canada Ltd. No. 1441 Expiry: April 30, 2006	B.M. ELEV. <table border="1"> <tr><td> </td><td> </td><td> </td><td> </td></tr> <tr><td> </td><td> </td><td> </td><td> </td></tr> <tr><td> </td><td> </td><td> </td><td> </td></tr> <tr><td> </td><td> </td><td> </td><td> </td></tr> </table>																	 Frederickson Cooper ARCHITECTS DESIGNED BY EL DRAWN BY RL SCALE: 1:50 00 ISSUED FOR TENDER 2006/02/03 EL NO. REVISIONS DATE BY DATE 2005/09/16 DATE 2006/02/08	 A Geo International Ltd. Company CHECKED BY AP APPROVED BY DJT RELEASED FOR CONSTRUCTION BY: R. SOROKOWSKI	ENGINEER'S SEAL ORIGINAL SIGNED BY D. KRUGER 2006/02/06 CONSULTANT DRAWING NO. WM-S0201	 THE CITY OF WINNIPEG WATER AND WASTE DEPARTMENT ENGINEERING DIVISION WATER TREATMENT PLANT GENERAL PLANT SERVICES/MISCELLANEOUS FOUNDATIONS AND CONCRETE STRUCTURES STRUCTURAL ELECTRICAL ROOM SECTION	CITY FILE NUMBER
SHEET OF	CITY DRAWING NUMBER 1-060M-A-0201-001-00D																					