


- NOTES:**
1. WATER PROOFING FROM EL. 234.500 TO 237.000 ALL AROUND.
  2. SLIP SHEET AND PROTECTION BOARD FROM EL. 234.500 TO 237.000 ON WEST WALL, NORTH WALL, AND EAST WALL OF FIRE PUMP PIT, WEST AND NORTH FOUNDATION WALL.
  3. INSULATION FROM EL. 234.500 TO 237.000 ON WEST WALL AND NORTH WALL.
  4. SEE DWGS WM-S0111 TO WM-S0146 FOR SLAB REINFORCING, UNO.
  5. SEE DWG WM-S0515 FOR BEAM AND COLUMN SCHEDULES.
  6. FOR TYPICAL WALL CORNER REINF SEE 4 WB-S0452
  7. PROVIDE WATERPROOFING, SLIPSHEET AND PROTECTION BOARD ON WALLS AND TOP SLAB OF CONDUIT.

**LEGEND:**

NOT IN CONTRACT

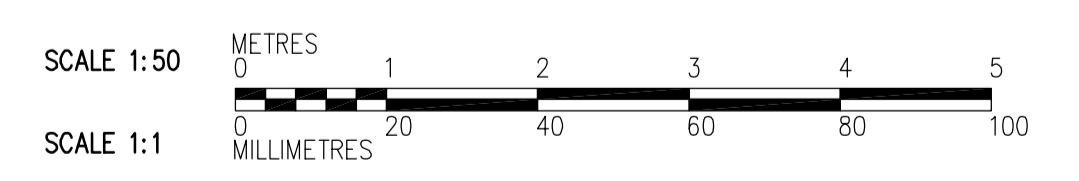

 Certificate of Authorization CH2M HILL Canada Ltd. No. 1441 Expiry: April 30, 2006	 Frederickson Cooper ARCHITECTS	 A Geo International Ltd. Company	B.M. ELEV.	ENGINEER'S SEAL ORIGINAL SIGNED BY D. KRUGER 2006/02/06	 THE CITY OF WINNIPEG WATER AND WASTE DEPARTMENT ENGINEERING DIVISION WATER TREATMENT PLANT GENERAL PLANT SERVICES/MISCELLANEOUS FOUNDATIONS AND CONCRETE STRUCTURES STRUCTURAL ELECTRICAL ROOM SECTION	CITY FILE NUMBER
			DESIGNED BY: MH CHECKED BY: AP DRAWN BY: RL APPROVED BY: DJT SCALE: 1:50 RELEASED FOR CONSTRUCTION BY: R. SOROKOWSKI	CONSULTANT DRAWING NO. WM-S0203		SHEET OF
00 ISSUED FOR TENDER 2006/02/03 MH		NO. REVISIONS DATE BY DATE 2005/09/16 DATE 2006/02/08				