


- NOTES:
- SEE DWGS WM-S0111 TO WM-S0146 FOR SLAB REINFORCING, UNO.
 - SEE DWG WM-S0515 FOR BEAM AND COLUMN SCHEDULES.
 - FOR TYPICAL WALL CORNER REINF SEE 4 WB-S0452

F SECTION
WM-F0105 1:50
WM-S0111
WM-S0141
WM-S0146

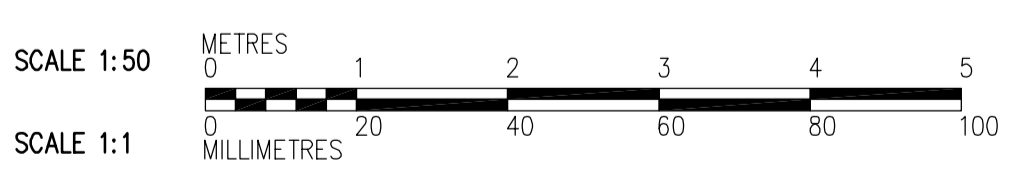

 Certificate of Authorization CH2M HILL Canada Ltd. No. 1441 Expiry: April 30, 2006	B.M. ELEV.	 Frederickson Cooper ARCHITECTS	 A Neo International Ltd. Company	ENGINEER'S SEAL ORIGINAL SIGNED BY D. KRUGER 2006/02/06	 THE CITY OF WINNIPEG WATER AND WASTE DEPARTMENT ENGINEERING DIVISION WATER TREATMENT PLANT GENERAL PLANT SERVICES/MISCELLANEOUS FOUNDATIONS AND CONCRETE STRUCTURES STRUCTURAL ELECTRICAL ROOM SECTION	CITY FILE NUMBER
	00 ISSUED FOR TENDER 2006/02/03 EL NO. REVISIONS DATE BY	DESIGNED BY EL DRAWN BY RL SCALE: 1:50 0000 2005/12/29	CHECKED BY AP APPROVED BY DJT RELEASED FOR CONSTRUCTION BY: R. SOROKOWSKI 2006/02/08	CONSULTANT DRAWING NO. WM-S0204		SHEET OF CITY DRAWING NUMBER 1-0601M-A-S0204-001-00D