





M SECTION - OZONE COOLING WATER RETURN
WP-M9105 1:50

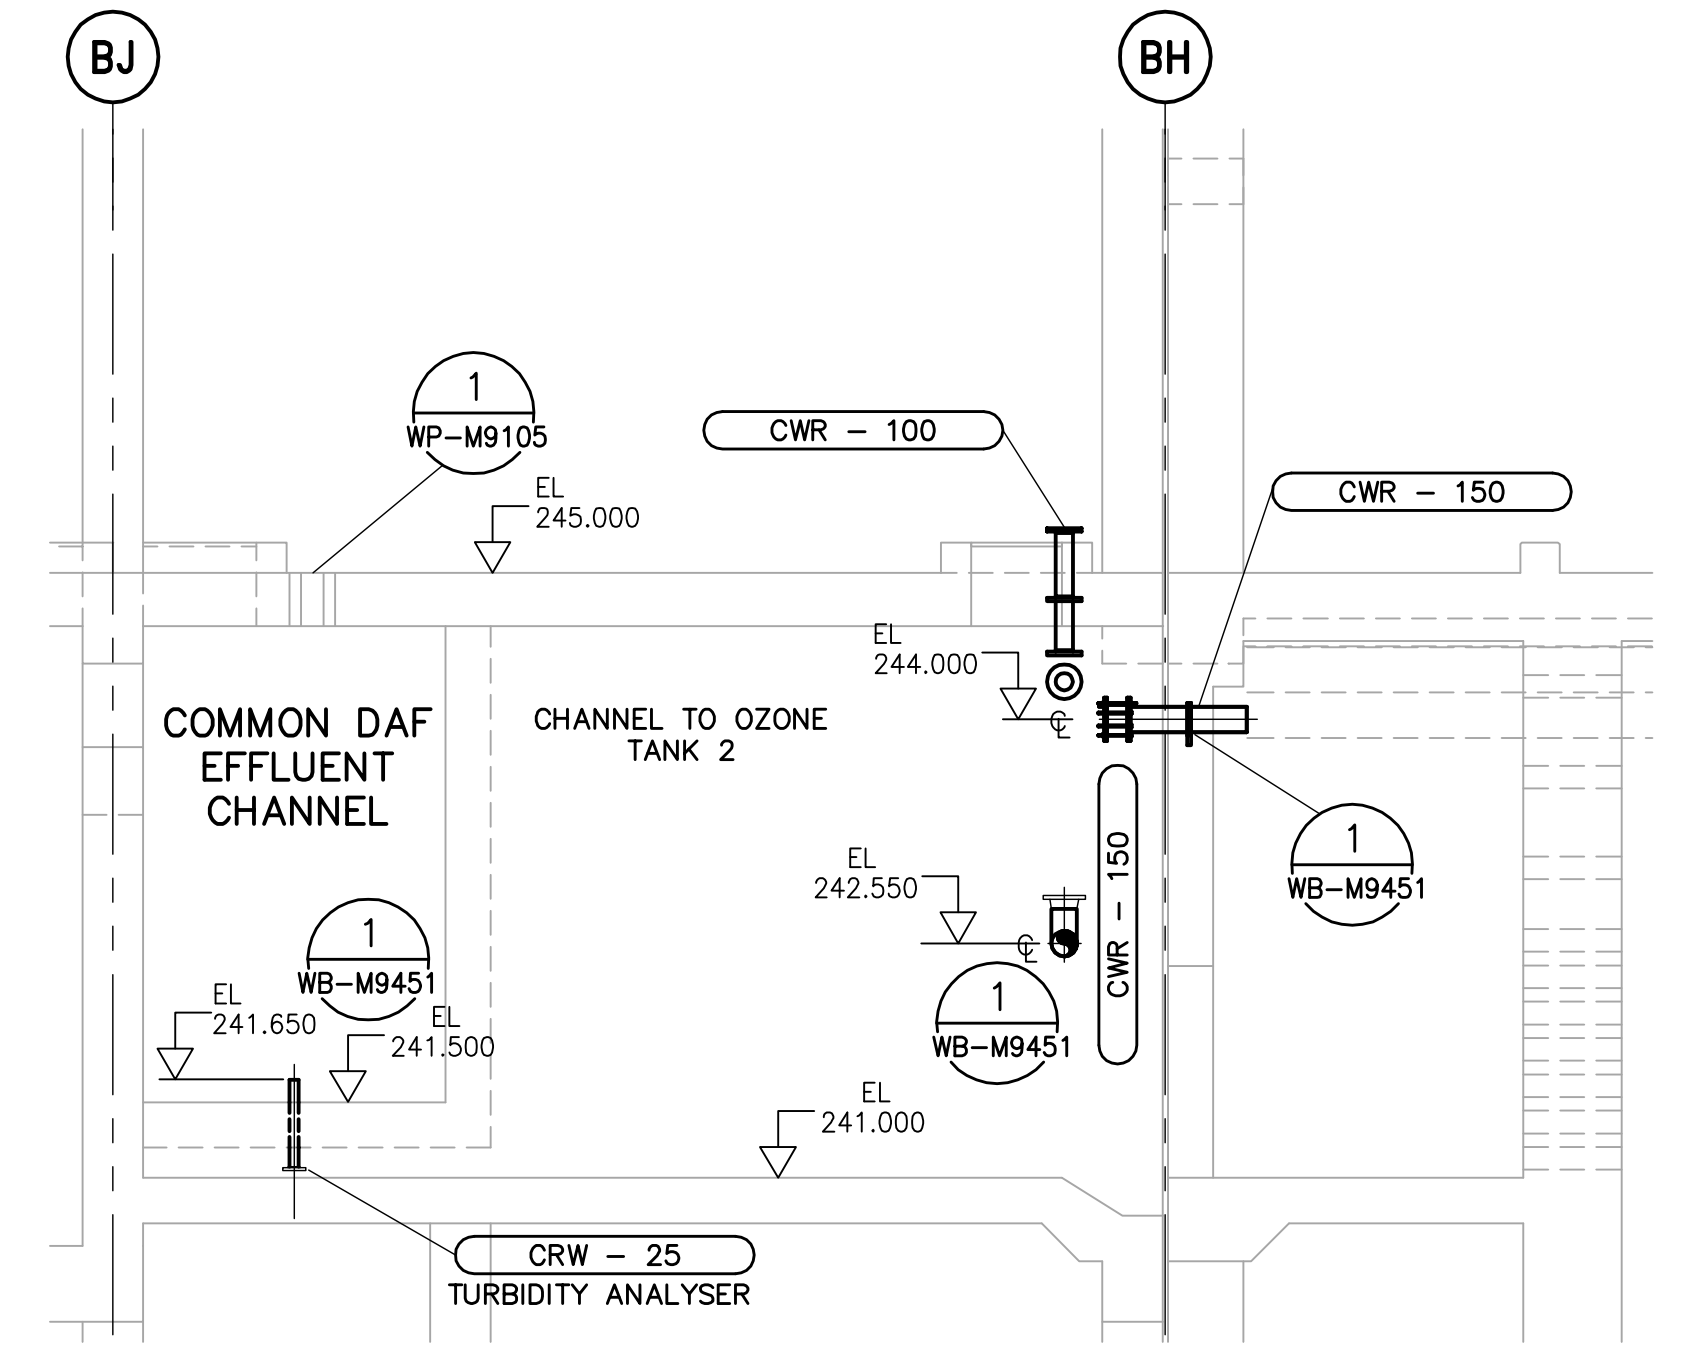


N SECTION - OZONE COOLING WATER RETURN
WP-M9105 1:50

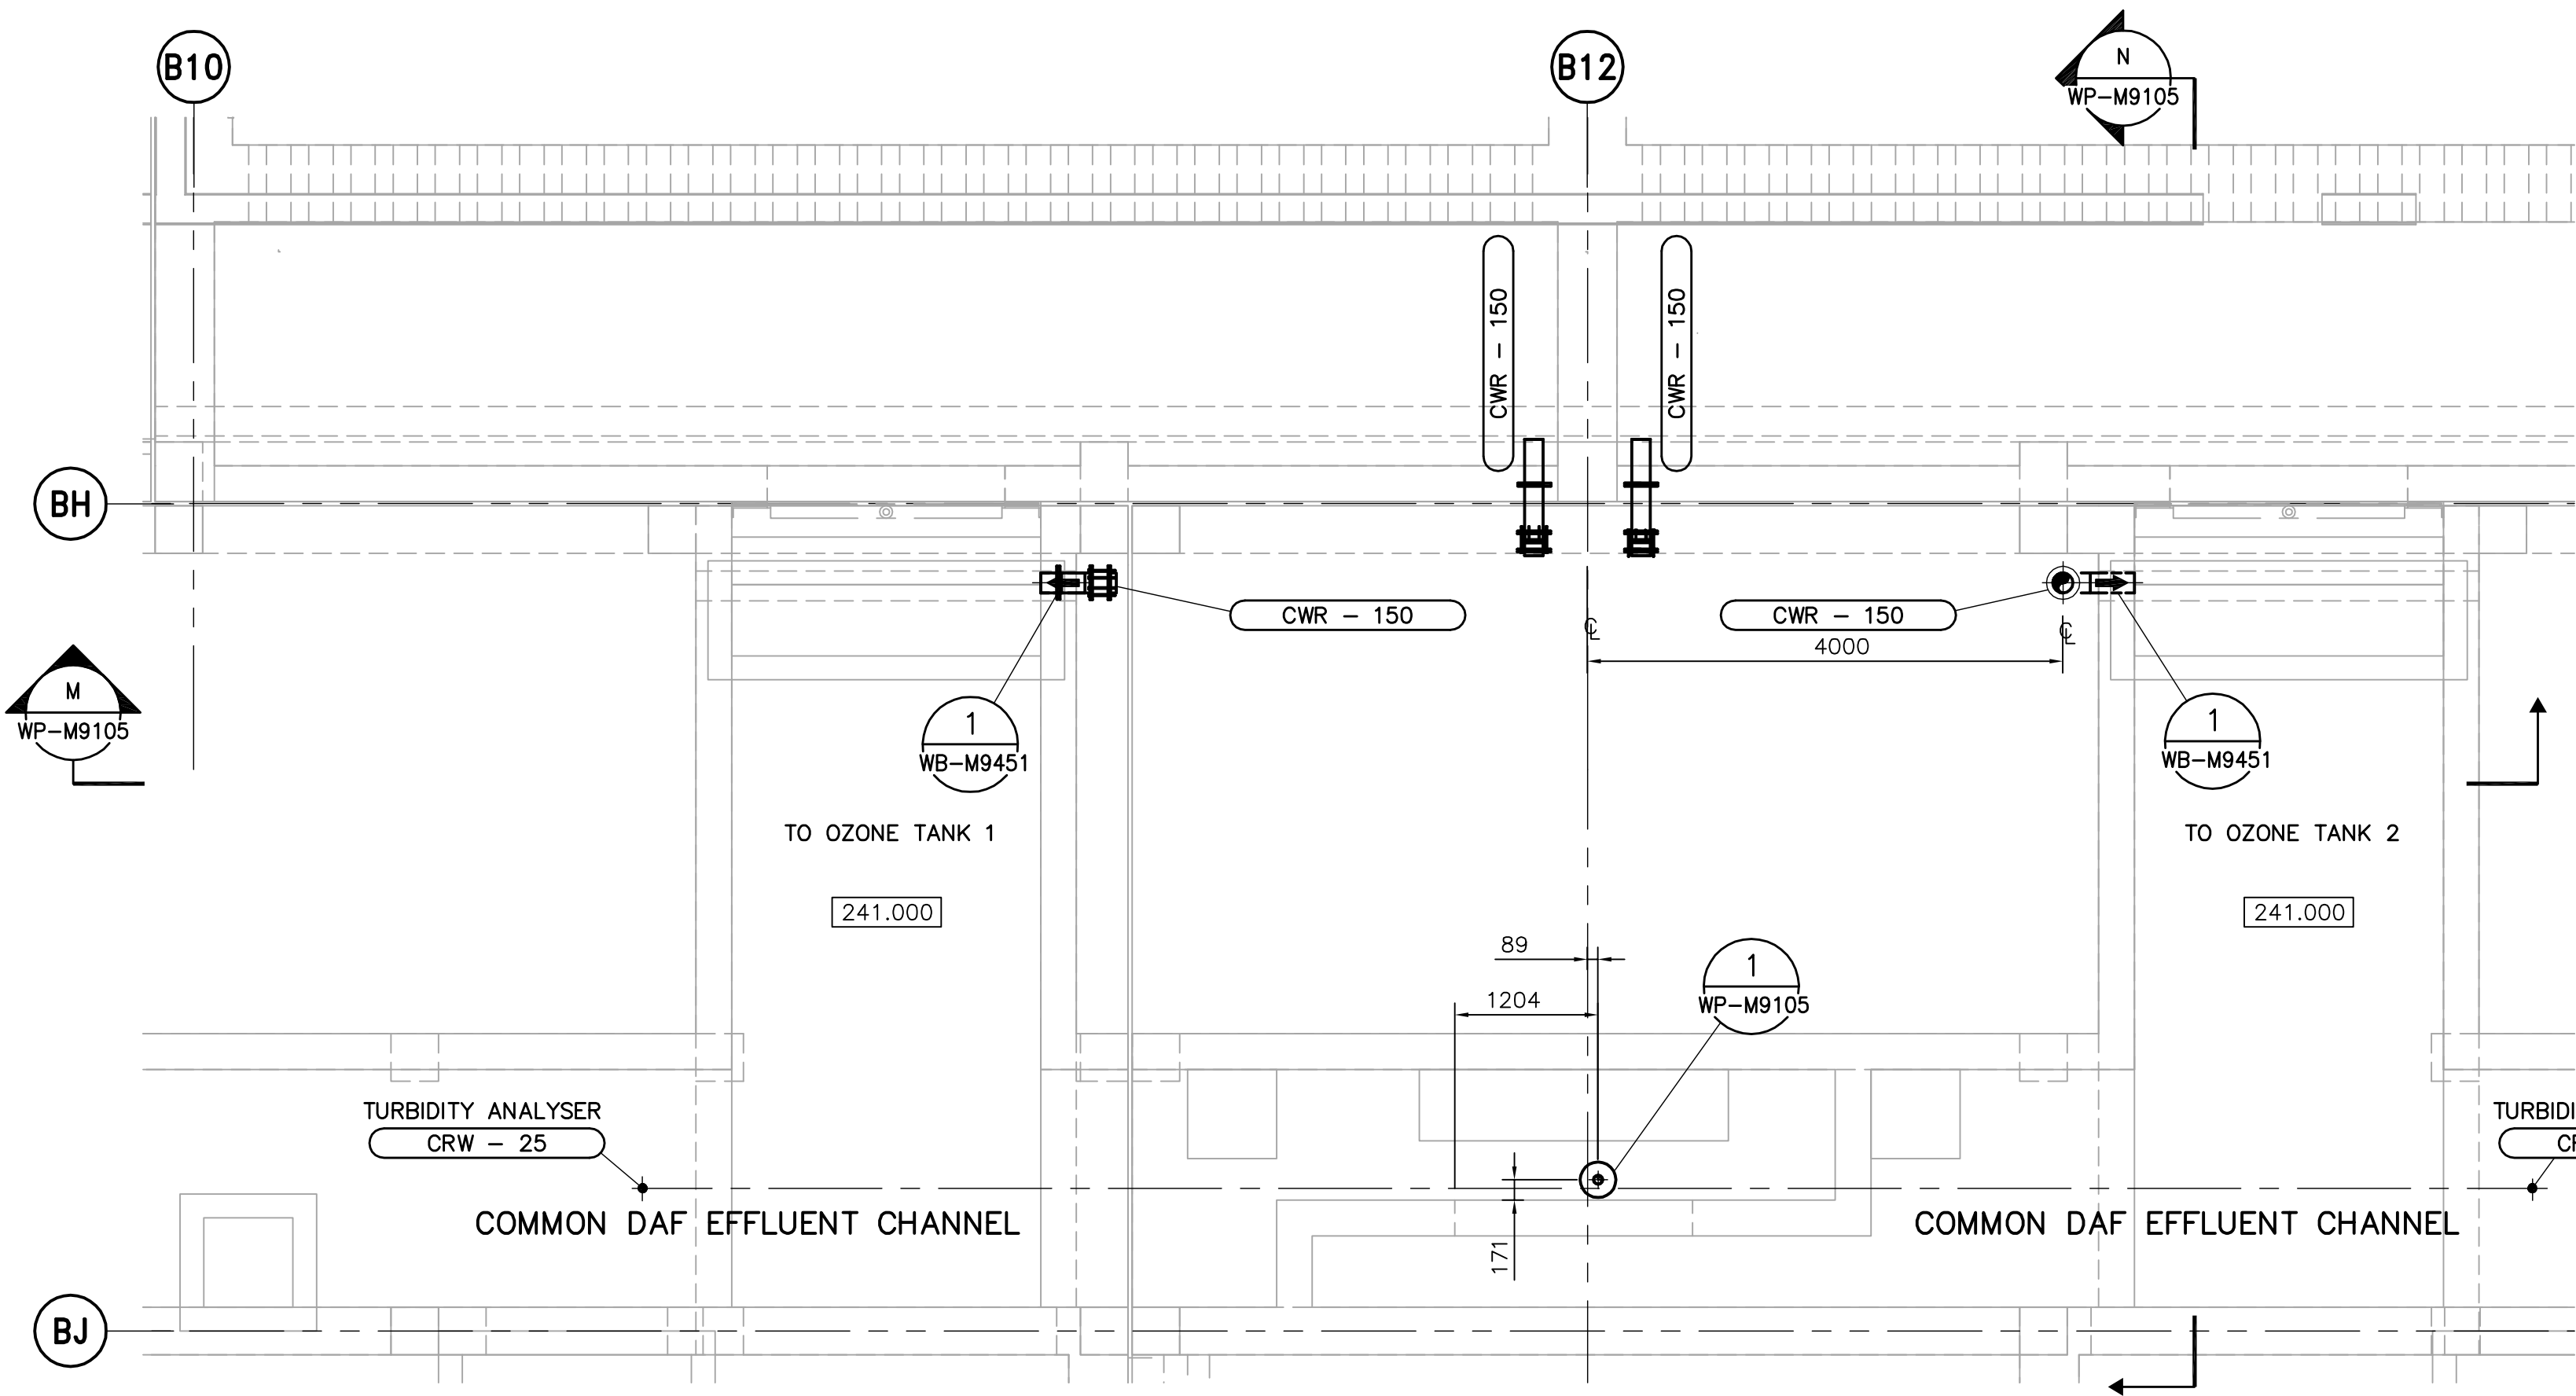


21 THIRD FLOOR PLAN - OZONE COOLING WATER RETURN
WP-M9105 1:50

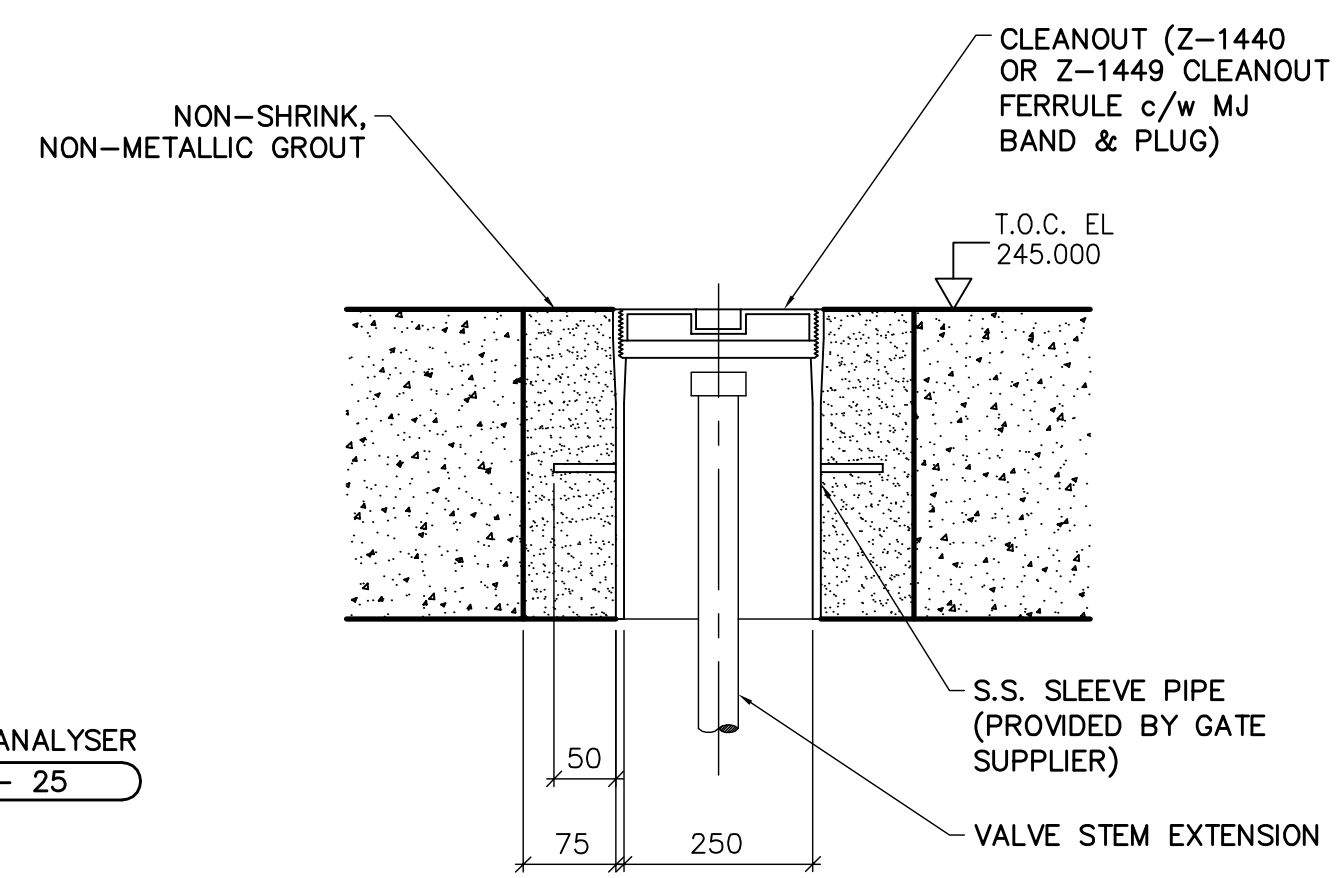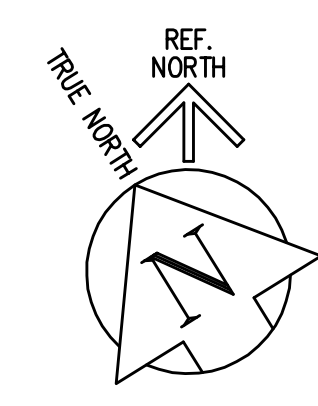

1 DETAIL - CAST IN PLACE FLOOR BOX
WP-M9105 NTS
WP-M9103

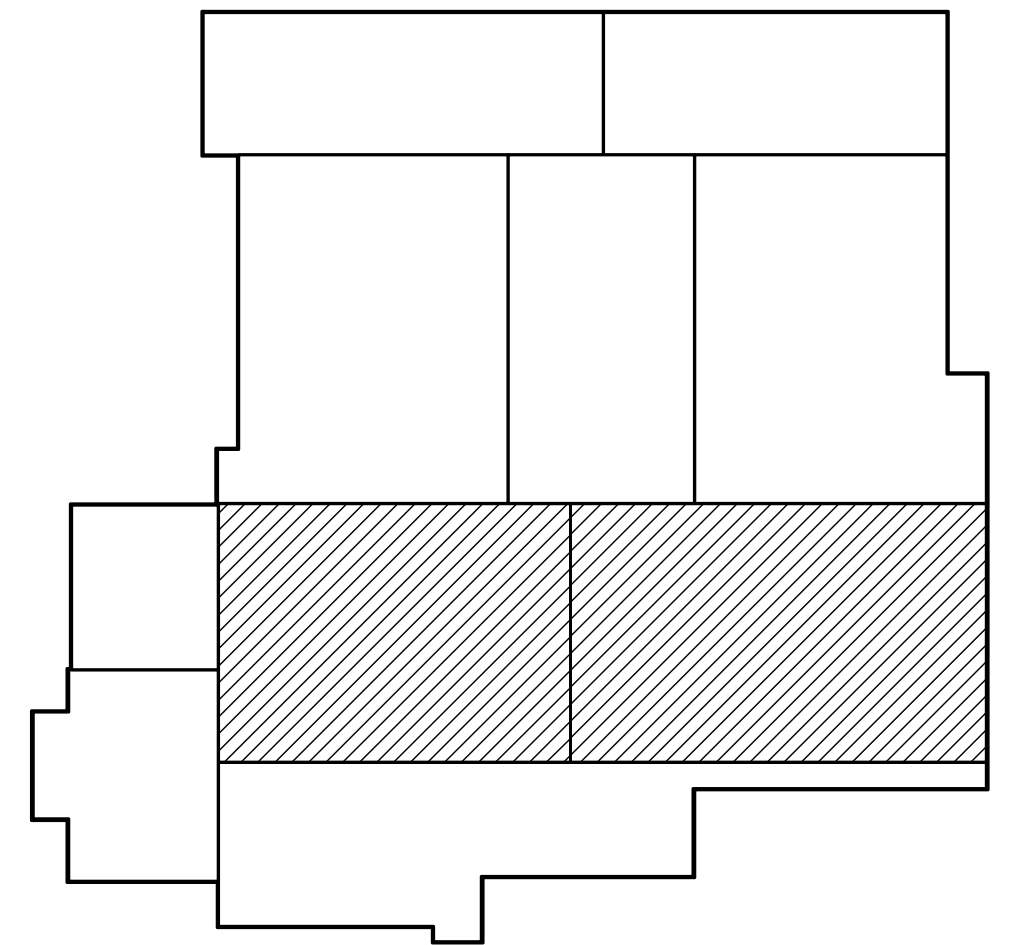

KEY PLAN

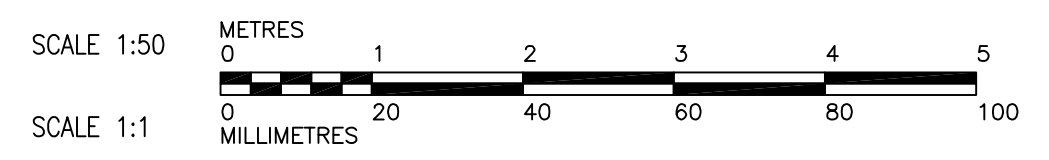

<p>Certificate of Authorization Earth Tech Canada Inc. No. 730 Expiry: April 30, 2006</p>	<p>Frederickson Cooper ARCHITECTS</p>	<p>A Tyco International Ltd. Company</p>	ENGINEER'S SEAL	<p>THE CITY OF WINNIPEG WATER AND WASTE DEPARTMENT ENGINEERING DIVISION</p>		
			DESIGNED BY: KAS		CHECKED BY: SRB	ORIGINAL SIGNED BY: S.R. BILEVICIUS
			DRAWN BY: PL		APPROVED BY: DJT	2006/02/07
			SCALE: AS SHOWN		RELEASED FOR CONSTRUCTION BY: R. SOROKOWSKI	CONSULTANT DRAWING NO. WP-M9105
NO. REVISIONS	DATE	DATE	DATE	<p>WATER TREATMENT PLANT FLOCCULATION AND DAF FOUNDATIONS AND CONCRETE STRUCTURES</p> <p>PIPE EMBEDS THIRD FLOOR PLAN AND SECTIONS OZONE COOLING WATER RETURN</p>		