 




- NOTES:**
- FOR BEAM AND COLUMN SCHEDULE SEE DWG WP-S0515.
 - PC 'X' - DENOTES PILE CAP TYPE, SEE DWG WP-S0401 FOR DETAILS.
 - ENCASE ALL PIPING UNDER BUILDING IN CONCRETE.




REBAR LEGEND:
 ——— TOP BARS
 - - - - - BOTTOM BARS

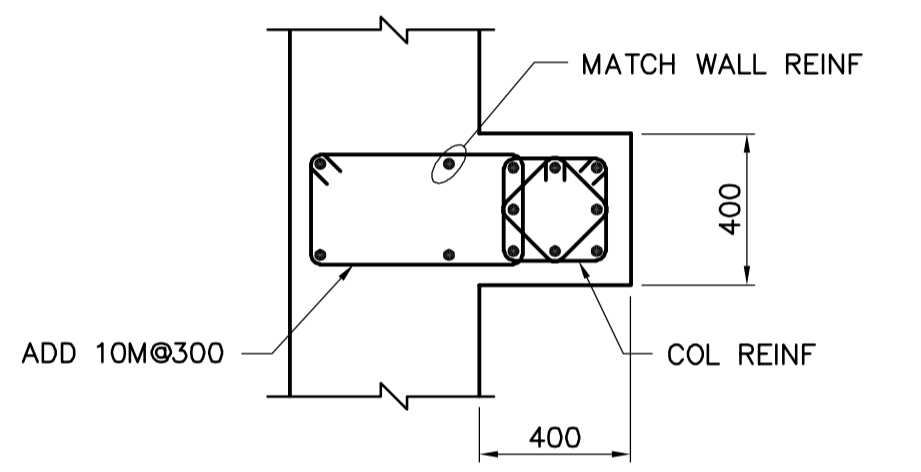

1 - 1:20
DETAIL

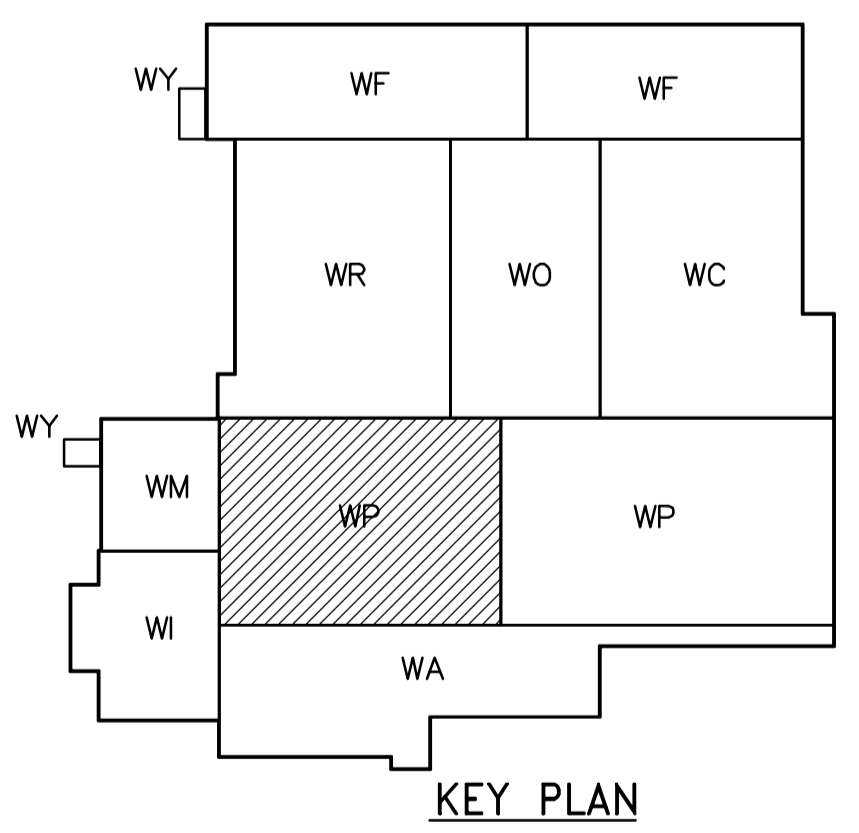

KEY PLAN

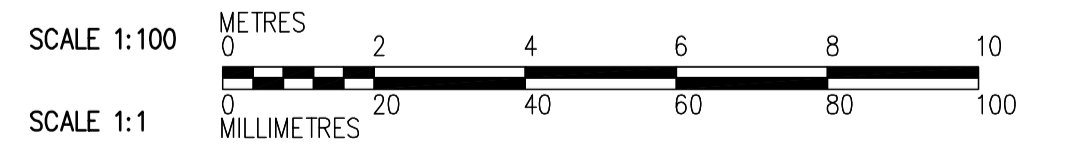

FIRST FLOOR PLAN
1:100

 Certificate of Authorization CH2M HILL Canada Ltd. No. 1441 Expiry: April 30, 2006	B.M. ELEV.	 Frederickson Cooper ARCHITECTS	 A Veolia International Ltd. Company	ENGINEER'S SEAL ORIGINAL SIGNED BY D. KRUGER 2006/02/06	 THE CITY OF WINNIPEG WATER AND WASTE DEPARTMENT ENGINEERING DIVISION WATER TREATMENT PLANT FLOCCULATION AND DAF FOUNDATIONS AND CONCRETE STRUCTURES STRUCTURAL FLOC/DAF AREA 1 FIRST FLOOR PLAN	CITY FILE NUMBER
	00 ISSUED FOR TENDER 2006/02/03 RZ	DESIGNED BY RZ CHECKED BY AP DRAWN BY RL APPROVED BY DJT SCALE: 1:100 RELEASED FOR CONSTRUCTION BY: R. SOROKOWSKI	CONSULTANT DRAWING NO. WP-S0111	SHEET OF		
	NO. REVISIONS DATE BY DATE 2005/06/28 DATE 2006/02/08	CITY DRAWING NUMBER 1-060P-A-8011-001-000				