
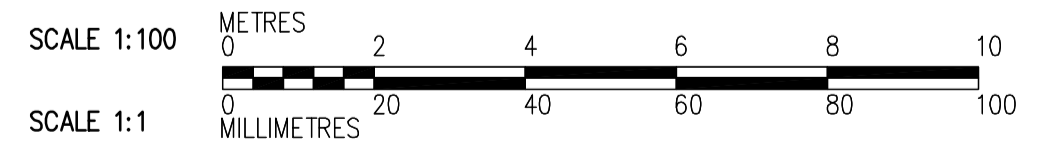


NOTES:
 1. FOR BEAM AND COLUMN SCHEDULE SEE DWG WP-S0515.

REBARS LEGEND:
 ——— TOP BARS
 - - - - - BOTTOM BARS

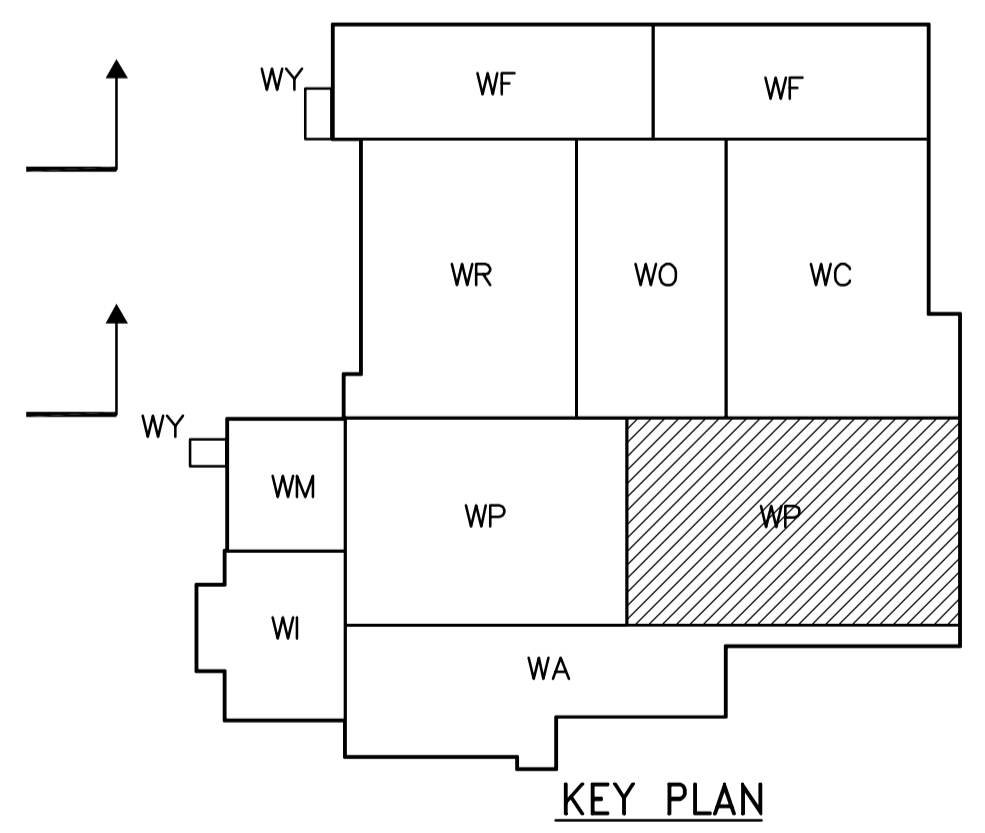

THIRD FLOOR PLAN
 1:100

 Certificate of Authorization CH2M HILL Canada Ltd. No. 1441 Expiry: April 30, 2006	B.M. ELEV.	 Frederickson Cooper ARCHITECTS	 A Veolia International Ltd. Company	ENGINEER'S SEAL ORIGINAL SIGNED BY D. KRUGER 2006/02/06	 THE CITY OF WINNIPEG WATER AND WASTE DEPARTMENT ENGINEERING DIVISION WATER TREATMENT PLANT FLOCCULATION AND DAF FOUNDATIONS AND CONCRETE STRUCTURES STRUCTURAL FLOC/DAF AREA 2 THIRD FLOOR PLAN	CITY FILE NUMBER
	00 ISSUED FOR TENDER 2006/02/03 RZ NO. REVISIONS DATE BY	DESIGNED BY RZ DRAWN BY RL SCALE: 1:100	CHECKED BY AP APPROVED BY DJT RELEASED FOR CONSTRUCTION BY: R. SOROKOWSKI	CONSULTANT DRAWING NO. WP-S0132		SHEET OF CITY DRAWING NUMBER 1-060P-A-0012-001-00D