


**D SECTION**  
WP-F0105 1:50

WP-S0121, WP-S0131  
WP-S0141, WP-S0146

- NOTES:**
- SEE DWGS WP-S0111 TO WP-S0132 FOR SLAB REINFORCING AND WALL ADDITIONAL REBARS, UNO.
  - SEE DWG WP-S0515 FOR BEAM AND COLUMN SCHEDULES.

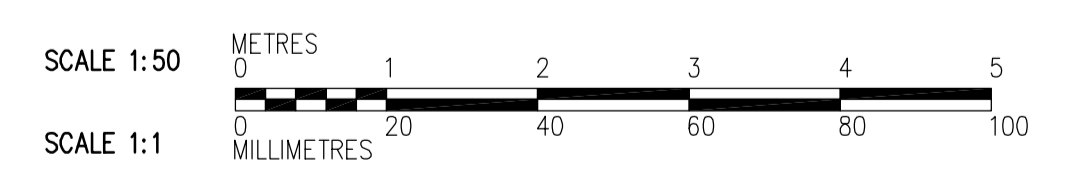

 <b>Certificate of Authorization</b> CH2M HILL Canada Ltd. No. 1441 Expiry: April 30, 2006	B.M. ELEV.	 Frederickson Cooper ARCHITECTS	 A Geo International Ltd. Company	ENGINEER'S SEAL	 <b>THE CITY OF WINNIPEG</b> WATER AND WASTE DEPARTMENT ENGINEERING DIVISION WATER TREATMENT PLANT FLOCCULATION AND DAF FOUNDATIONS AND CONCRETE STRUCTURES STRUCTURAL FLOC/DAF AREA 1 SECTION	CITY FILE NUMBER
	DESIGNED BY: RZ			CHECKED BY: AP		ORIGINAL SIGNED BY: D. KRUGER
	DRAWN BY: RL	APPROVED BY: DJT	2006/02/06	CITY DRAWING NUMBER		
	SCALE: 1:50	RELEASED FOR CONSTRUCTION BY: R. SOROKOWSKI	CONSULTANT DRAWING NO. WP-S0205	<b>1-060P-A-S0205-001-00D</b>		
00 ISSUED FOR TENDER	2006/02/03 RZ	DATE: 2005/07/27	DATE: 2006/02/08			