


- NOTES:**
- SEE DWGS WP-S0111 TO WP-S0132 FOR SLAB REINFORCING AND WALL ADDITIONAL REBARS, UNO.
 - SEE DWG WP-S0515 FOR BEAM AND COLUMN SCHEDULES.

E SECTION
WP-F0106 1:50

WP-S0122, WP-S0132
WP-S0142, WP-S0147

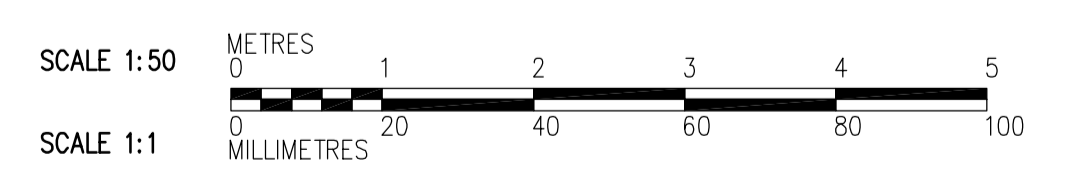

 Certificate of Authorization CH2M HILL Canada Ltd. No. 1441 Expiry: April 30, 2006	B.M. ELEV.	 Frederickson Cooper ARCHITECTS	 A Veolia International Ltd. Company	ENGINEER'S SEAL ORIGINAL SIGNED BY D. KRUGER 2006/02/06 CONSULTANT DRAWING NO. WP-S0208	 THE CITY OF WINNIPEG WATER AND WASTE DEPARTMENT ENGINEERING DIVISION WATER TREATMENT PLANT FLOCCULATION AND DAF FOUNDATIONS AND CONCRETE STRUCTURES STRUCTURAL FLOC/DAF AREA 2 SECTION	CITY FILE NUMBER
	DESIGNED BY: RZ CHECKED BY: AP					SHEET OF
	DRAWN BY: RL APPROVED BY: DJT	CITY DRAWING NUMBER				
	SCALE: 1:50 RELEASED FOR CONSTRUCTION BY: R. SOROKOWSKI	DATE: 2005/07/27 DATE: 2006/02/08	1-060P-A-0208-001-00D			
00 ISSUED FOR TENDER NO. REVISIONS	DATE: 2006/02/03 BY: RZ					