


**F SECTION**  
 WP-F0105 1:50  
 WP-S0121, WP-S0131  
 WP-S0141, WP-S0146

- NOTES:**
- SEE DWGS WP-S0111 TO WP-S0132 FOR SLAB REINFORCING AND WALL ADDITIONAL REBARS, UNO.
  - SEE DWG WP-S0515 FOR BEAM AND COLUMN SCHEDULES.

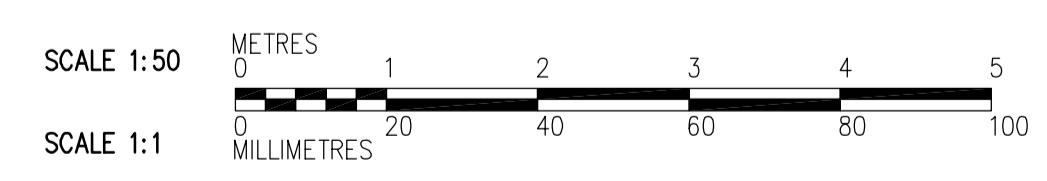

 Certificate of Authorization CH2M HILL Canada Ltd. No. 1441 Expiry: April 30, 2006	 Frederickson Cooper ARCHITECTS	 A Web International Ltd. Company	ENGINEER'S SEAL  ORIGINAL SIGNED BY D. KRUGER  2006/02/06	 THE CITY OF WINNIPEG WATER AND WASTE DEPARTMENT ENGINEERING DIVISION  WATER TREATMENT PLANT FLOCCULATION AND DAF FOUNDATIONS AND CONCRETE STRUCTURES  STRUCTURAL FLOC/DAF AREA 1 SECTION	CITY FILE NUMBER  SHEET OF
			CONSULTANT DRAWING NO. WP-S0209		CITY DRAWING NUMBER 1-060P-A-S0209-001-00D
B.M. ELEV.		DESIGNED BY: RZ CHECKED BY: AP DRAWN BY: CA APPROVED BY: DJT SCALE: 1:50 RELEASED FOR CONSTRUCTION BY: R. SOROKOWSKI	NO. REVISIONS    DATE    BY    DATE    2005/11/01    DATE    2006/02/08		