




NORTH ELEVATION
SCALE : 1:50

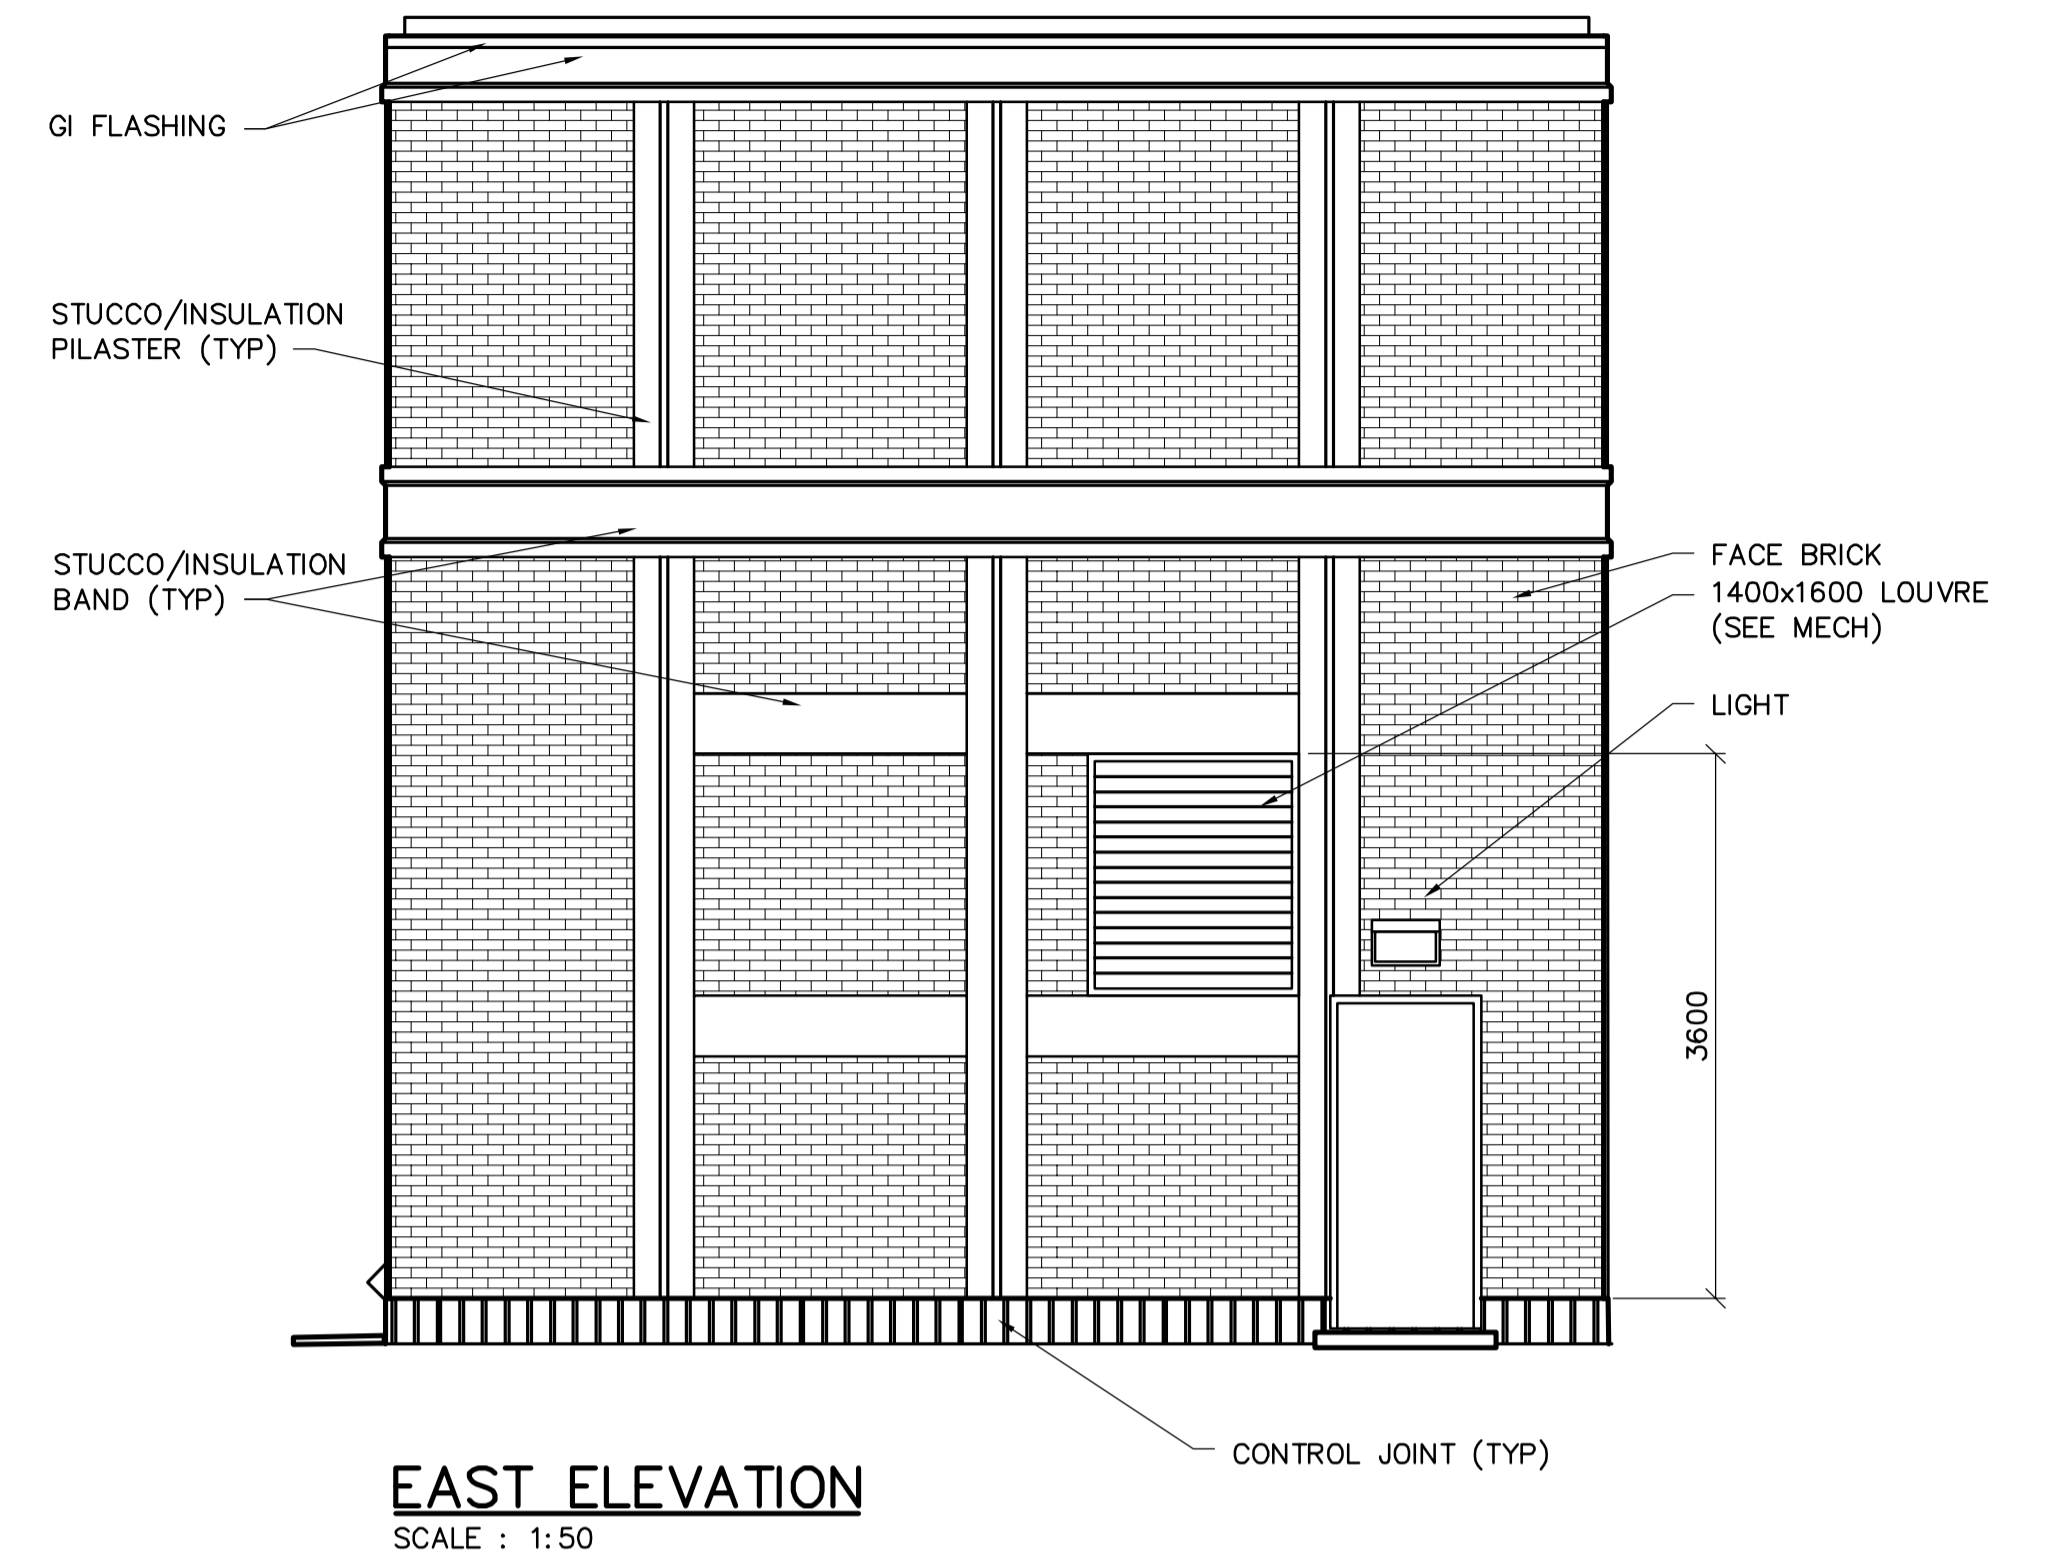

EAST ELEVATION
SCALE : 1:50

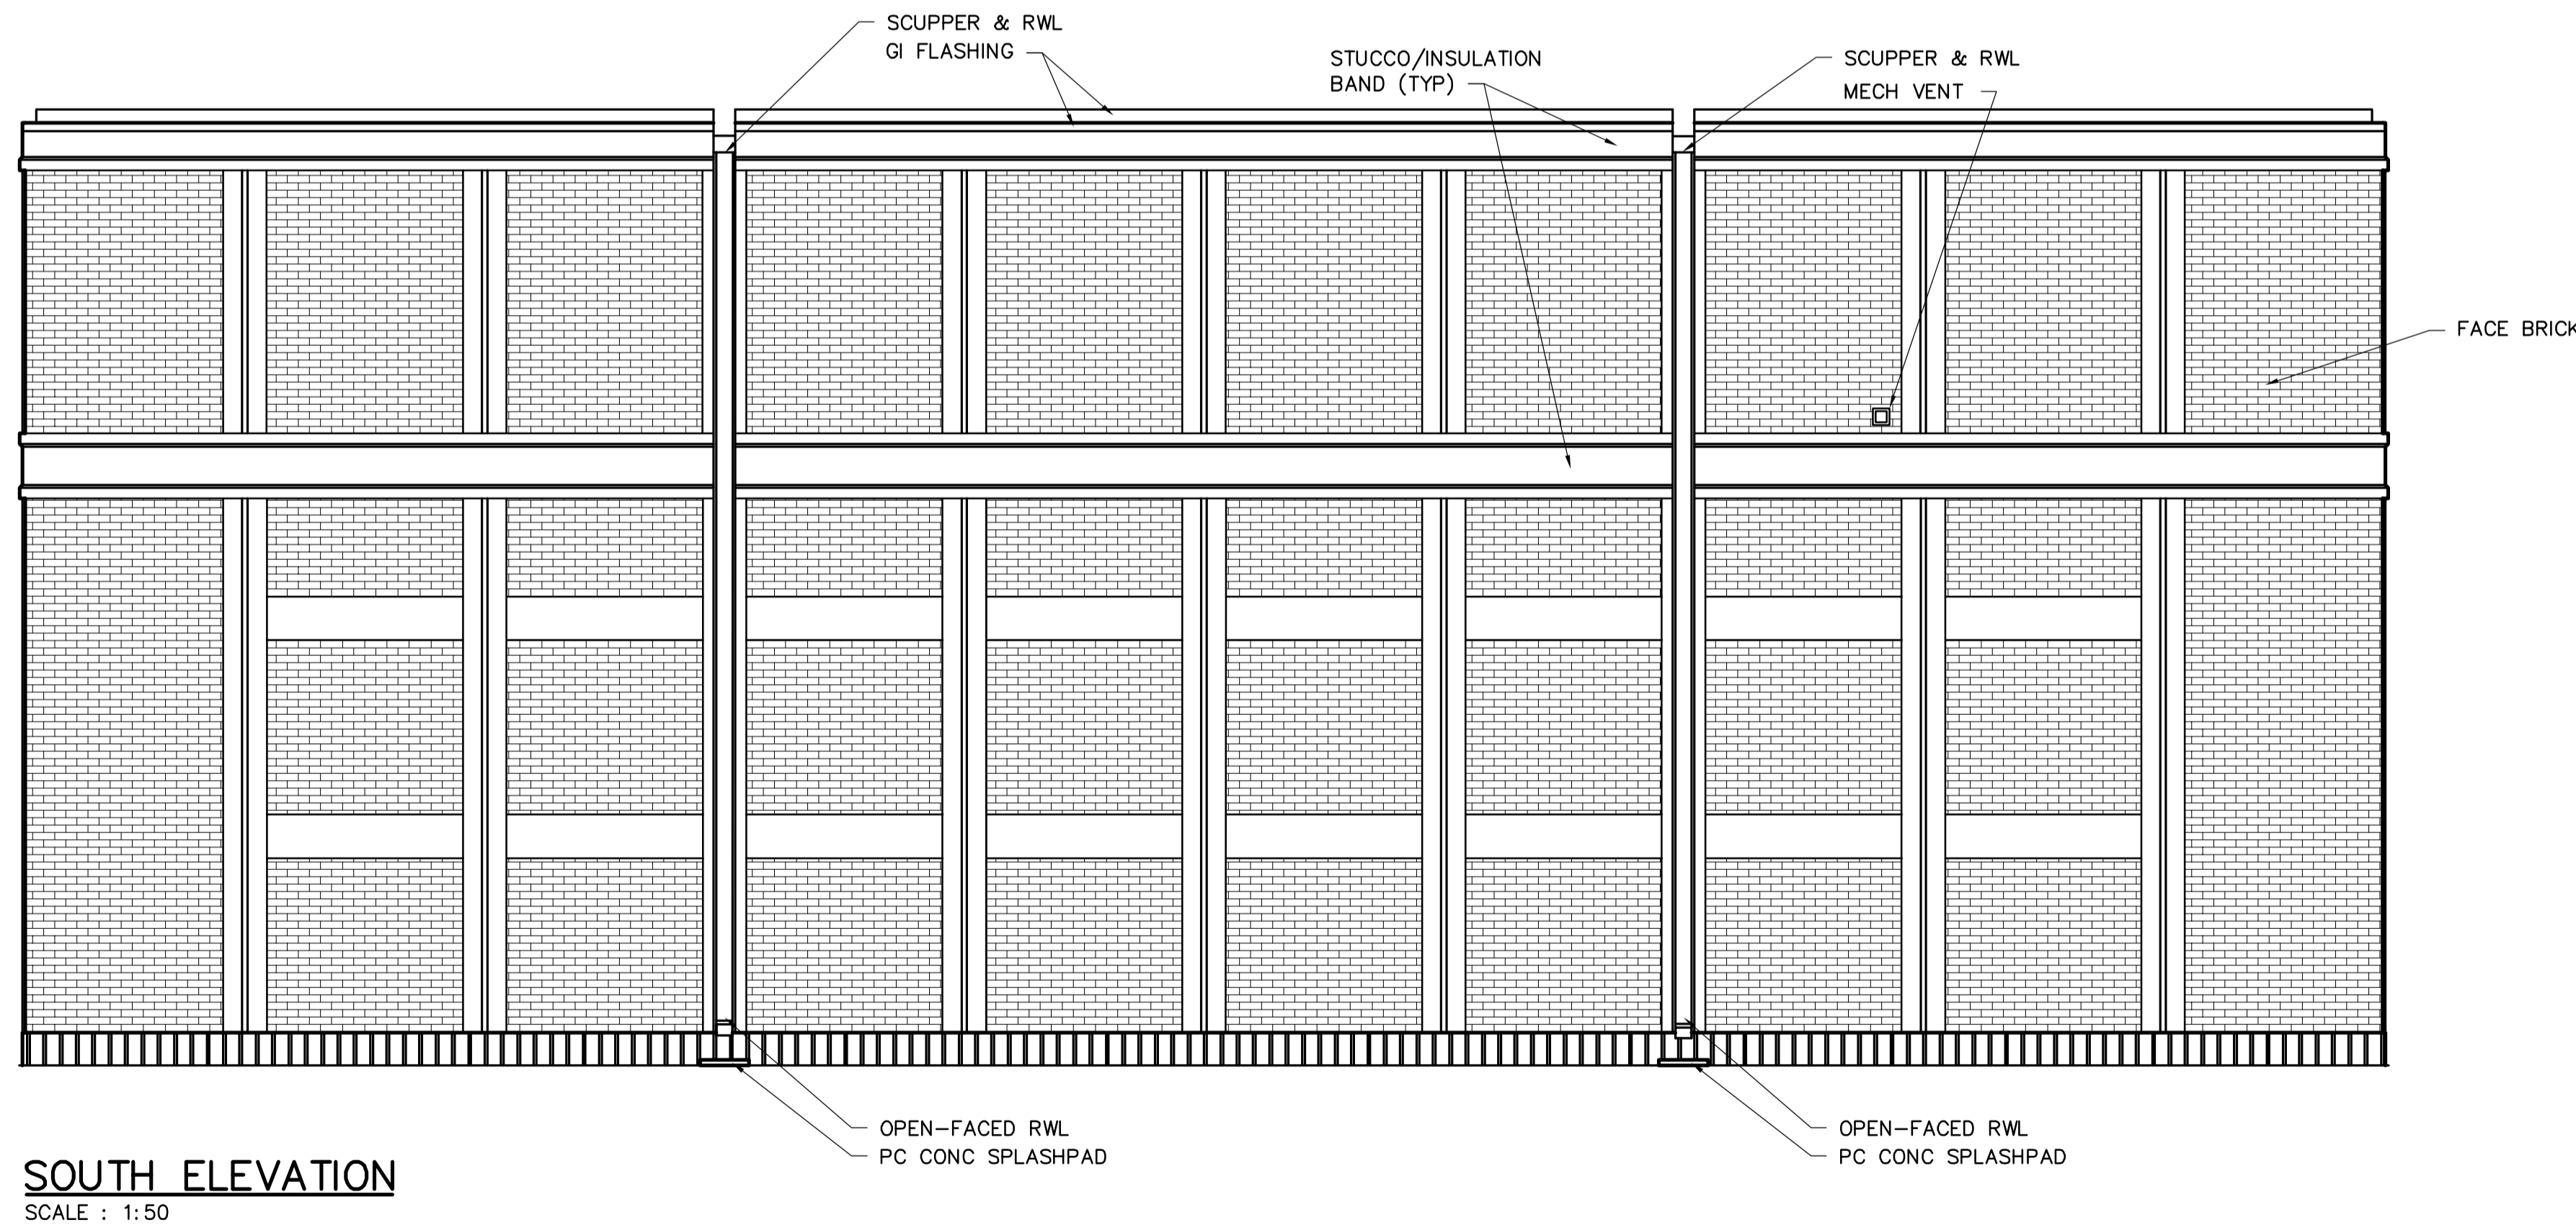


SOUTH ELEVATION
SCALE : 1:50

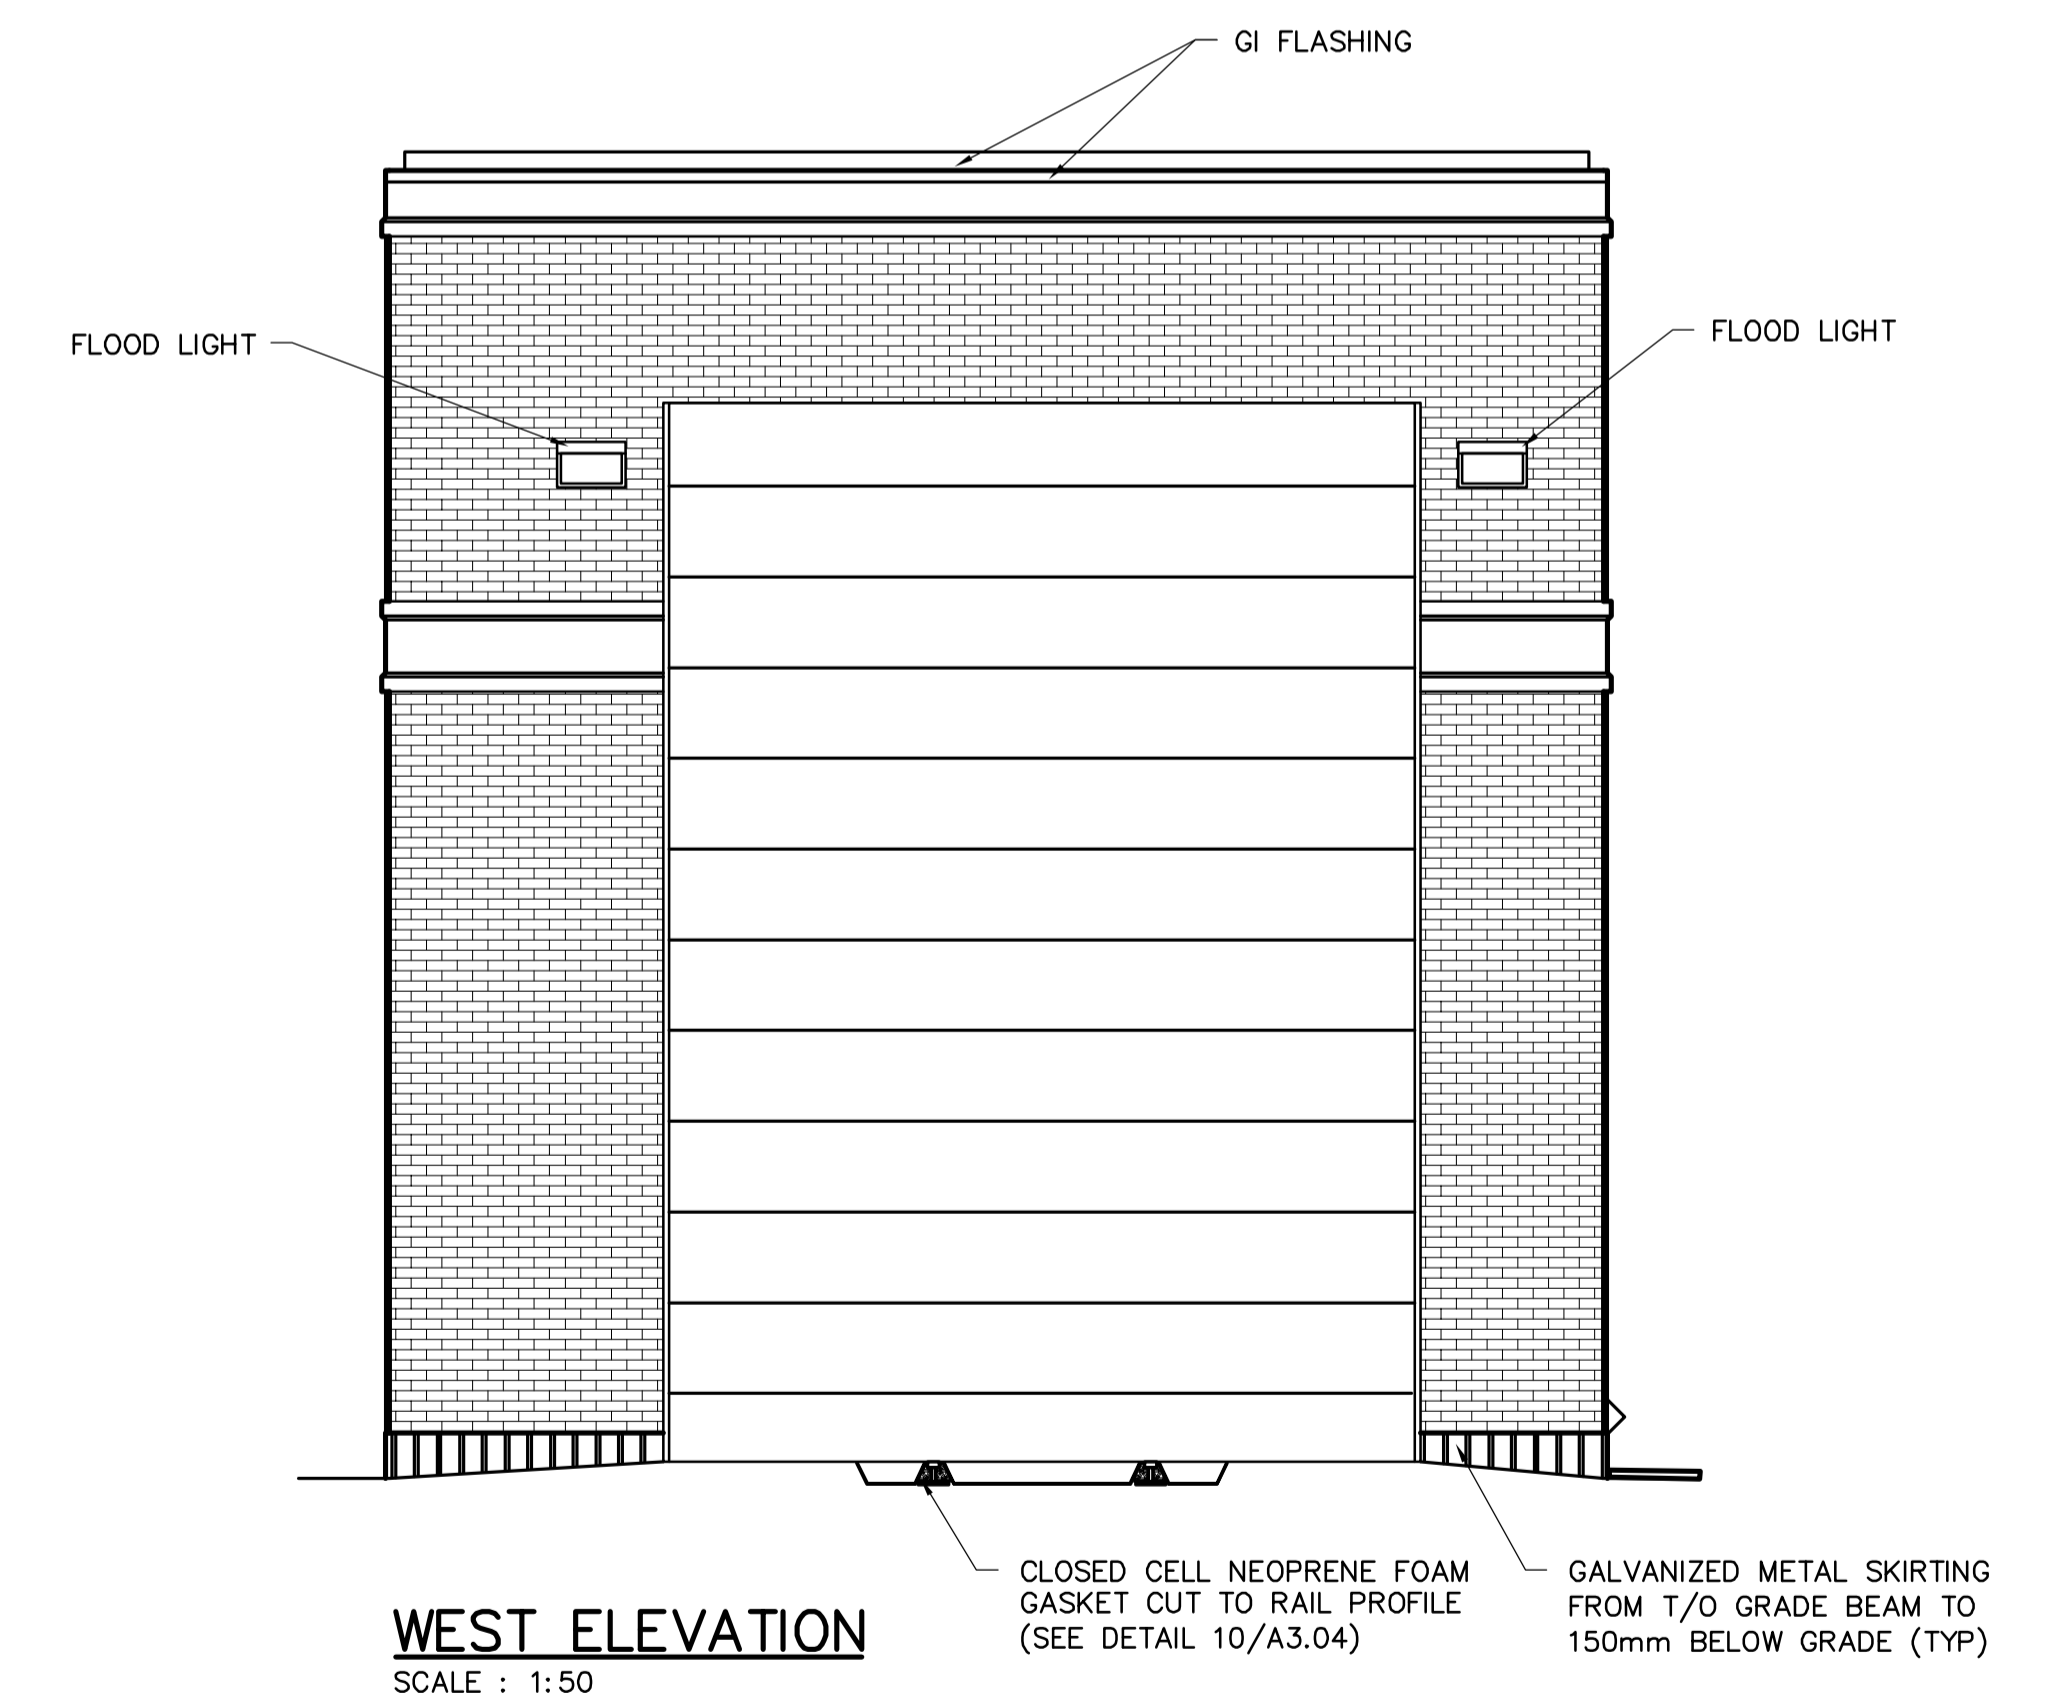

WEST ELEVATION
SCALE : 1:50


NOTE: INSULATION/STUCCO PILASTERS, & BANDS TO MATCH EXISTING BUILDING HEIGHTS & DIMENSIONS (TYP).

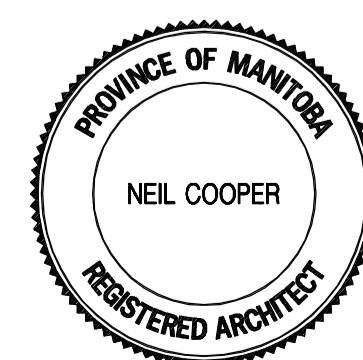

B.M. ELEV.			
NO.	REVISIONS	DATE	BY
01	611-2005 ADDENDUM 1	06/01/13	LK
00	ISSUED FOR TENDER	05/12/2	LK



DESIGNED BY	NC	CHECKED BY	NC
DRAWN BY	LK	APPROVED BY	D. TANIGUCHI
SCALE:	AS SHOWN	RELEASED FOR CONSTRUCTION BY:	K. MARTENS
DATE	2005/10/10	DATE	05/12/02

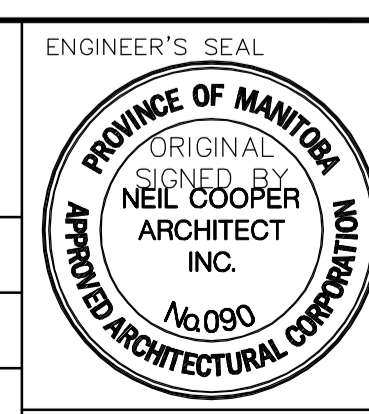

CONSULTANT DRAWING NO. CA2.02

THE CITY OF WINNIPEG
WATER AND WASTE DEPARTMENT
ENGINEERING DIVISION

NEWPCC CENTRATE NUTRIENT TREATMENT
PHOSPHORUS REMOVAL FACILITY
CONTRACT No. 1

ARCHITECTURAL
RAILCAR BUILDING
EXTERIOR ELEVATIONS

CITY FILE NUMBER
SHEET 2 OF 4
CITY DRAWING NUMBER
1-001F-A-B0002-001-01-D