




1 TYPICAL WALL SECTION
 A3.03/A3.04 SCALE 1:10

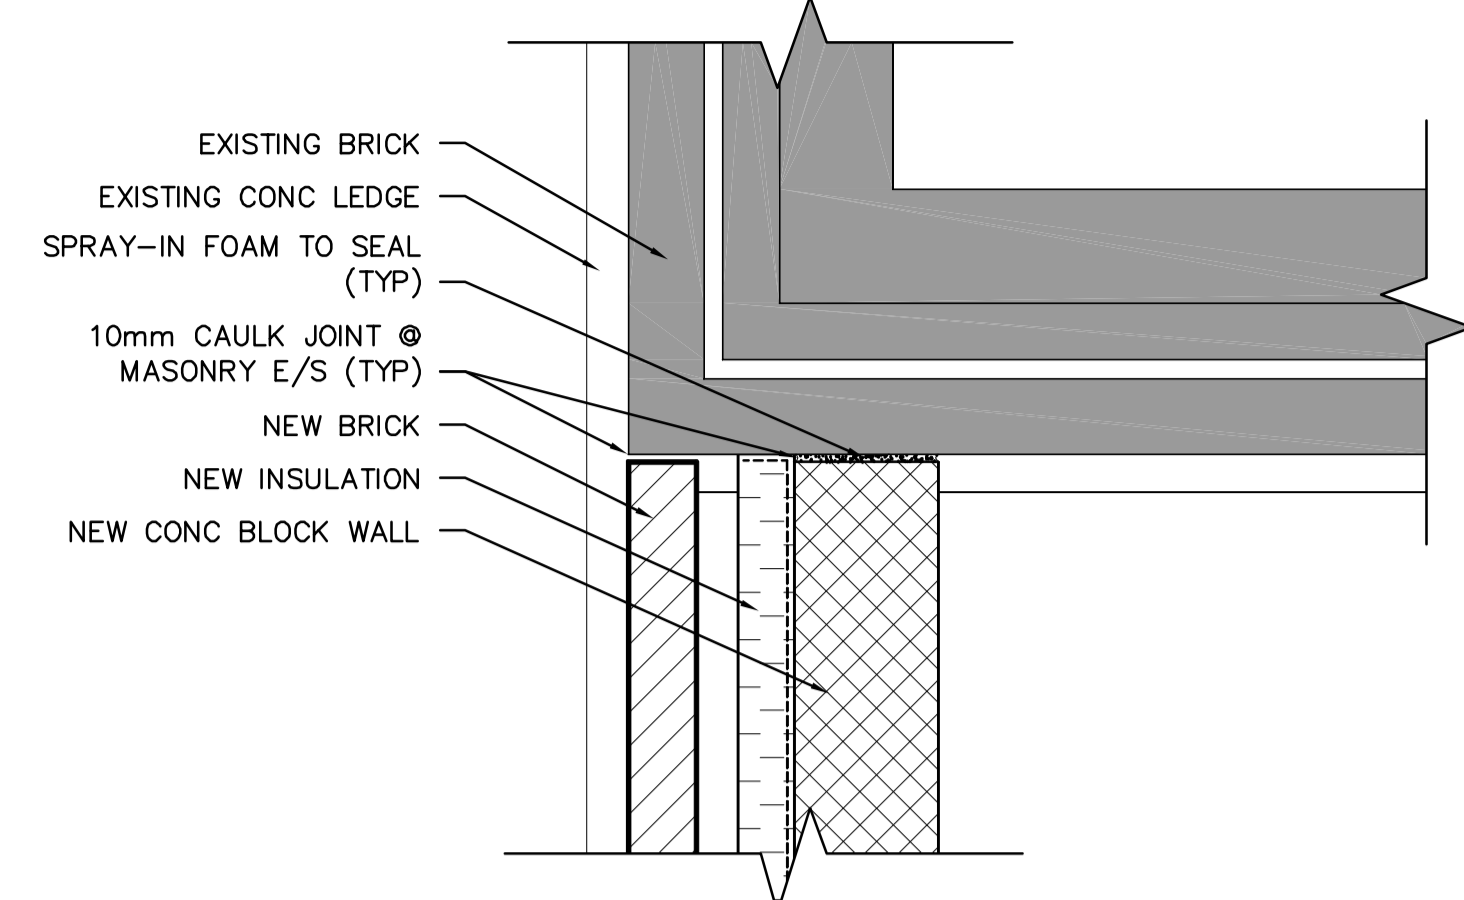


2 WEST BUILDING CONNECTION DETAIL
 A3.01/A3.04 SCALE 1:10

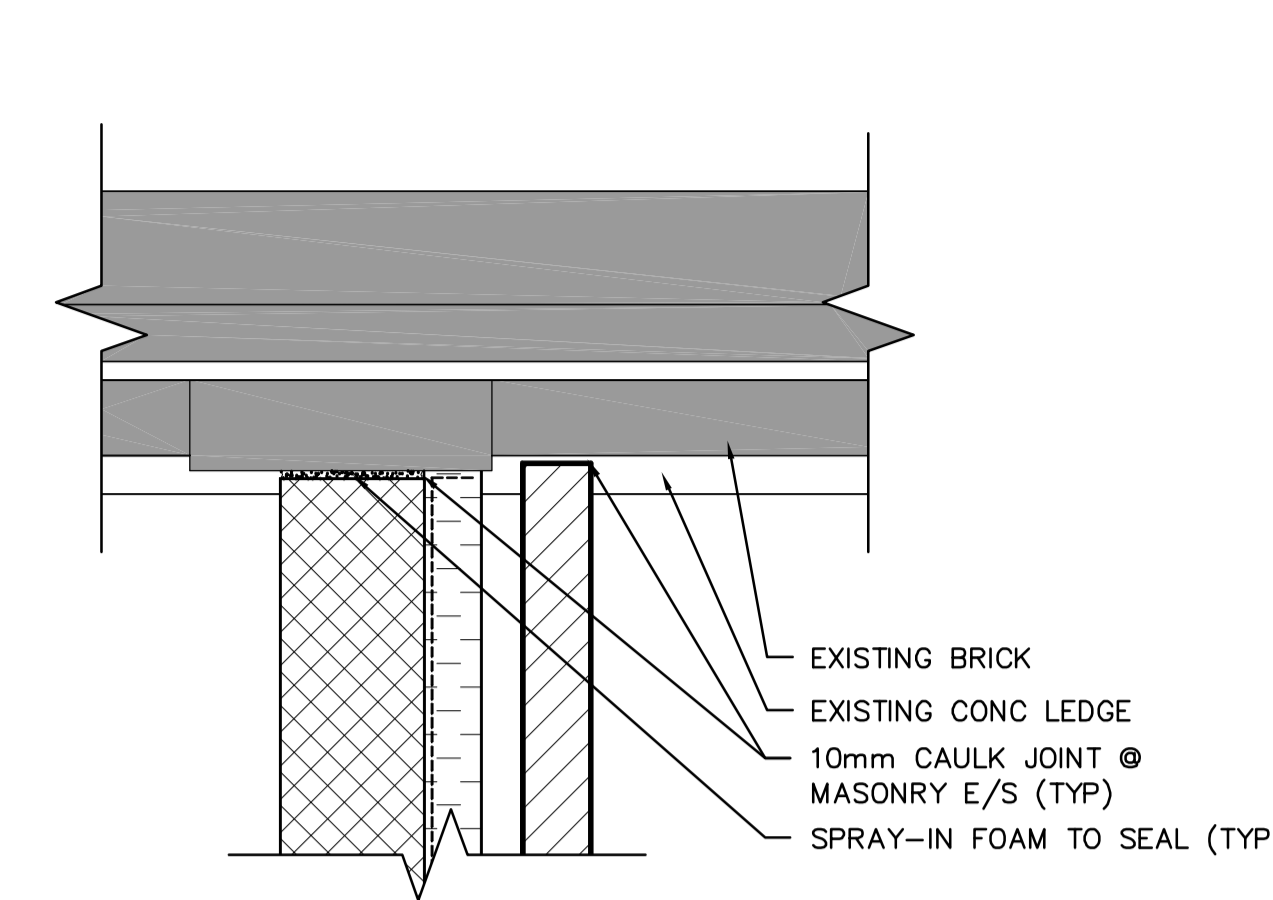


3 EAST BUILDING CONNECTION DETAIL
 A3.01/A3.04 SCALE 1:10

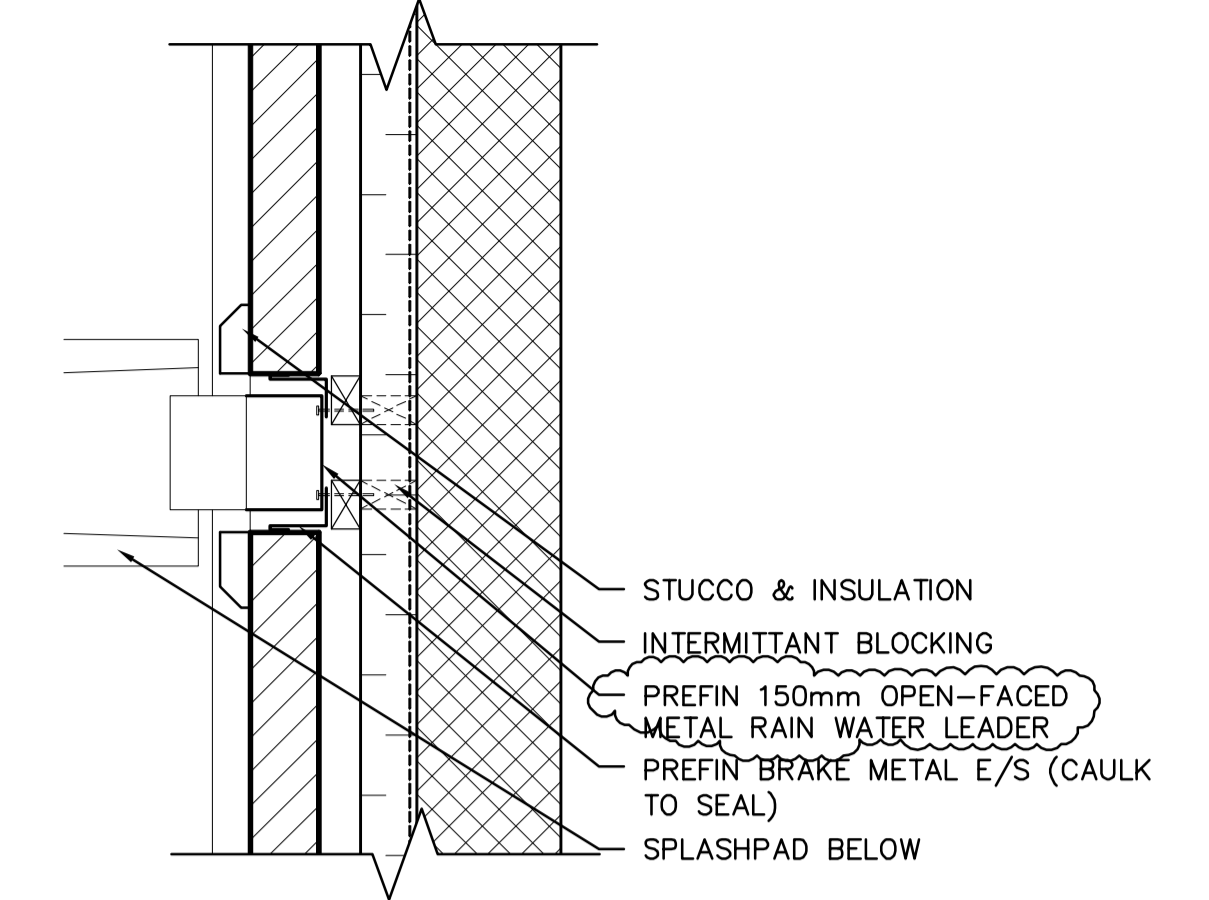


4 RAIN WATER LDR PLAN DETAIL
 A3.01/A3.04 SCALE 1:10

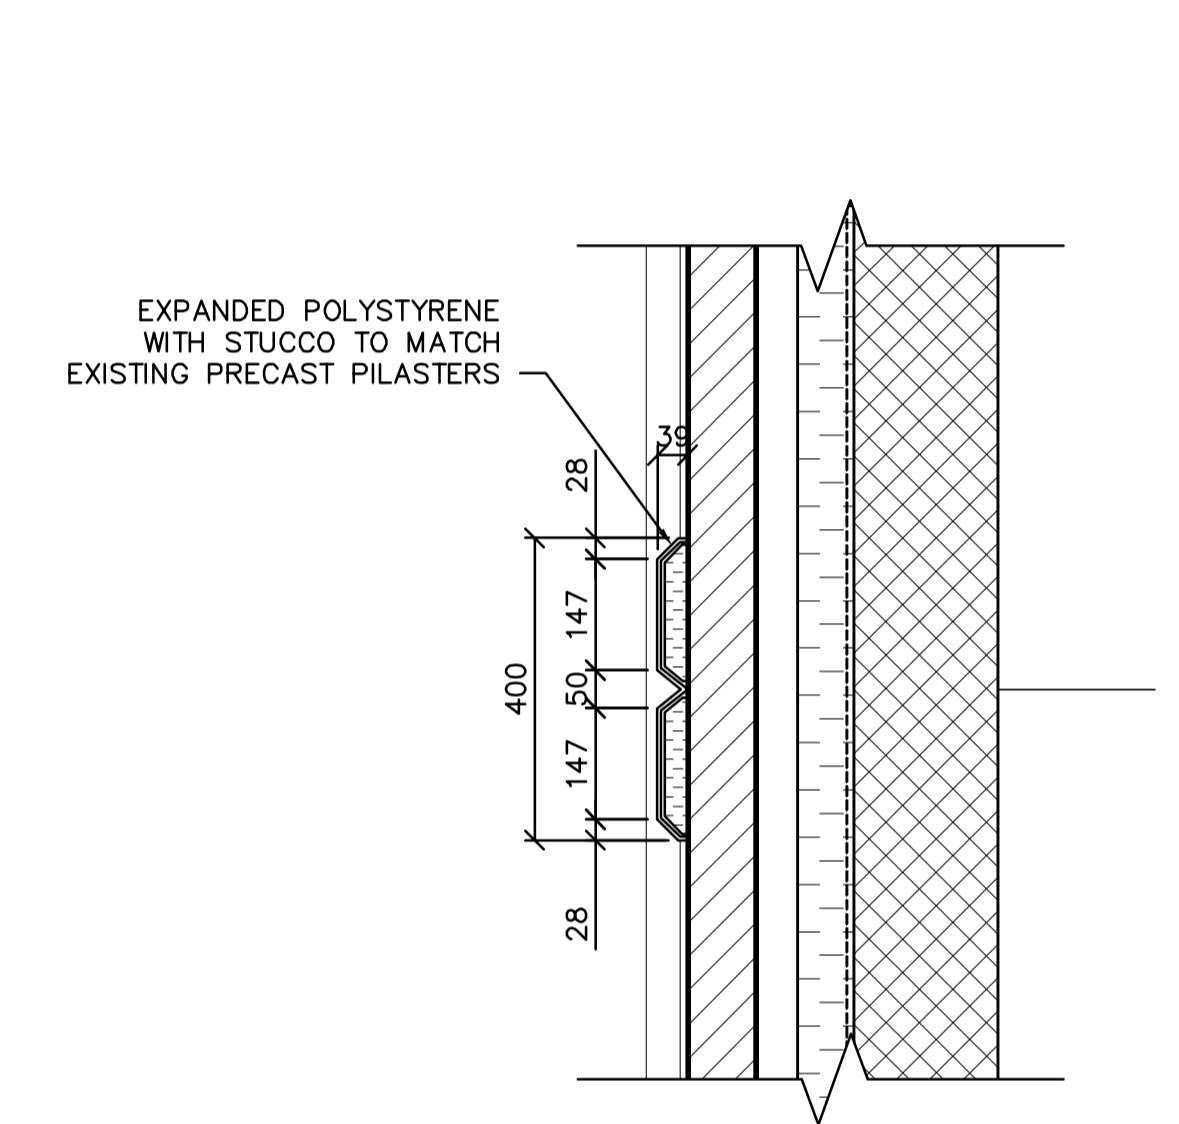


5 TYP STUCCO PILASTER PLAN DETAIL
 A3.01/A3.04 SCALE 1:10

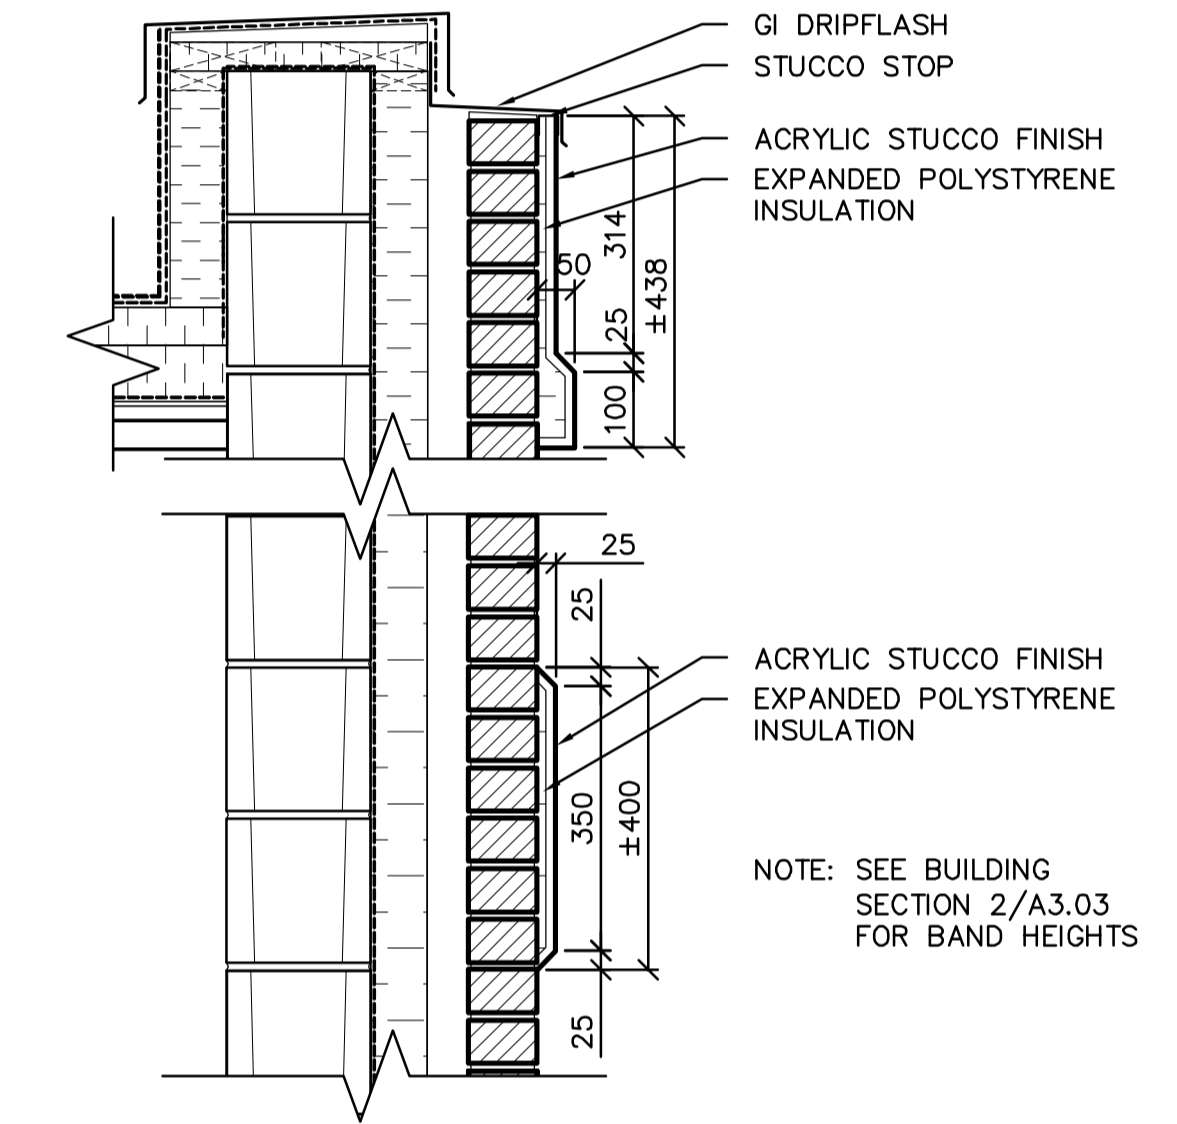


6 TYP STUCCO BAND SECTION DETAIL
 A3.03/A3.04 SCALE 1:10

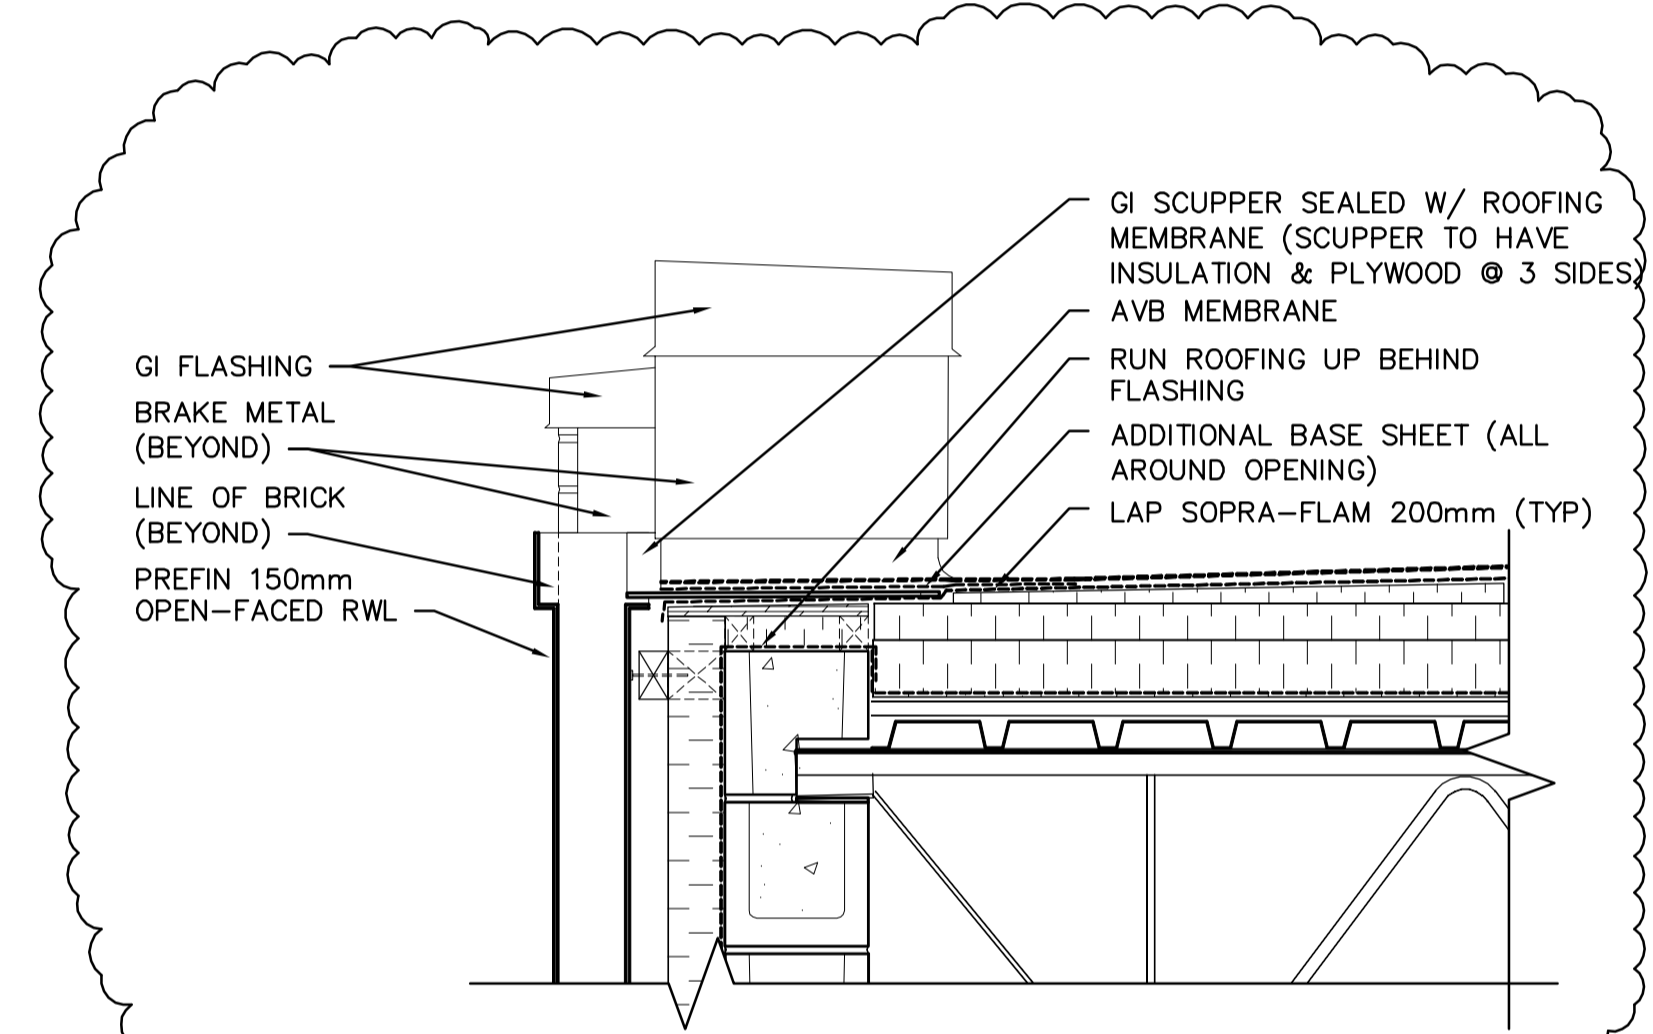

7 SCUPPER DETAIL
 A3.03/A3.04 SCALE 1:10

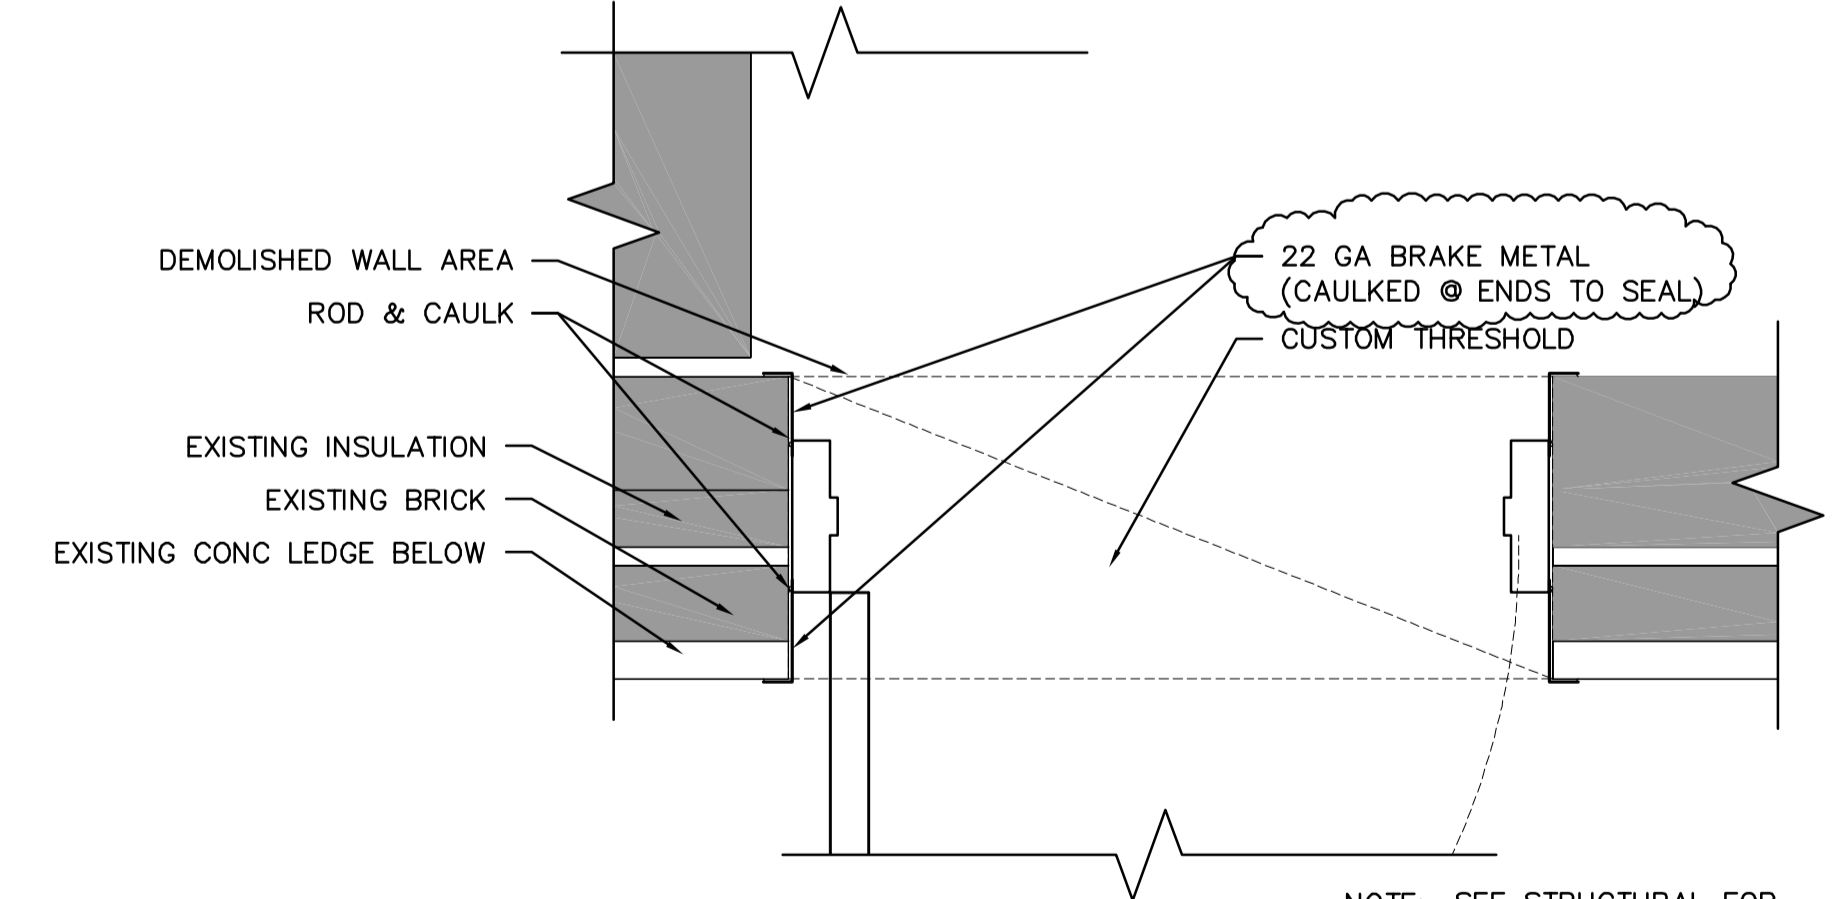

8 DOOR FRAME DETAIL
 A3.01/A3.04 SCALE 1:10

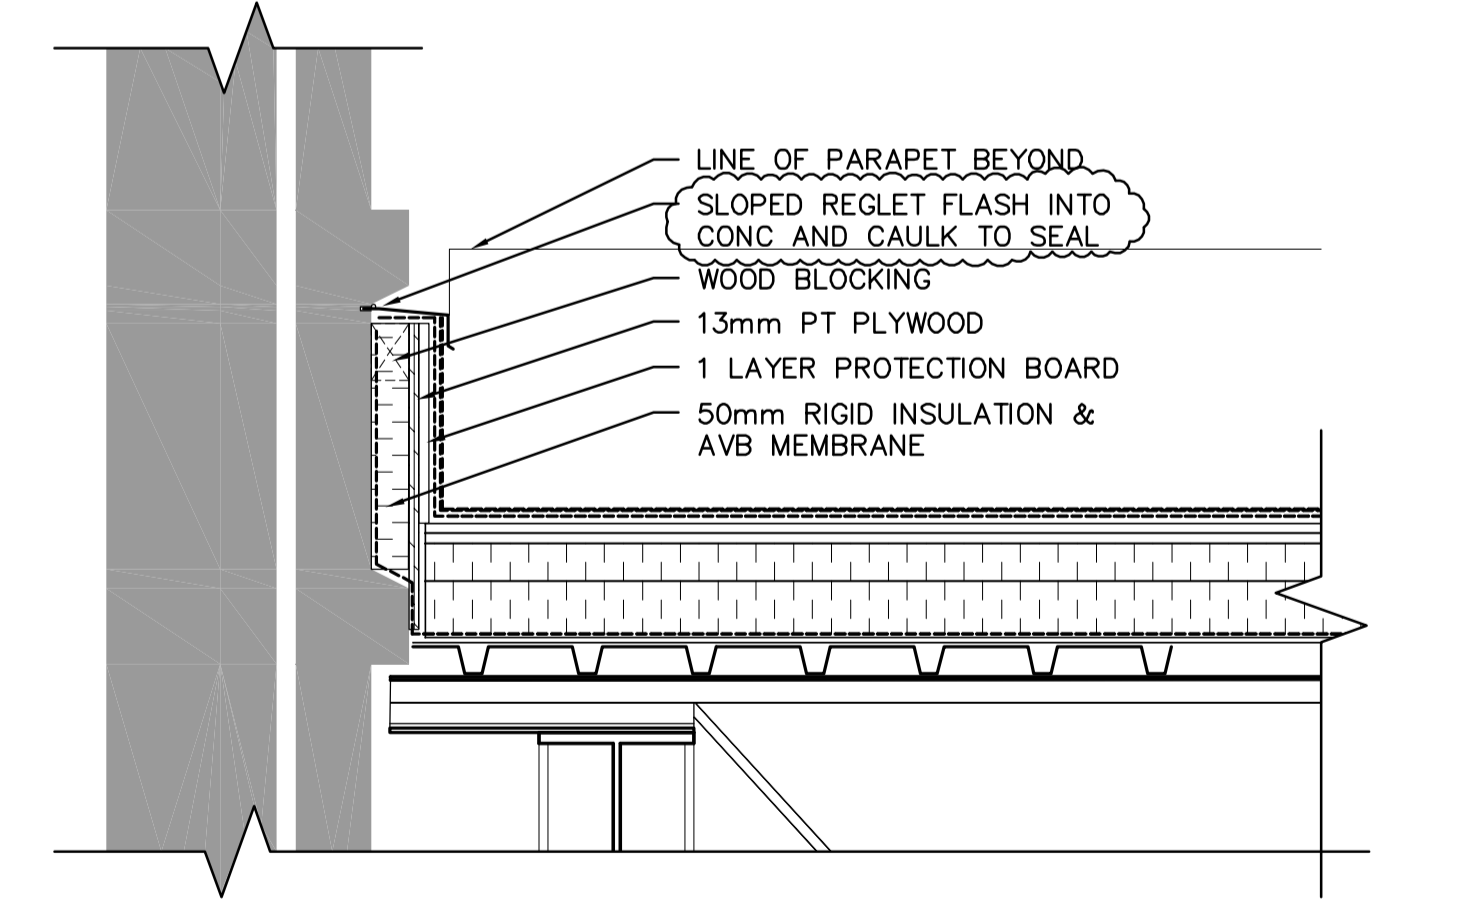

9 ROOF TIE-IN DETAIL
 A3.03/A3.04 SCALE 1:10



B.M. ELEV.		 A Tyco International Ltd. Company		ENGINEER'S SEAL ORIGINAL DESIGN BY NEIL COOPER ARCHITECT INC. No.090 APPROVED ARCHITECTURAL CORPORATION	
DESIGNED BY	NC	CHECKED BY	NC	DESIGNED BY NC CHECKED BY NC DRAWN BY LK APPROVED BY D. TANIGUCHI SCALE: AS SHOWN RELEASED FOR CONSTRUCTION BY: K. MARTENS NO. REVISIONS DATE BY DATE 2005/10/05 DATE 05/12/02	

THE CITY OF WINNIPEG
WATER AND WASTE DEPARTMENT
ENGINEERING DIVISION

NEWPCC CENTRATE NUTRIENT TREATMENT PHOSPHORUS REMOVAL FACILITY
 CONTRACT No. 1

ARCHITECTURAL CHEMICAL STORAGE BUILDING SECTIONS & DETAILS

CITY FILE NUMBER SHEET 4 OF 4
 CITY DRAWING NUMBER 1-010F-A-80008-001-02-D